

ISSUE
02/28/12
ISSUED FOR PERMIT
AND PRICING

HARRELL
ARCHITECTS, LP
9272 Katy Fwy. #200
Houston, Texas 77024
Tel: 713.722.7071
Fax: 713.722.7072


CONSULTANTS
Habib & Associates, Inc.
11111 Eastchase Parkway #100
Houston, Texas 77037
Tel: 281.486.1515
Fax: 281.486.1516
Contact: Kris Odom (832) 645-0488



Cafe Express Restaurant
PROJECT ADDRESS
1111 Eastchase Parkway #100
Houston, Texas 77037

PROJECT NUMBER
11052
SHEET NAME
PLUMBING
FLOOR PLAN
SHEET NUMBER

P1.1

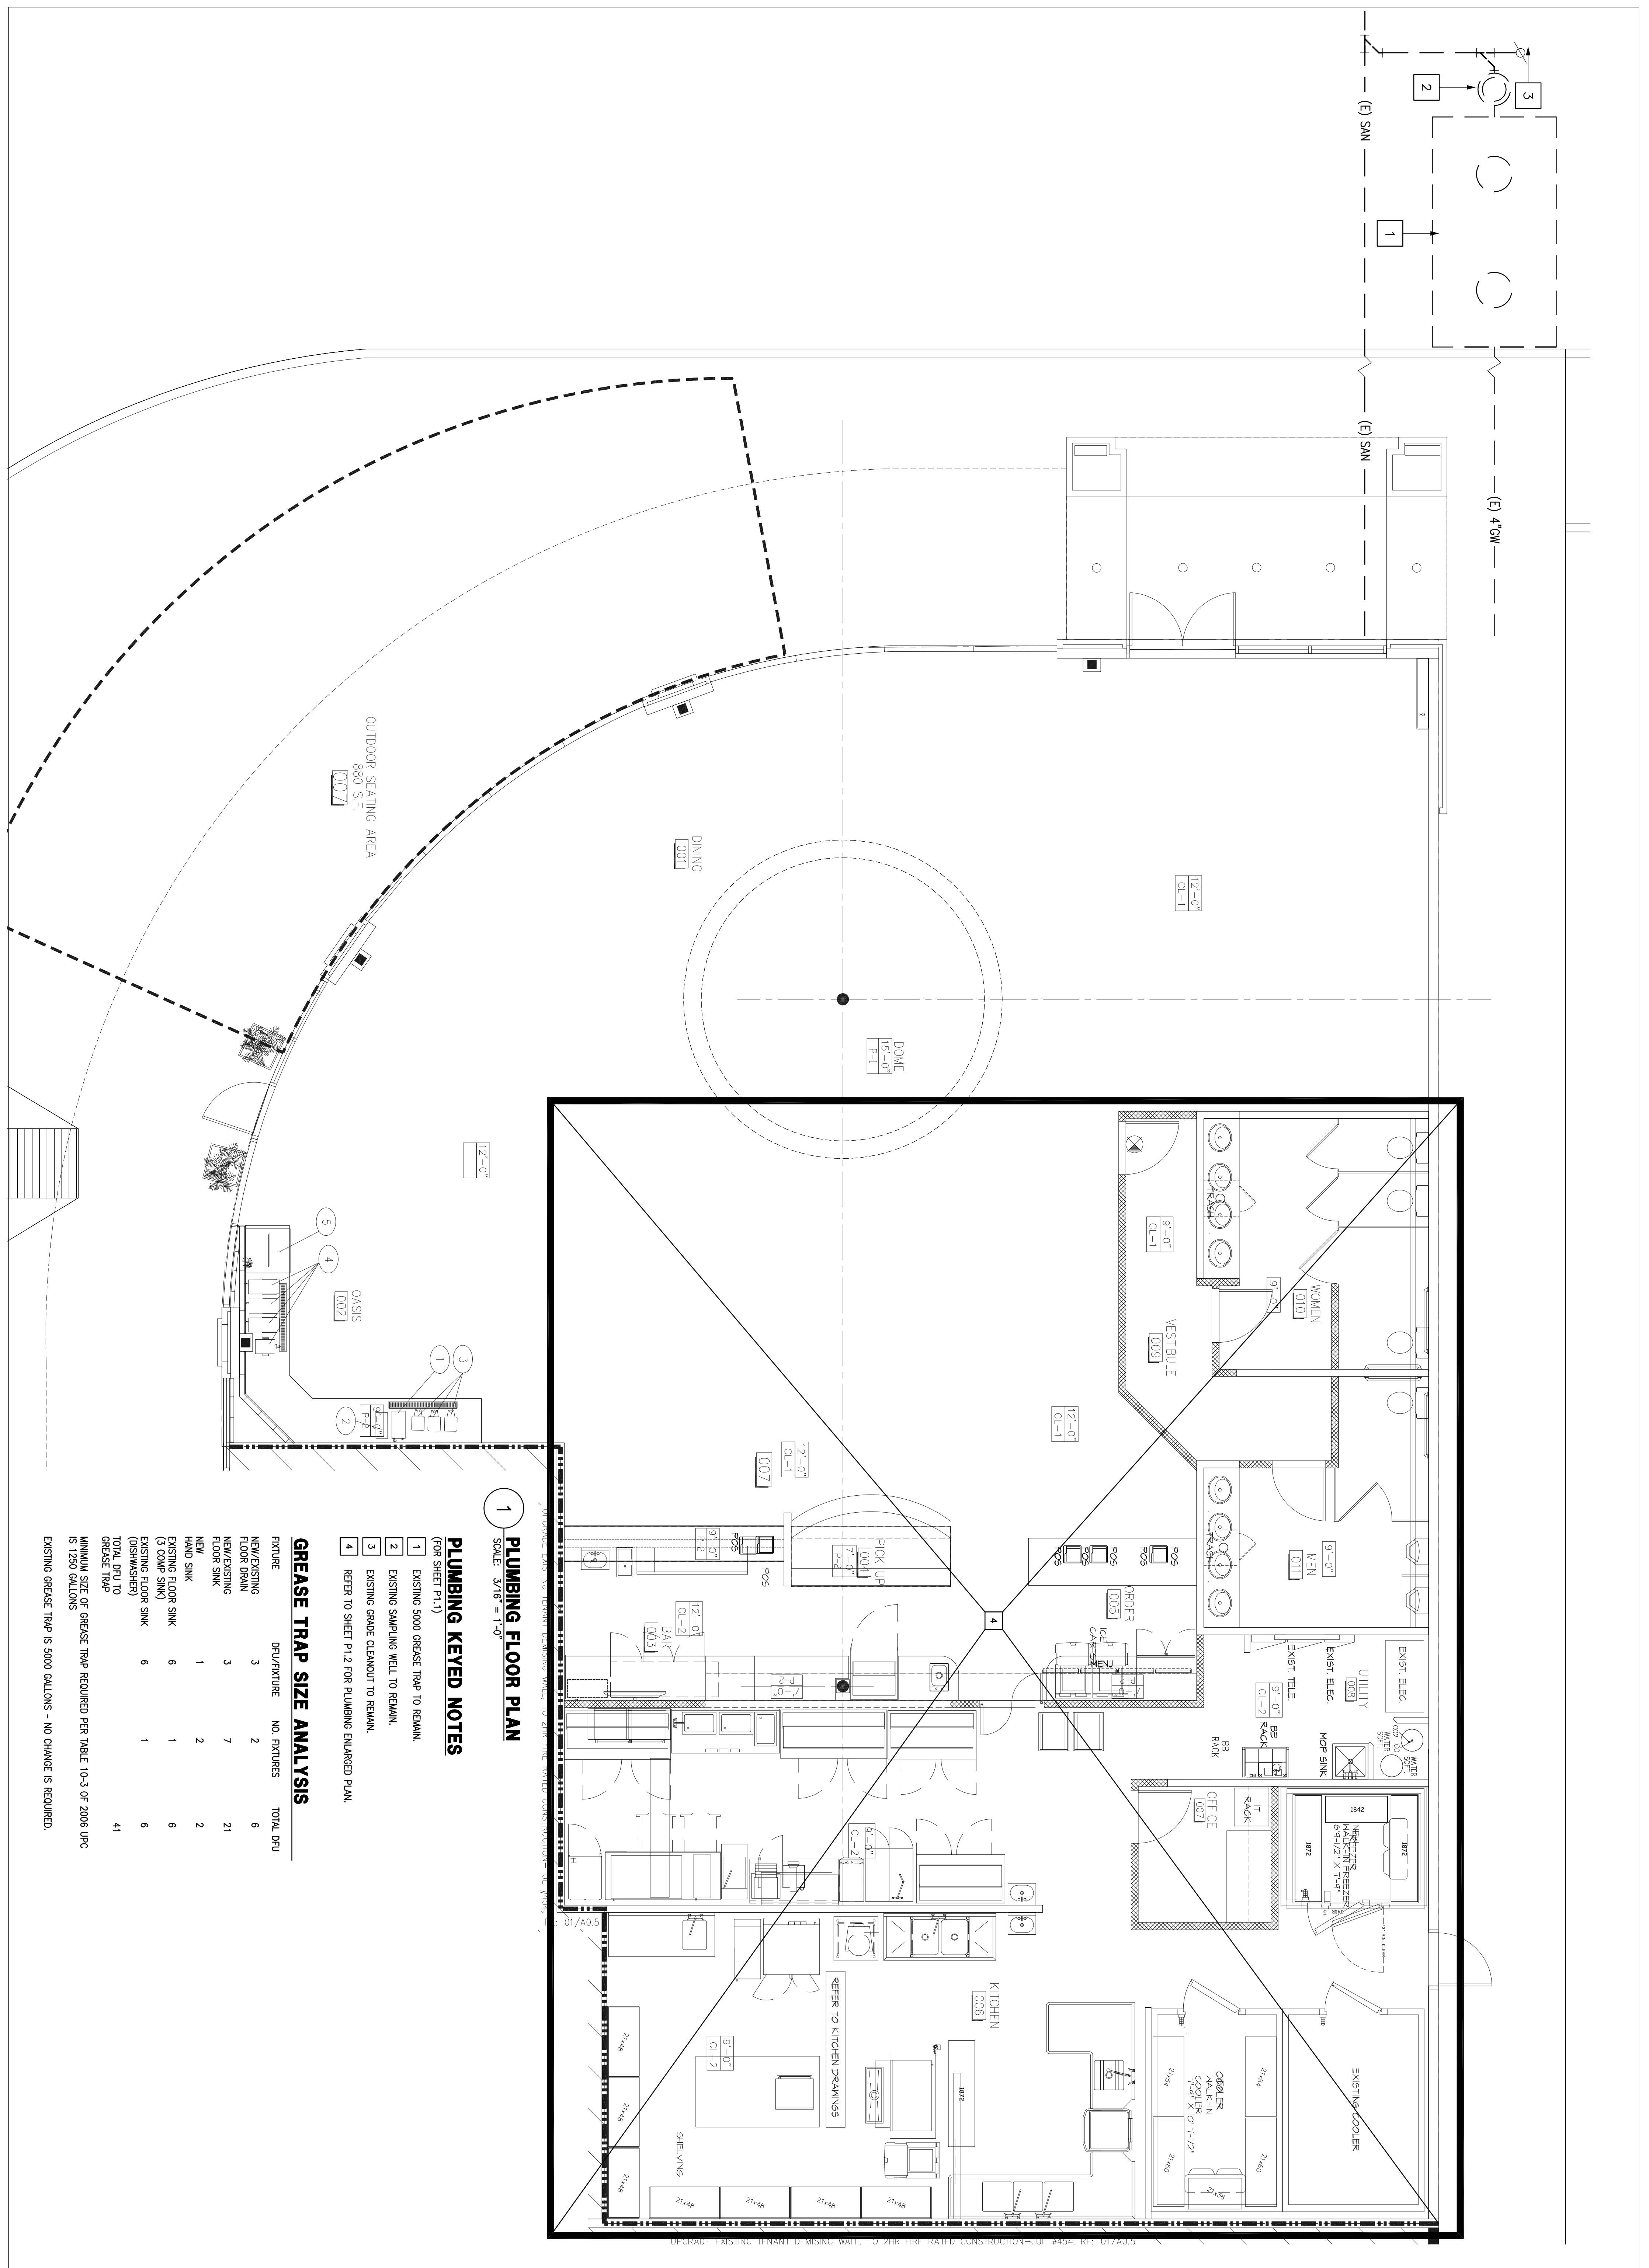

1 PLUMBING FLOOR PLAN
SCALE: 3/16" = 1'-0"

PLUMBING KEYED NOTES
(FOR SHEET P1.1)

- 1 EXISTING 5000 GREASE TRAP TO REMAIN.
- 2 EXISTING SAMPLING WELL TO REMAIN.
- 3 EXISTING GRADE CLEANOUT TO REMAIN.
- 4 REFER TO SHEET P1.2 FOR PLUMBING ENLARGED PLAN.

GREASE TRAP SIZE ANALYSIS

FIXTURE	DFU/FIXTURE	NO. FIXTURES	TOTAL DFU
NEW/EXISTING FLOOR DRAIN	3	2	6
NEW/EXISTING FLOOR SINK	3	7	21
NEW SINK	1	2	2
EXISTING FLOOR SINK (3 COMP SINK)	6	1	6
EXISTING FLOOR SINK (DISHWASHER)	6	1	6
TOTAL DFU TO GREASE TRAP			41

MINIMUM SIZE OF GREASE TRAP REQUIRED PER TABLE 10-3 OF 2006 UPC IS 1250 GALLONS
EXISTING GREASE TRAP IS 5000 GALLONS - NO CHANGE IS REQUIRED.