

ISSUE
 02/28/12 ISSUED FOR PERMIT
 AND PRICING

HARRELL
 ARCHITECTS, LP

9276 Katy Fwy. #200
 Houston, Texas 77024
 Tel: 713.722.7071
 Fax: 713.722.7072


CONSULTANTS
 Habibe & Associates, Inc.
 4000 West Loop South, Suite 510
 4627 Southloop Fwy., Suite 830
 Houston, Texas 77041
 Contact: Kris Odom (832) 454-0368



Cafe Express Restaurant
 PROJECT ADDRESS
 1111 Eldridge Parkway #100
 Houston, Texas 77077

PROJECT NUMBER
 11052

SHEET NAME
**PLUMBING
 RISER DIAGRAMS**
 SHEET NUMBER

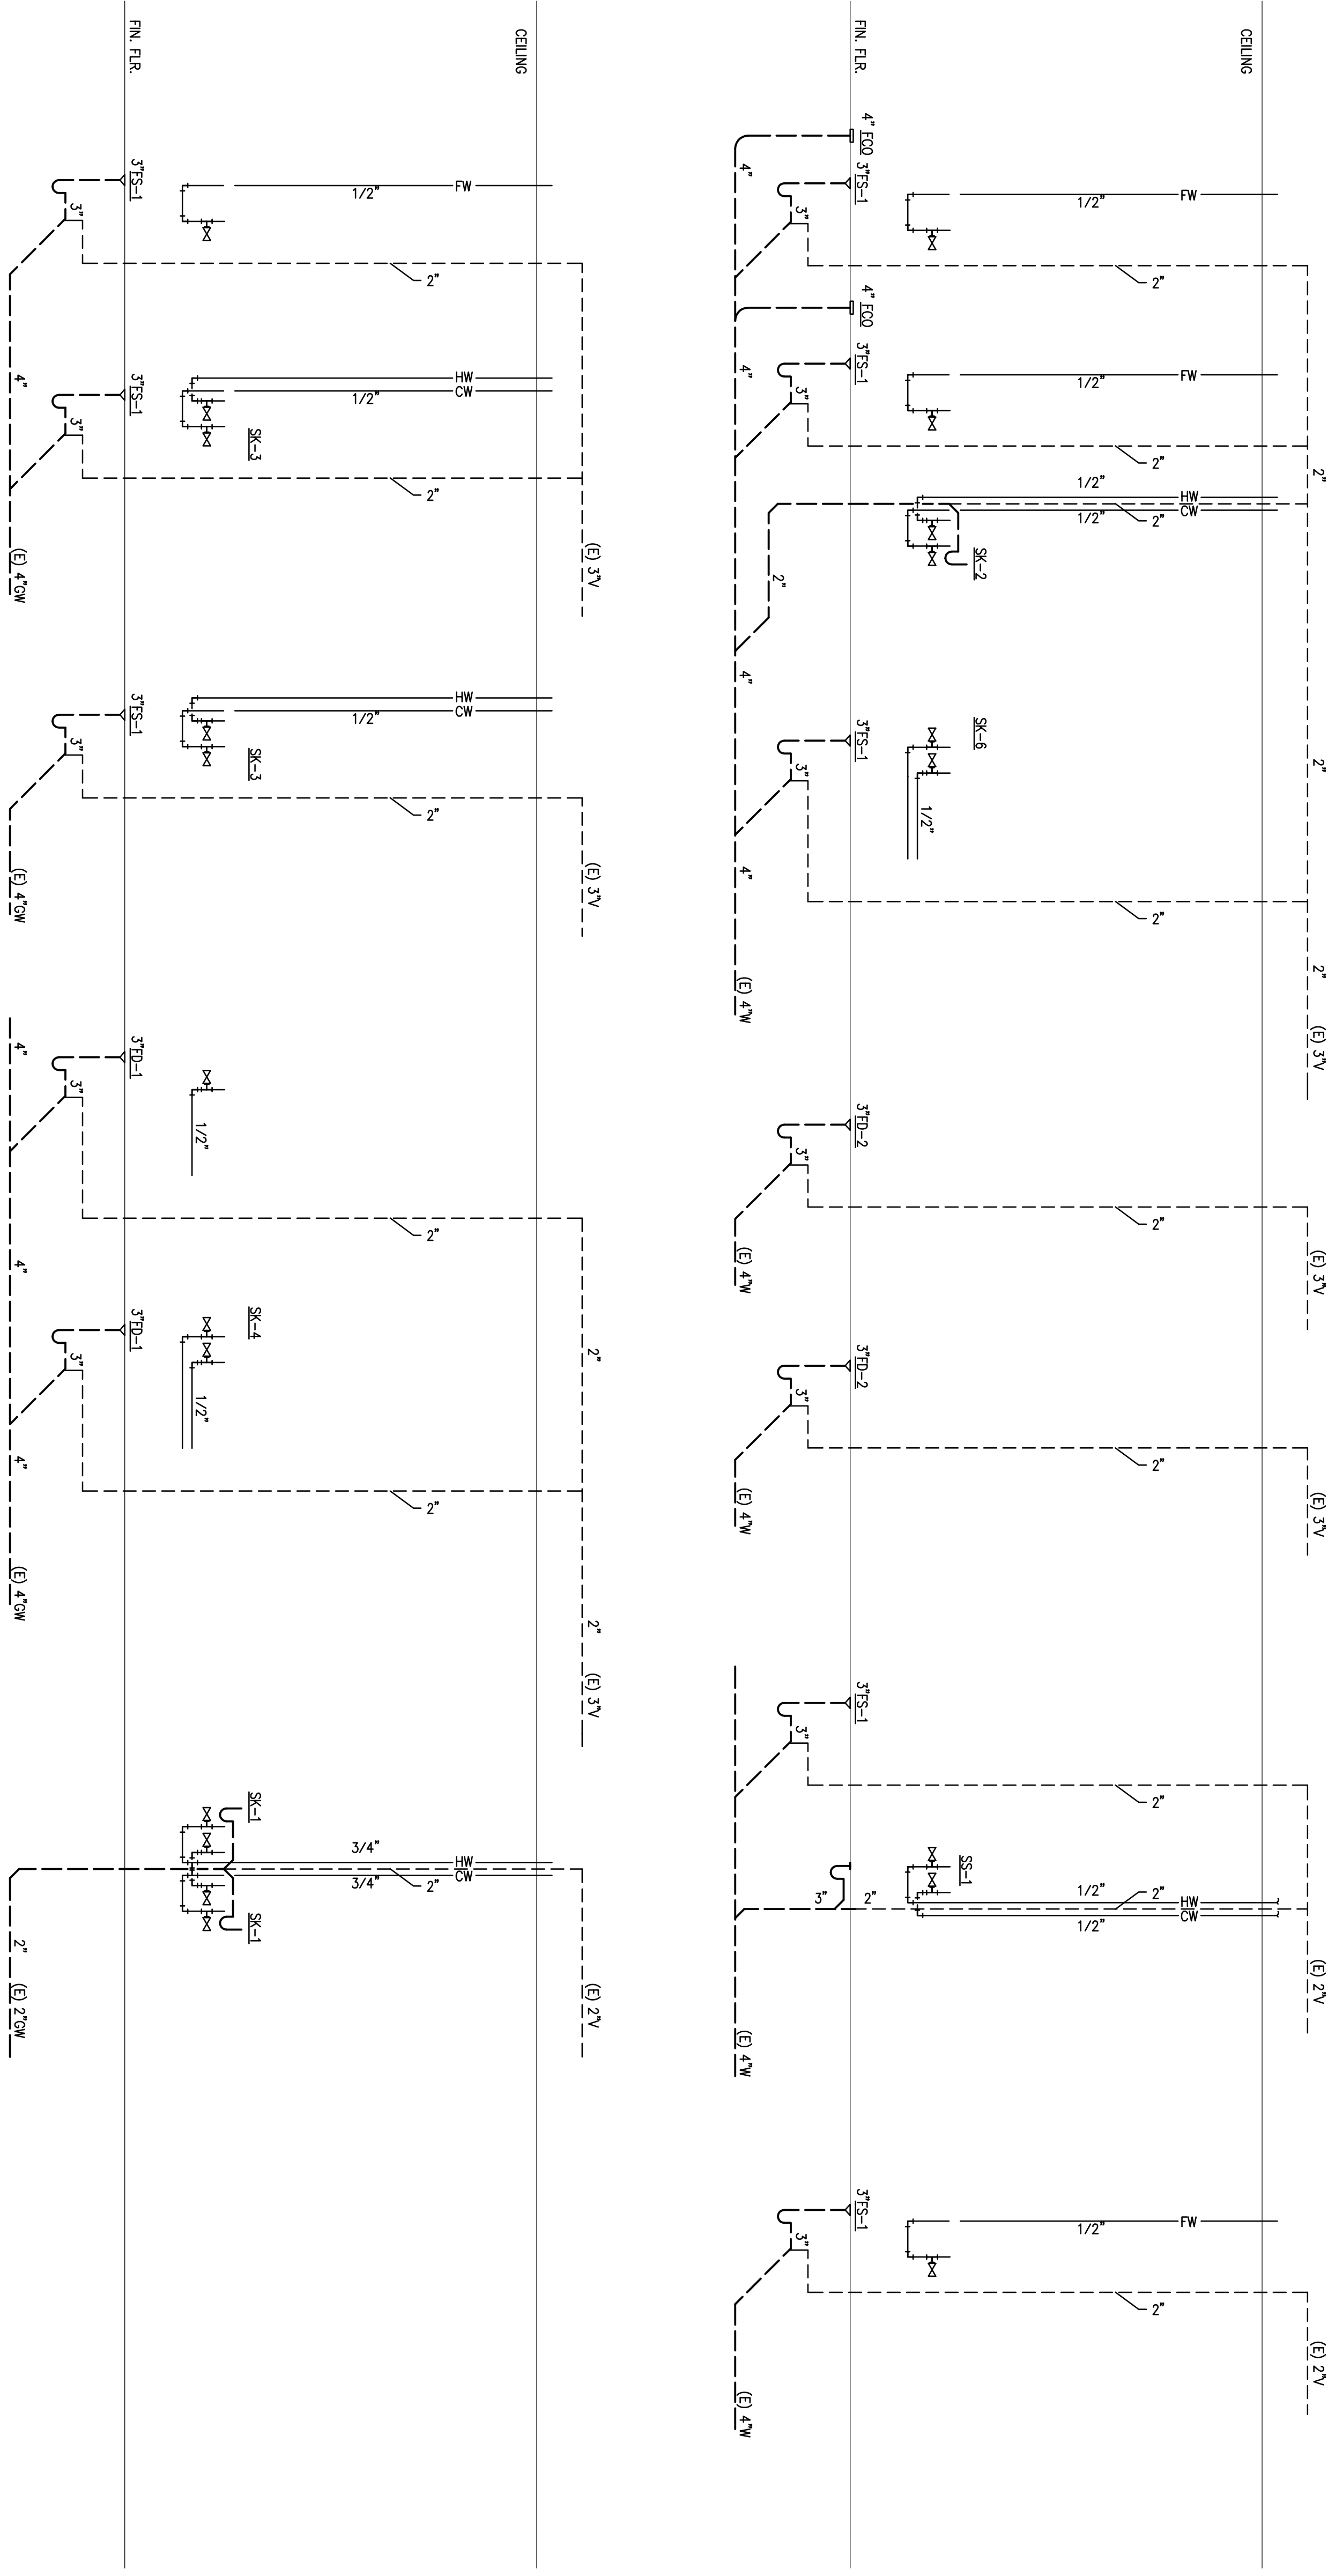

1 PLUMBING RISER DIAGRAMS
 SCALE: NONE

P5.1