


THIS DRAWING AND THE DESIGN SHOWN IS THE PROPERTY OF ART LOVE DESIGN STUDIO. THE REPRODUCTION, COPYING, OR USE OF THIS DRAWING WITHOUT THE WRITTEN CONSENT OF ART LOVE DESIGN STUDIO IS PROHIBITED AND ANY INFRINGEMENT WILL BE SUBJECT TO LEGAL ACTION. ©2010 ART LOVE DESIGN STUDIO

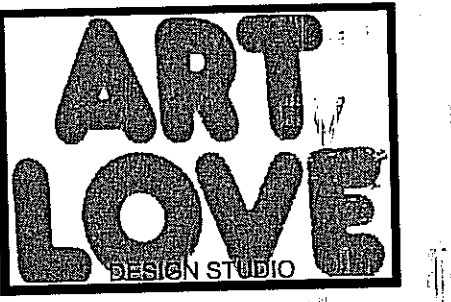

ART LOVE DESIGN STUDIO
6606 HUNTERS RIDGE
DALLAS, TX 75248
ph. 940.595.2739

FRINGE SALON AND COLOR BAR
2400 WEST ALABAMA HOUSTON, TEXAS 77098


STUDIO
38 EIGHTH
DOWNTOWN
HOUSTON, TEXAS
77002

REVISIONS:

PROJECT NUMBER:
1001
DATE:
10.13.10
ISSUE:
CONSTRUCT
DRAWING TYPE:
R.C.P.

DRAWING NUMBER:
A3.01

- LIGHTING LEGEND**
- RECESSED CEILING LIGHT FIXTURE
 - ◄● RECESSED CEILING LIGHT FIXTURE-DIRECTIONAL
 - PENDANT MOUNTED CEILING LIGHT FIXTURE
 - ◄○ PENDANT MOUNTED CEILING LIGHT FIXTURE-DIRECTIONAL
 - ⊕ WALL MOUNTED LIGHT FIXTURE
 - UNDERCABINET PUCK LIGHT
 - ⊙ SPECIALITY LIGHTING TO BE CHOSEN BY OWNER
 - ▬ LINEAR SUSPENDED CEILING LIGHT FIXTURE
 - ⋯ UNDERCABINET STRIP LIGHT
 - ⊕ CEILING MOUNTED EXHAUST FAN
 - ⊙ SMOKE DETECTOR
 - ⊕ THERMOSTAT
 - ⊕ SECURITY KEYPAD
 - ⊙ SECURITY MOTION DETECTOR

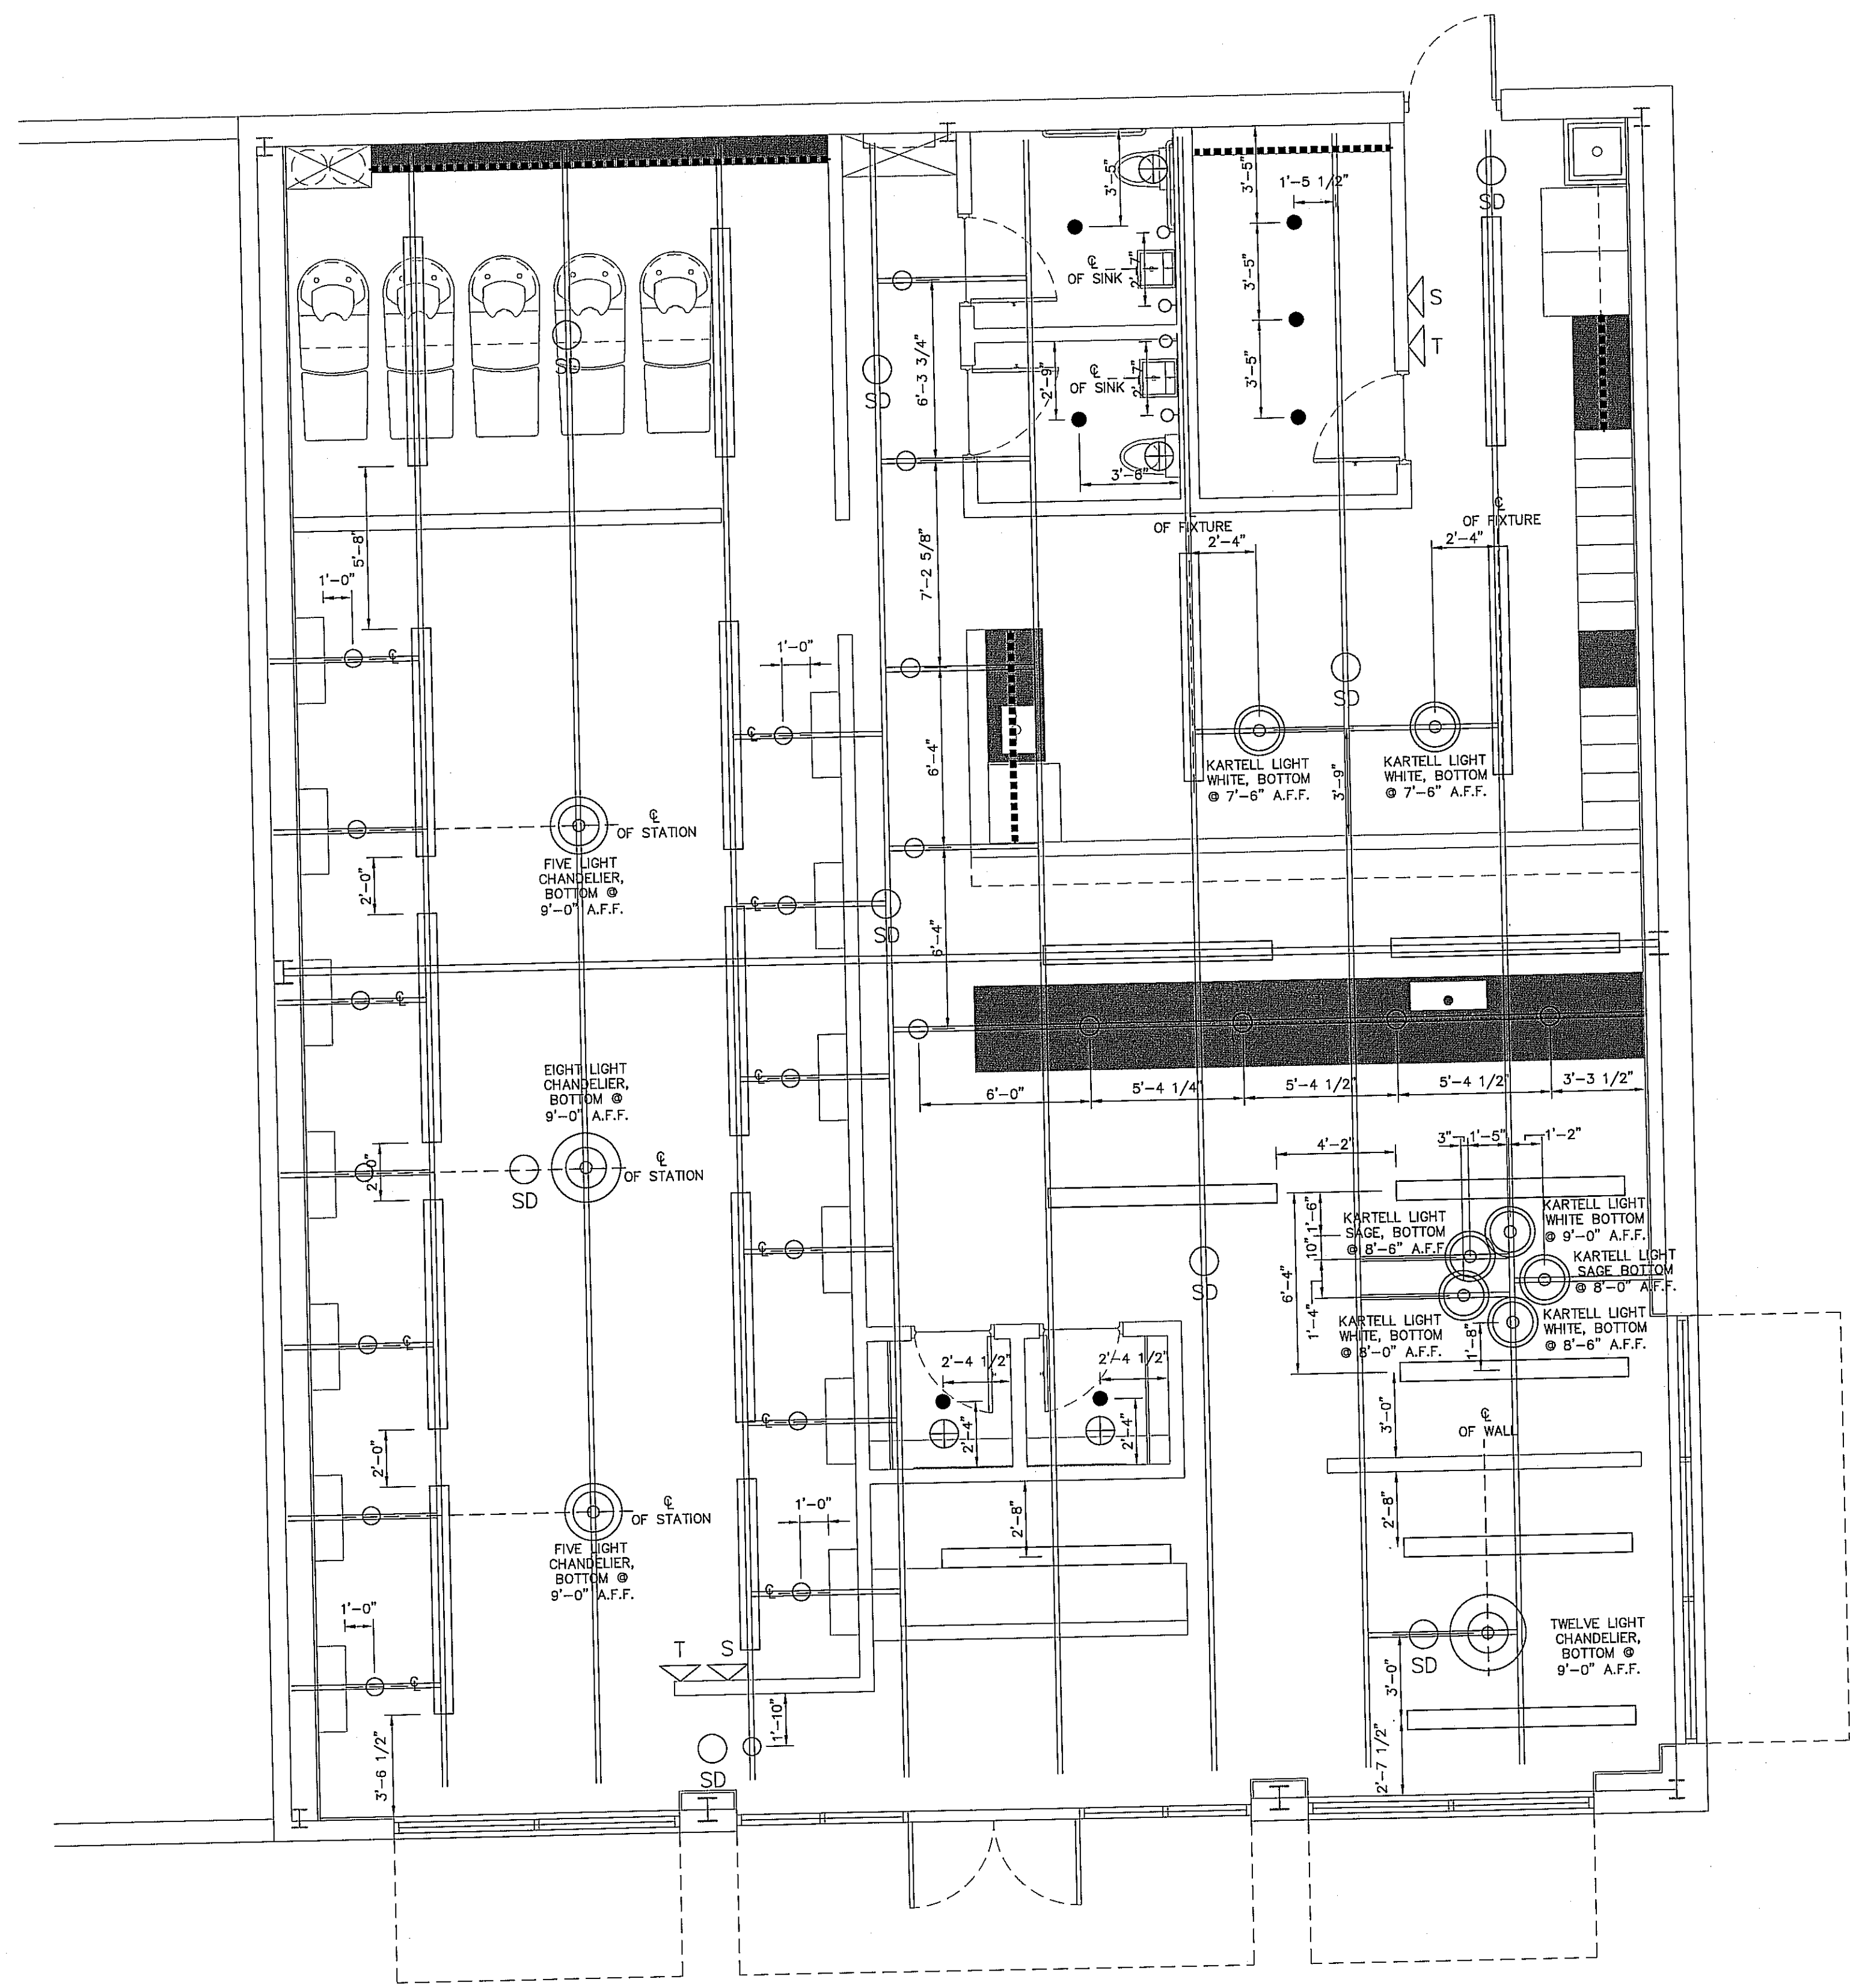

RCP SCHEDULE **02**

REFLECTED CEILING PLAN 01
SCALE: 1/8"=1'-0"