

FLOOR PLAN NOTES

ALL CAULKING SHALL BE COORDINATED BY THE GENERAL CONTRACTOR. ITEMS THAT ABUT TO WALL SHALL HAVE FINISH CAULK, AND SHALL INCLUDE, BUT NOT LIMITED TO, DOOR FRAMES, TOILETS, SINKS & CASEWORK. CAULK COLOR SHALL MATCH ADJACENT WALL COLOR UNLESS SPECIFIED OTHERWISE. SUBMIT COLOR SAMPLES FOR APPROVAL BY ARCHITECT.

GENERAL CONTRACTOR SHALL PROVIDE ALL NECESSARY BLOCKING (FIRE RATED AS REQ'D) CONCEALED WITHIN THE WALL AS REQUIRED FOR ANY AND ALL ITEMS THAT MUST BE SECURED TO THE WALL.


ALL DIMENSIONS ARE FINISH FACE TO FINISH FACE, U.N.O.

ALL CLOSETS SHALL BE 2'-0" DEEP INTERIOR FINISHED DIMENSION, U.N.O.

INSTALL ALL DOOR ROUGH OPENINGS 4" FROM ADJACENT WALL, U.N.O.


ALL RESTROOM WALLS, CEILING AND WALLS W/ PLUMBING FIXTURES SHALL HAVE CEMENTITIOUS BOARD ON THE WET SIDE(S).

- 1 PROVIDE 1/4" WATERLINE FOR ICEMAKER COFFEE.
- 2 GYPSUM BOARD BULKHEAD @ FILL IN AFF.
- 3 PLUMBING WALLS SHALL BE CONSTRUCTED USING 6" STUDS.
- 4 ROOF CRICKETS 0.25:12 SLOPE
- 5 PROVIDE 6" HALF ROUND GUTTER. MATCH FINISH OF METAL ROOFING.
- 6 DOWNSPOUT TO RAIN BARREL BELOW. MATCH FINISH OF METAL ROOFING AND GUTTER.

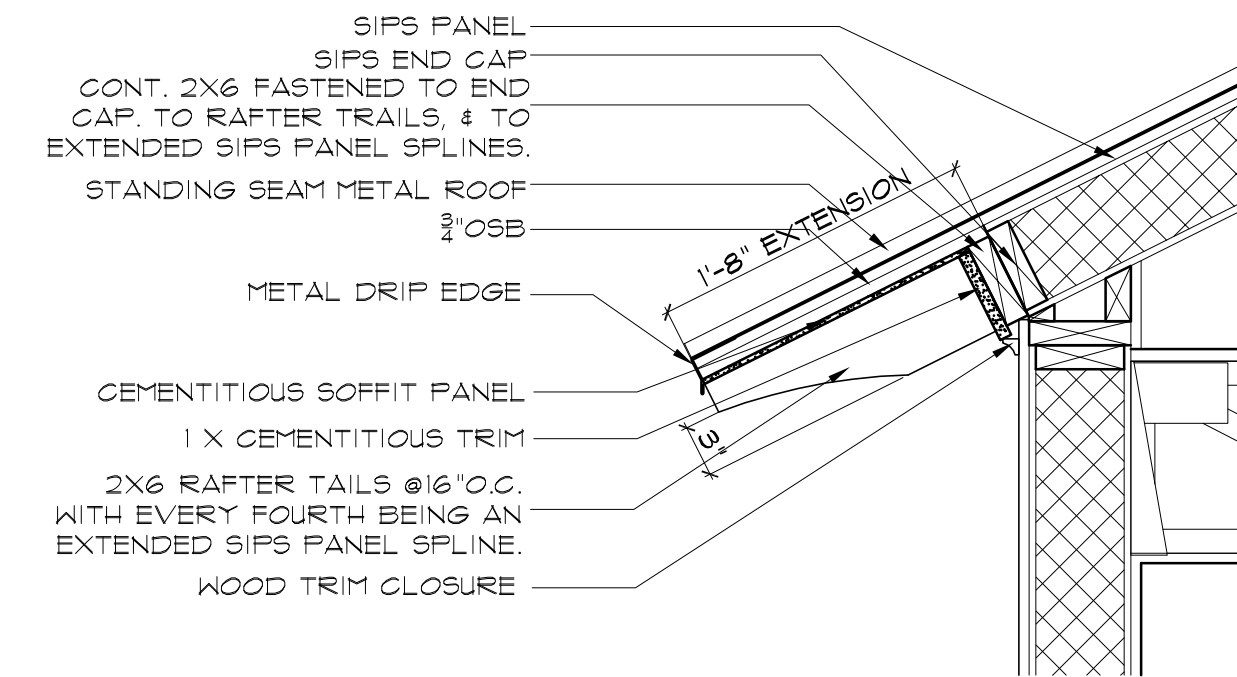

2-TYPICAL RAFTER TAIL EXTENSION

SCALE: 1"=1'-0"

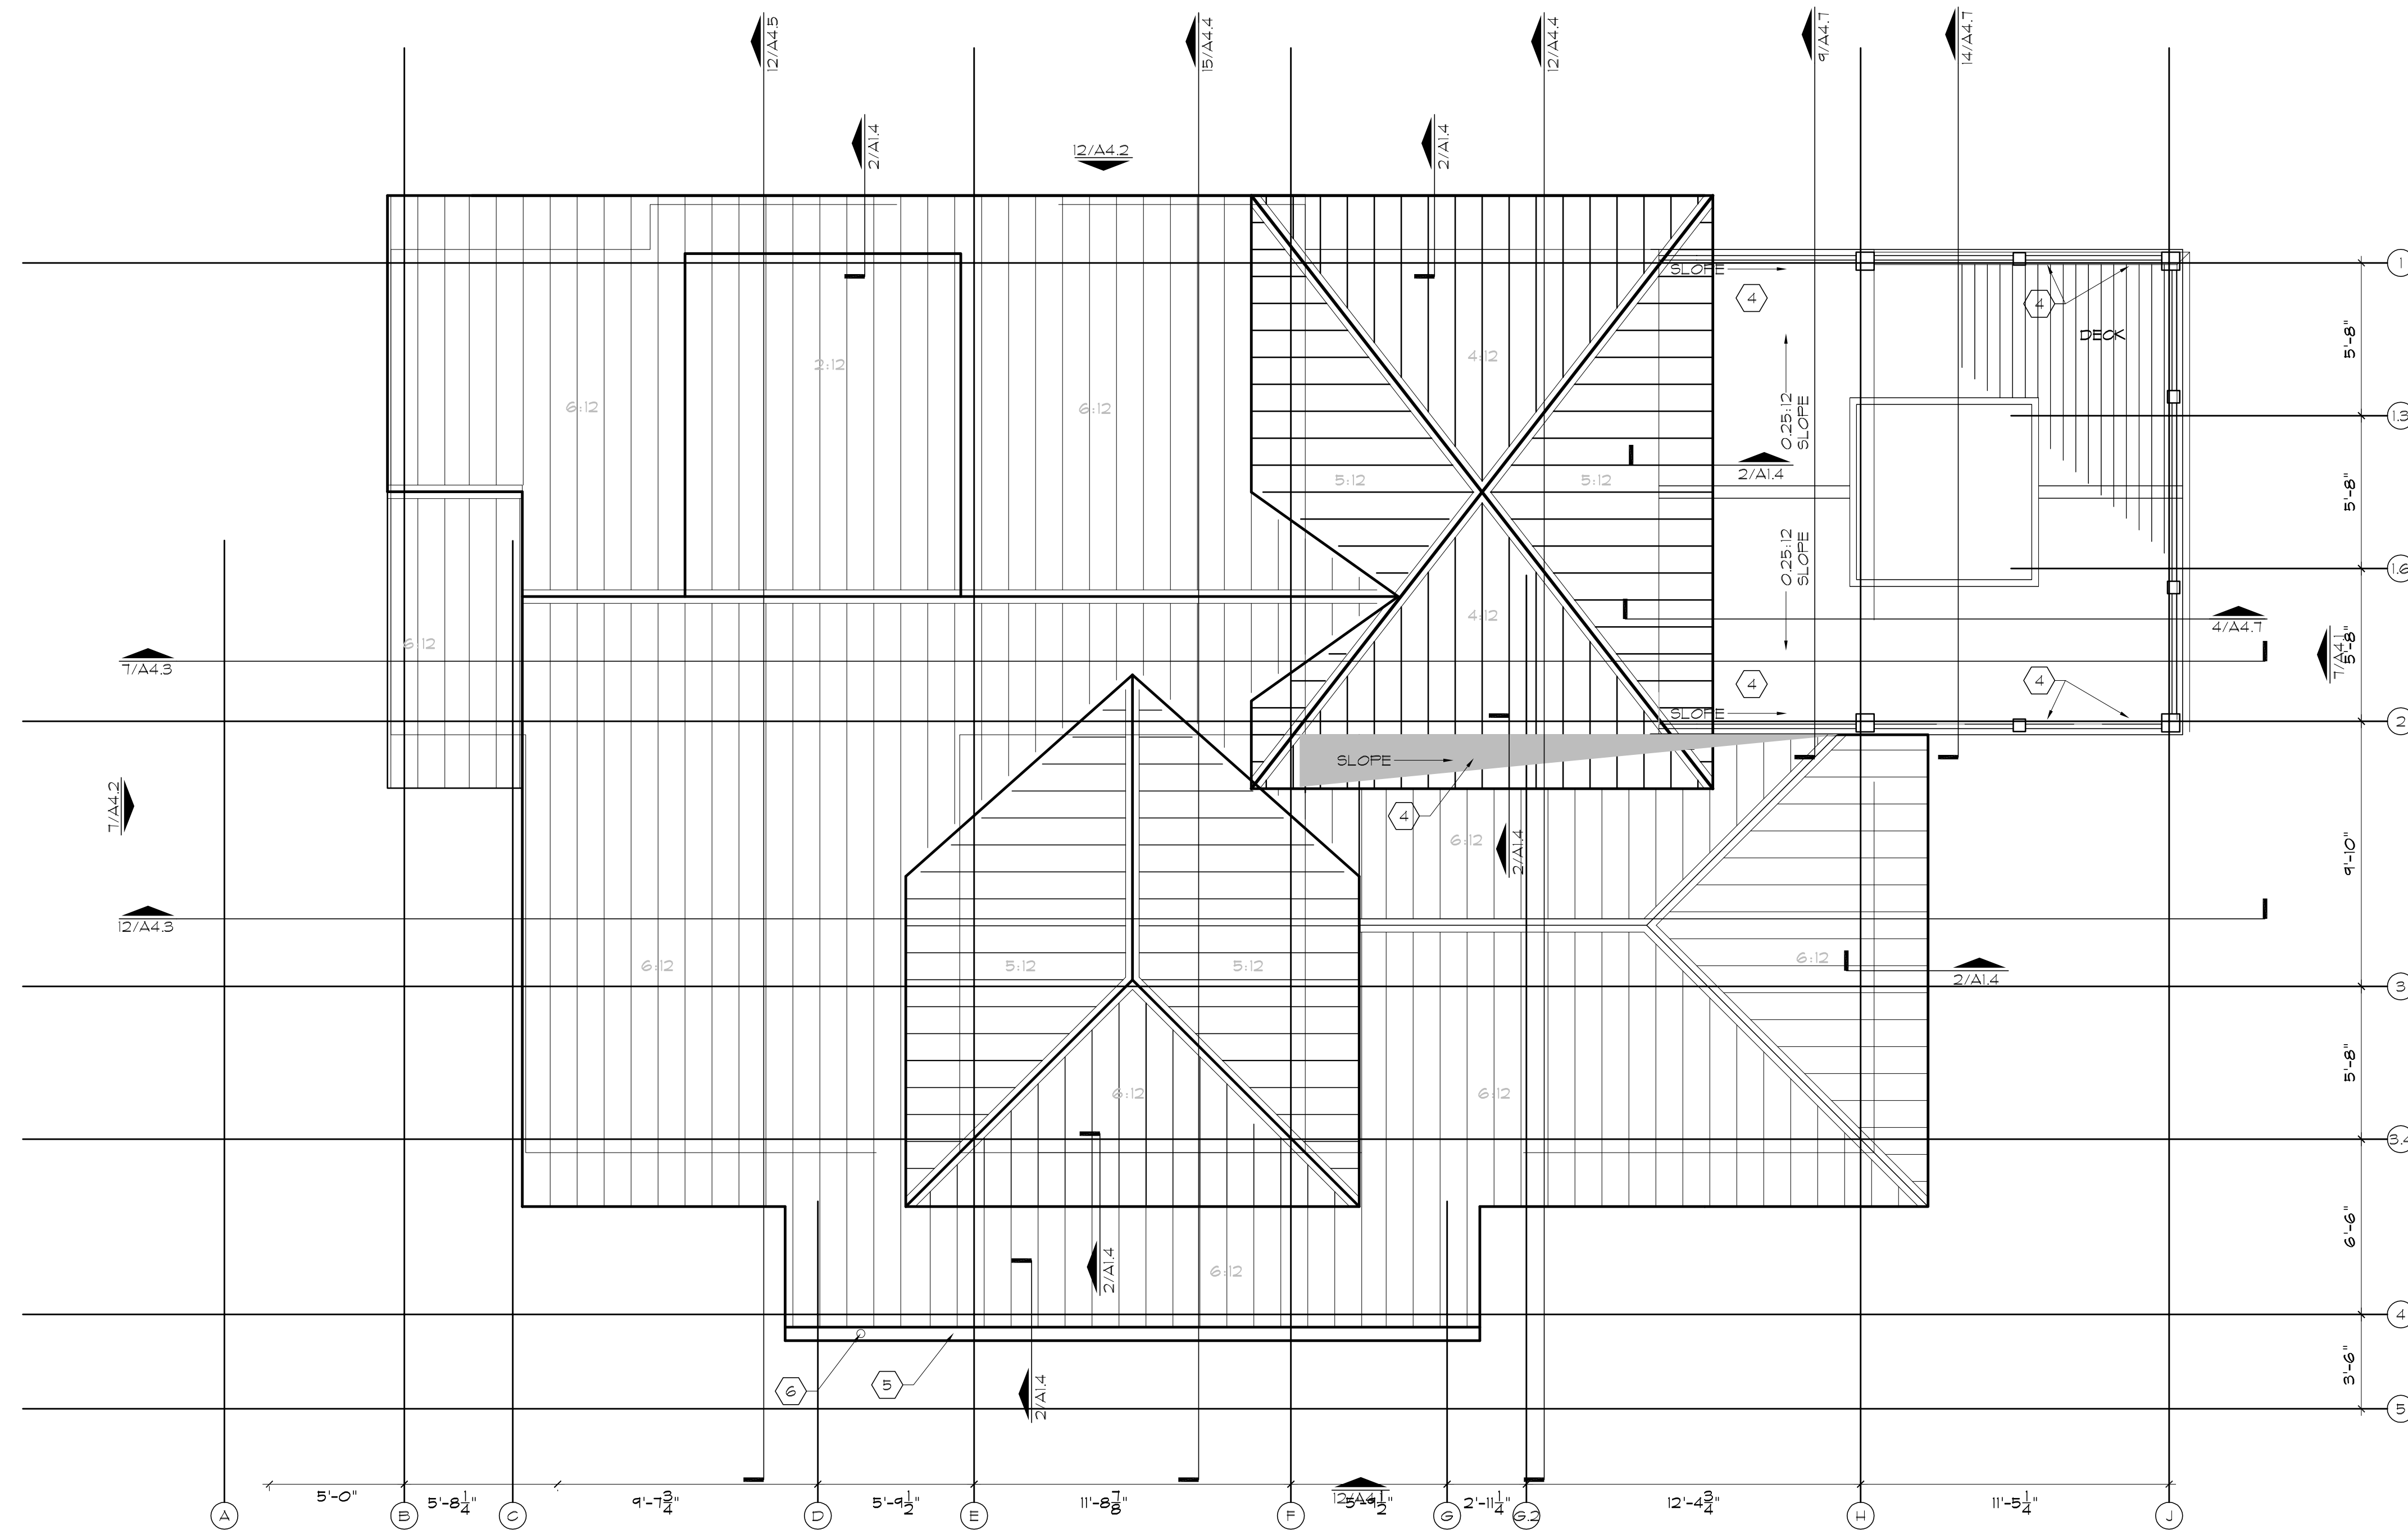


ROOF PLAN

SCALE: 1/4"=1'-0"

ROOF LEGEND

- NEW PARTITION- PARTIAL HEIGHT
- HEADER @ FRAMED OPENING
- ROOM NAME
- ROOM NAME & NUMBER
- NEW DOOR & NUMBER
- EXISTING DOOR
- PLAN NOTE
- WALL TYPE TAG. SEE SCHEDULE FOR DESCRIPTION.
- WINDOW TAG
- EQUIPMENT TAG
- PLUMBING TAG
- ENLARGED PLAN & DETAIL TAG. INDICATES DRAWING #1 ON SHEET A5.1
- ELEVATION TAG. INDICATES ELEVATION #1 ON SHEET A4.1
- SECTION TAG. INDICATES SECTION #1 ON SHEET A4.1

THE GRUENE HOUSE
CINNAMON SHORE
175 SEASIDE DR.
PORT ARANSAS, TX 78373

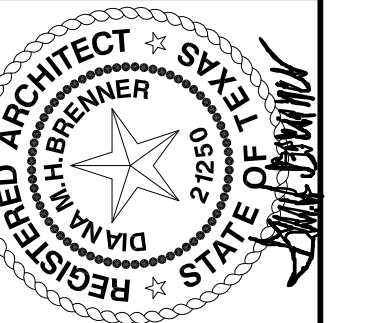

620 N. Delaware
Indianapolis, IN 46204
317.263.1201 tel.
317.263.1200 fax
www.brennerdesign.com

BRENNER DESIGN
Architecture
Construction Management



SHEET NO.

ROOF PLAN

1 JUN 13

CIN3401R

AI.4