


ELECTRICAL PLAN NOTES

- E.C. TO COORDINATE WITH MECHANICAL CONTRACTOR FOR ELECTRICAL REQUIREMENTS FOR HEATING AND COOLING EQUIPMENT.
- E.C. TO COORDINATE WITH PLUMBING CONTRACTOR FOR HOT WATER HEATER ELECTRICAL REQUIREMENTS.
- ALL DEVICE AND COVERPLATE ASSEMBLIES SHALL BE COLOR FILL IN DEVICES SHOWN SIDE-BY-SIDE SHALL BE MOUNTED STRAIGHT, LEVEL, AND AS CLOSE TOGETHER AS POSSIBLE ON THE HORIZONTAL PLANE.
- DEVICES SHOWN "STACKED" SHALL BE MOUNTED STRAIGHT, LEVEL, AND ALIGNED VERTICALLY AT 15" A.F.F. U.N.O.
- VERIFY SWITCHING WITH TENANT, U.N.O.
- ALL LIGHT SWITCHES SHALL BE INSTALLED NO MORE THAN 6" FROM ROUGH OPENING OF DOOR, U.N.O.
- G.C. TO COORDINATE EXACT LOCATION OF ALL ELECTRICAL DEVICES W/ FIELD DIMENSIONED CASEWORK SHOP DRAWINGS. ANY DISCREPANCIES ARE TO BE BROUGHT TO THE ATTENTION OF THE ARCHITECT PRIOR TO INSTALLATION OF ELECTRICAL DEVICES.
- ① VERIFY HEIGHT OF OUTLETS W/ ARCHITECT

SHEET NO.	E.I. 3
TOWER LEVEL ELECTRICAL / DATA LOCATION PLAN	CIN3401R
1 JUN 13	

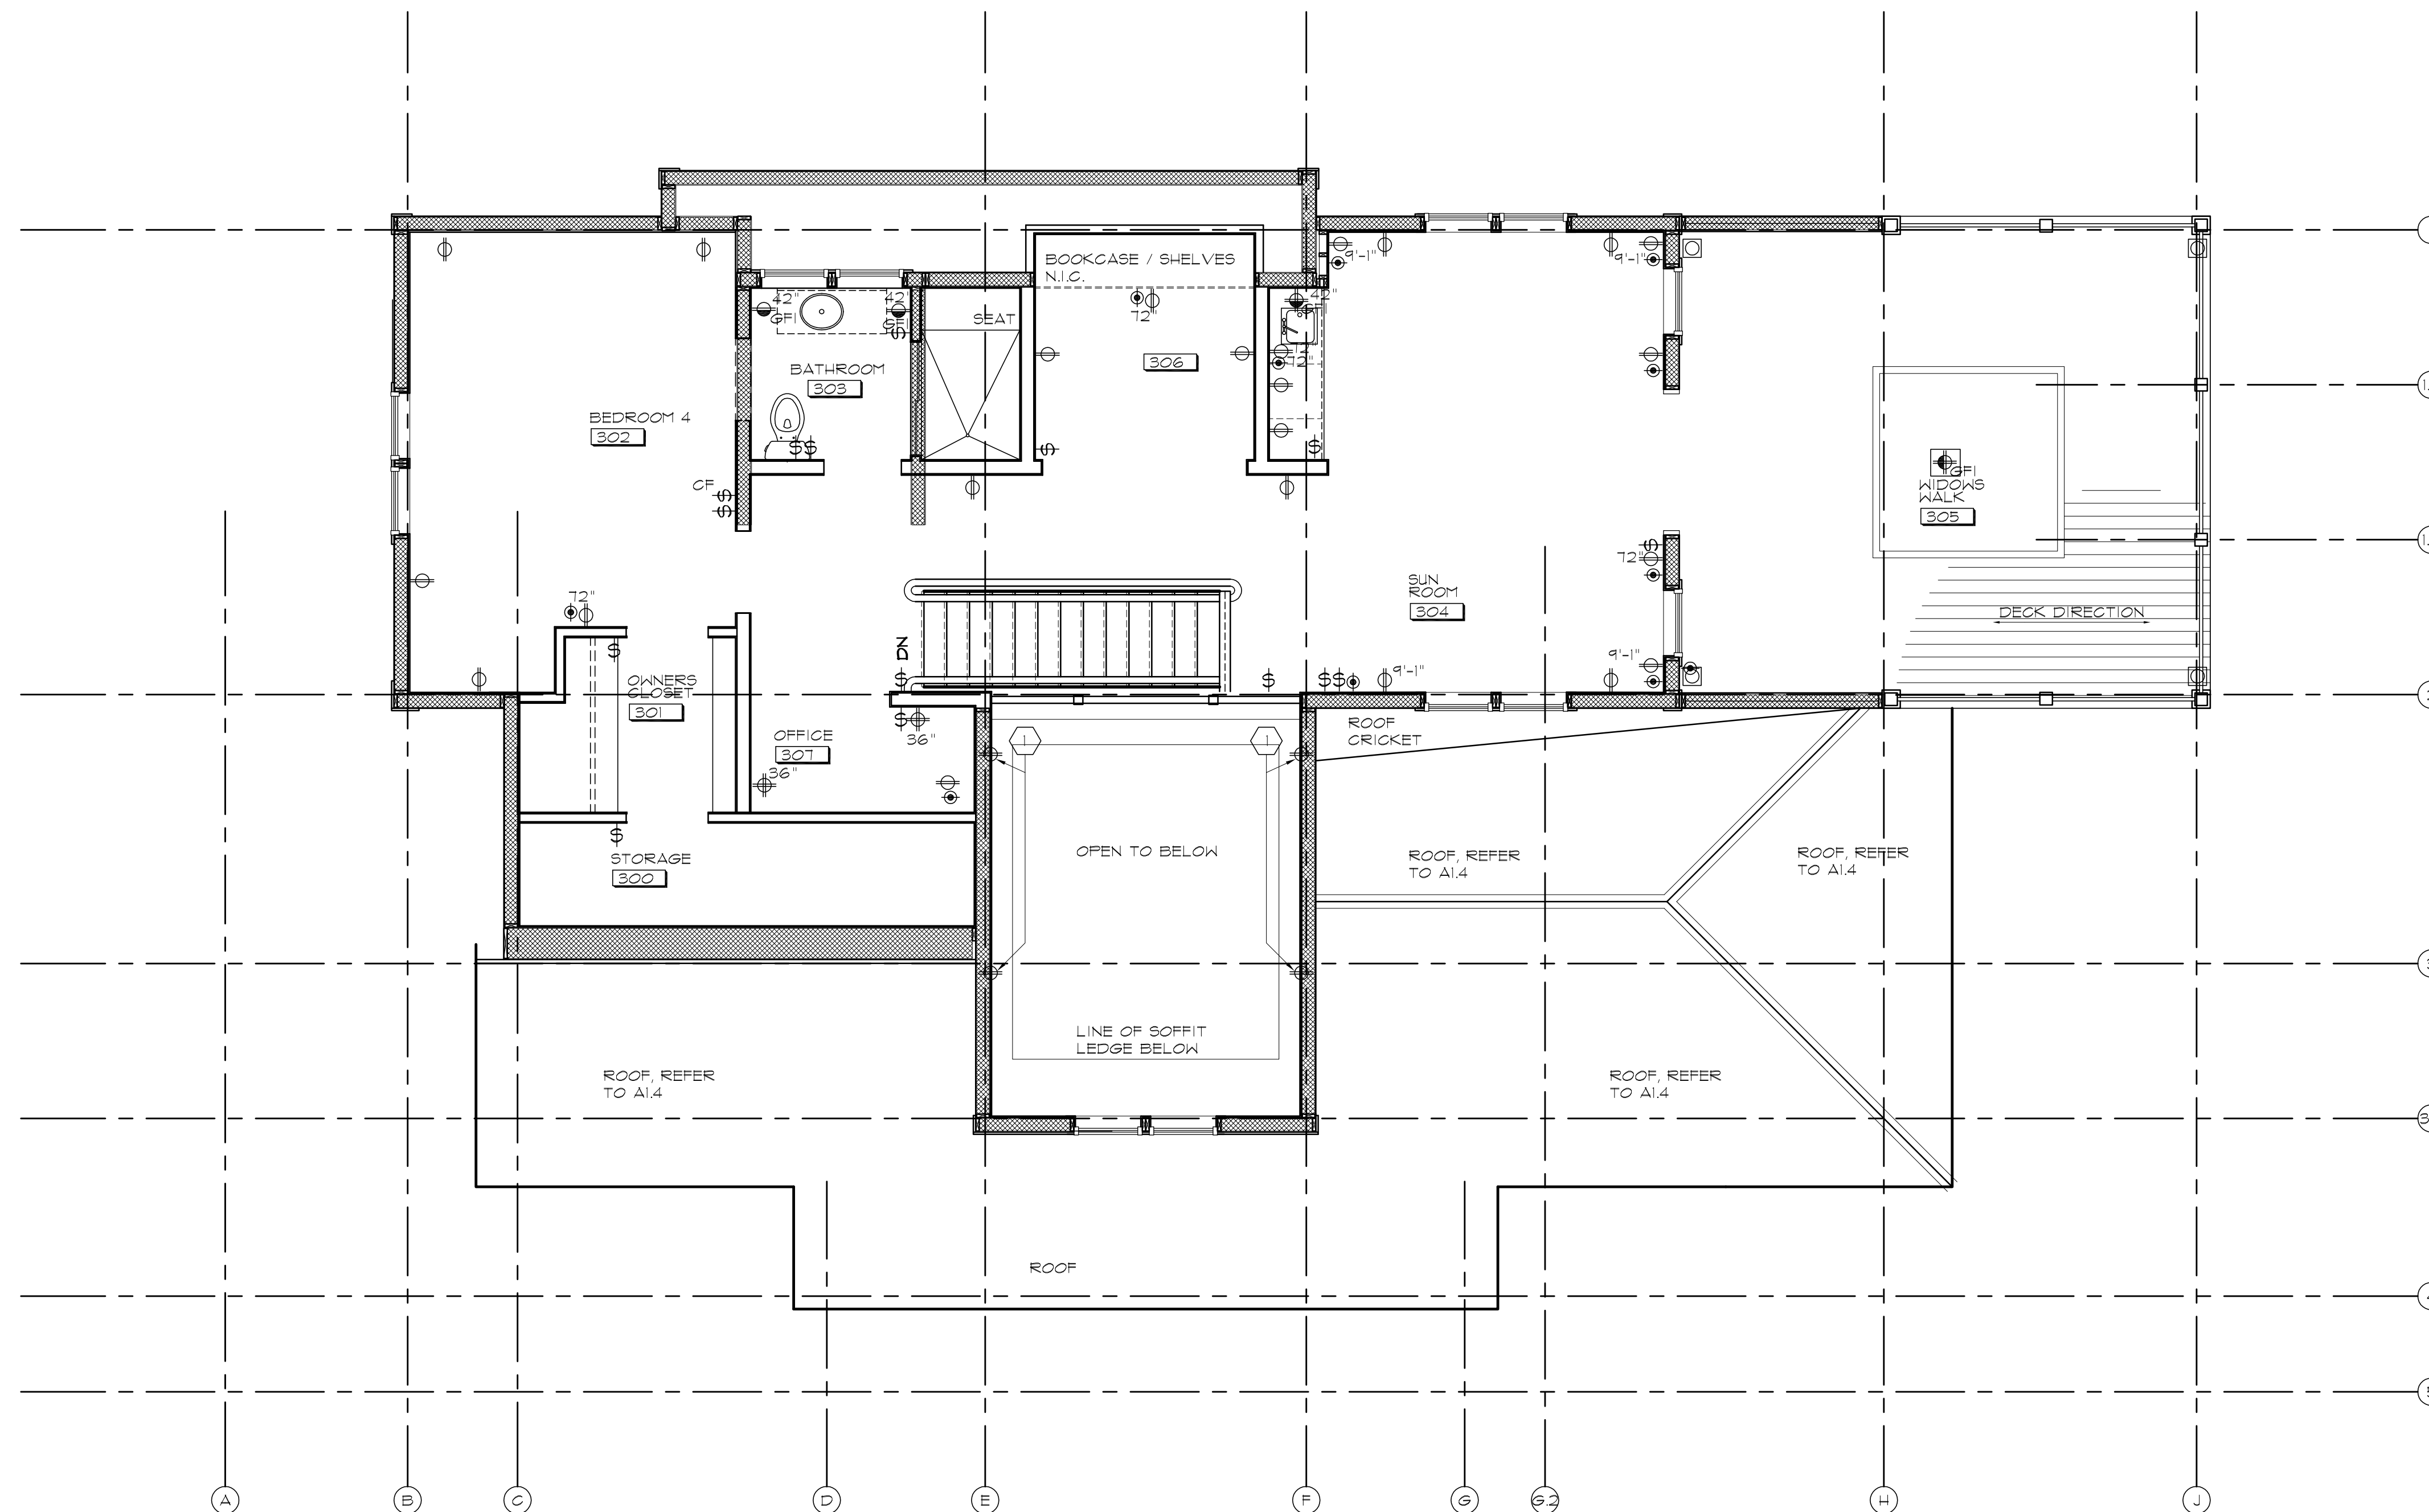


ELECTRICAL LEGEND


- | | |
|-----------|--|
| ROOM NAME | ROOM NAME & NUMBER |
| ⑥ | PLAN NOTE |
| ⊕ | SINGLE ELECTRICAL OUTLET, 220/230 VOLTS. |
| ⊕ | DUPLEX ELECTRICAL OUTLET, 110/120 VOLTS. |
| ⊕ | DUPLEX ELECTRICAL OUTLET, GFI |
| ⊕ | DUPLEX ELECTRICAL OUTLET, DEDICATED CIRCUIT. |
| ⊕ | DUPLEX ELECTRICAL OUTLET, ISOLATED GROUND CIRCUIT. |
| ⊕ | QUAD ELECTRICAL OUTLET |
| ⊕ | QUAD ELECTRICAL OUTLET, DEDICATED |
| ⊕ | QUAD ELECTRICAL OUTLET ISOLATED GROUND |
| ⊕ | QUAD ELECTRICAL OUTLET, GFI |
| ⊕ | FLOOR MOUNTED OUTLET |
| ⊕ | MULTIPLE OUTLET/PLUG MOLD |
| ⊕ | GROUND FAULT INTERRUPTER AS REQUIRED |
| ⊕ | INDICATED MOUNTING HEIGHT ABOVE FINISHED FLOOR |
| ⊕ | OUTDOOR WALL MOUNTED DUPLEX ELECTRICAL OUTLET, GFI |
| ⊕ | ONE WAY SWITCH |
| ⊕ | THREE WAY SWITCH |
| ⊕ | FOUR WAY SWITCH |
| ⊕ | INDICATES SWITCH W/ DIMMER |
| ⊕ | FIXTURES GANGED BY AREA |
| ⊕ | INDICATES FIXTURE TO BE SWITCHED |
| ⊕ | CABLE OR SAT. TV |
| ⊕ | THERMOSTAT. VERIFY EXACT LOCATION & HEIGHT WITH ARCHITECT PRIOR TO INSTALLATION. |
| ⊕ | ELECTRICAL METER |
| ⊕ | PROVIDE JUNCTION BOX |
| ⊕ | SURFACE MOUNTED ELECTRICAL PANEL & CABINET |
| ⊕ | HOT WATER HEATER |
| ⊕ | BELL |
| ⊕ | BUZZER |
| ⊕ | SPEAKER @ 1'-0" AFF. |

TOWER LEVEL ELECTRICAL PLAN

SCALE: 1/4"=1'-0"

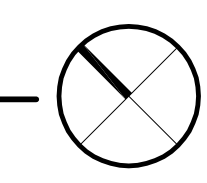

THE GRUENE HOUSE
 CINNAMON SHORE
 175 SEASIDE DR.
 PORT ARANSAS, TX 78373

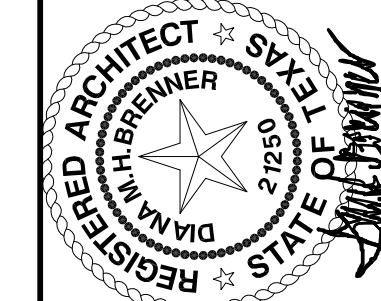

BRENNER DESIGN
 Architects
 Construction Management
 620 N. Delaware
 Indianapolis, IN 46204
 317.262.1200 tel
 317.262.1200 fax
 www.brennerdesign.com