


- LINEAR SIDE DISCHARGE SUPPLY AIR DIFFUSER
- SQUARE SUPPLY AIR DIFFUSER
- ROUND SUPPLY AIR DIFFUSER
- TYPE A: SURFACE MOUNTED COMPACT FLUORESCENT FIXTURE - DAMP PROOF LENS
- TYPE B: EXTERIOR RECESSED DOWNLIGHT
- TYPE C: RECESSED COMPACT FLUORESCENT FIXTURE
- TYPE D: RECESSED WALL WASHER
- TYPE E: SMALL PENDANT LIGHT FIXTURE:
- TYPE F: LARGE PENDANT LIGHT FIXTURE:
- TYPE G: WALL SCONCE:
- TYPE H: 2X4 FLUORESCENT FIXTURE W/ ACRYLIC DIFFUSER
- TYPE H1: 1X4 FLUORESCENT FIXTURE W/ ACRYLIC DIFFUSER
- TYPE J: LARGE CHANDELIER
- TYPE X: EXIT SIGN

LEGEND

19

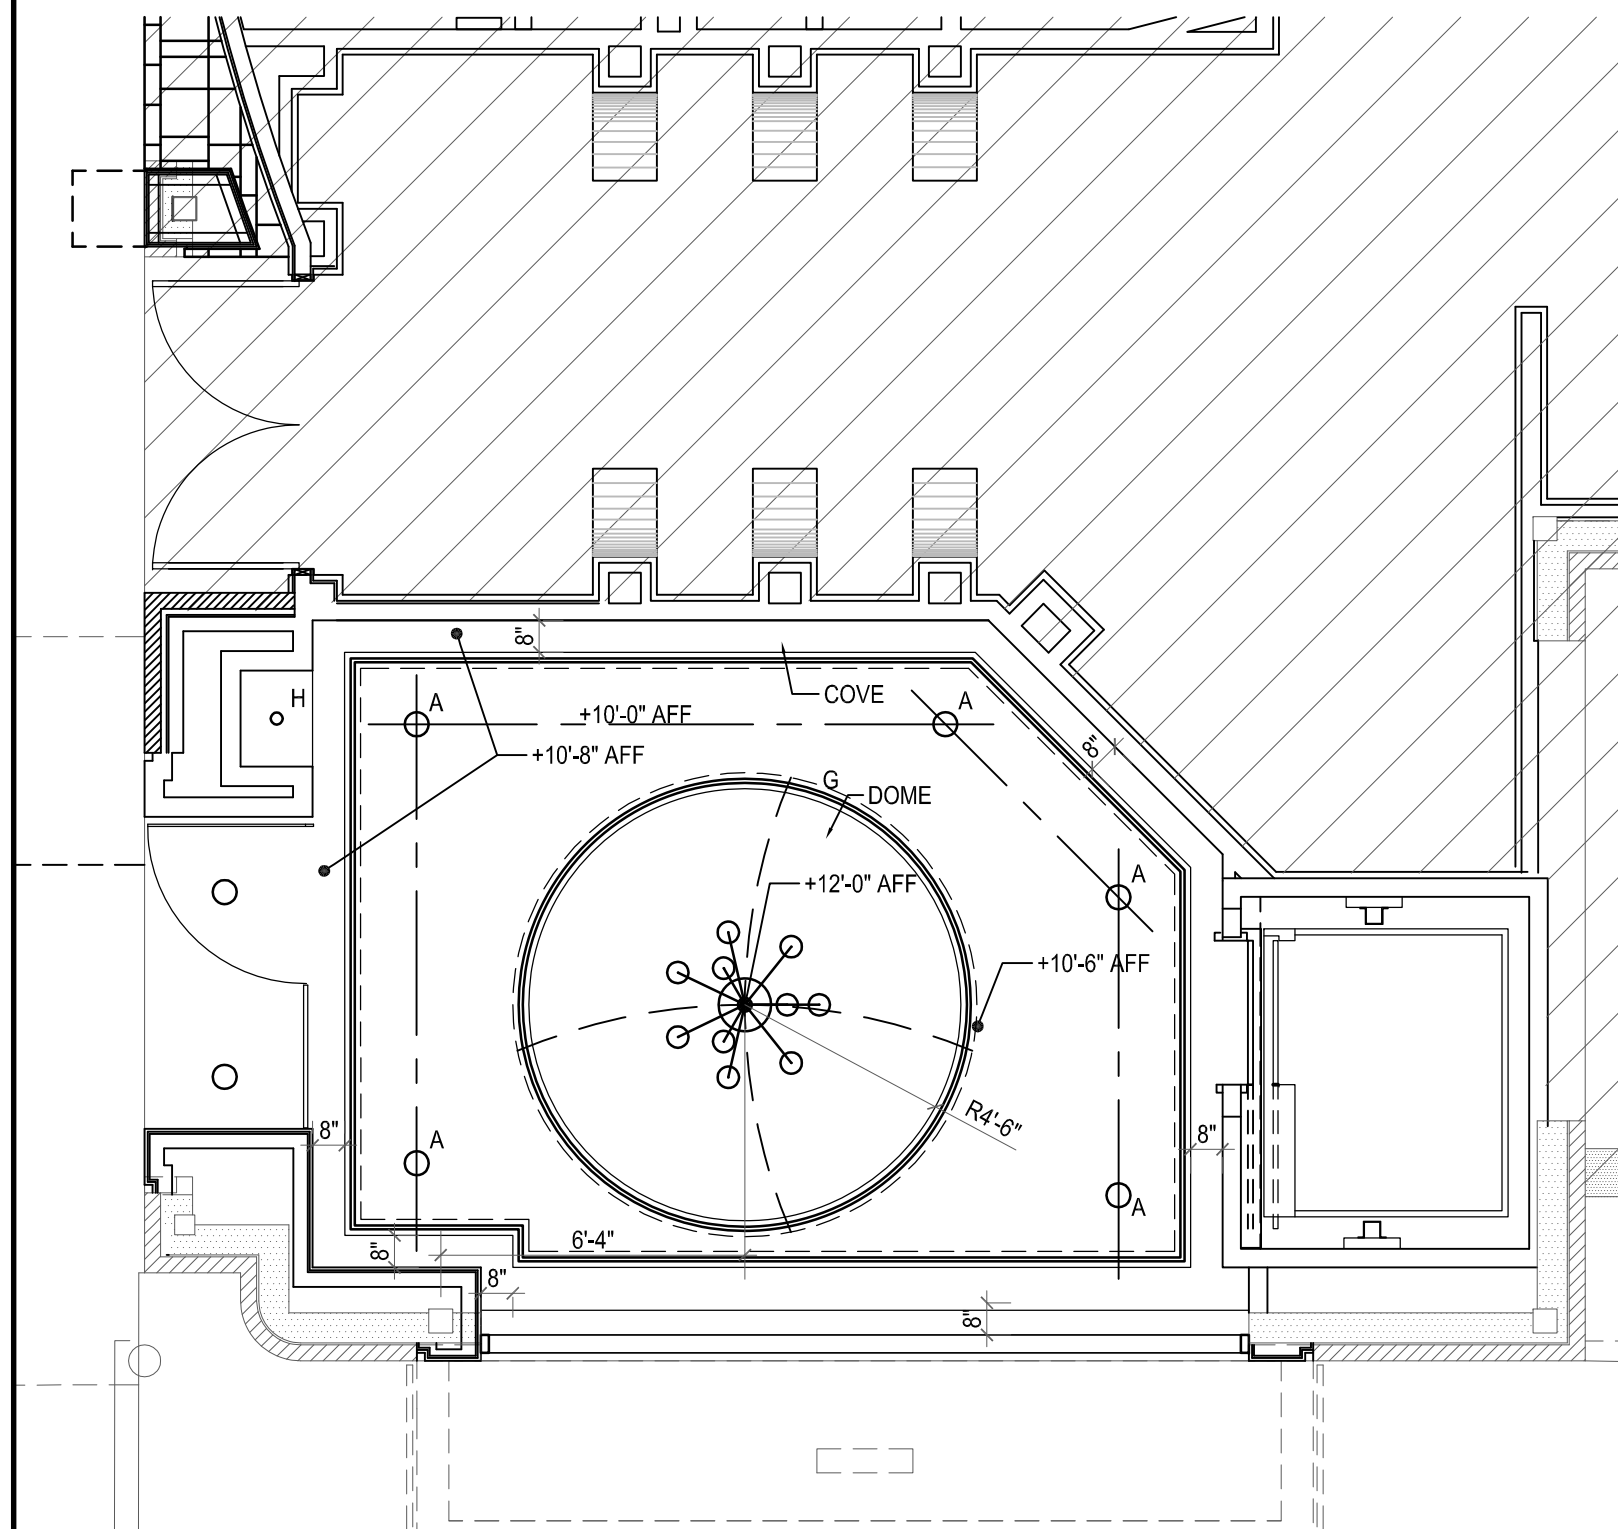


REFLECTED CEILING PLAN - UPPER LEVEL

1/4" = 1'-0"

17

REFLECTED CEILING PLAN - LOWER LEVEL

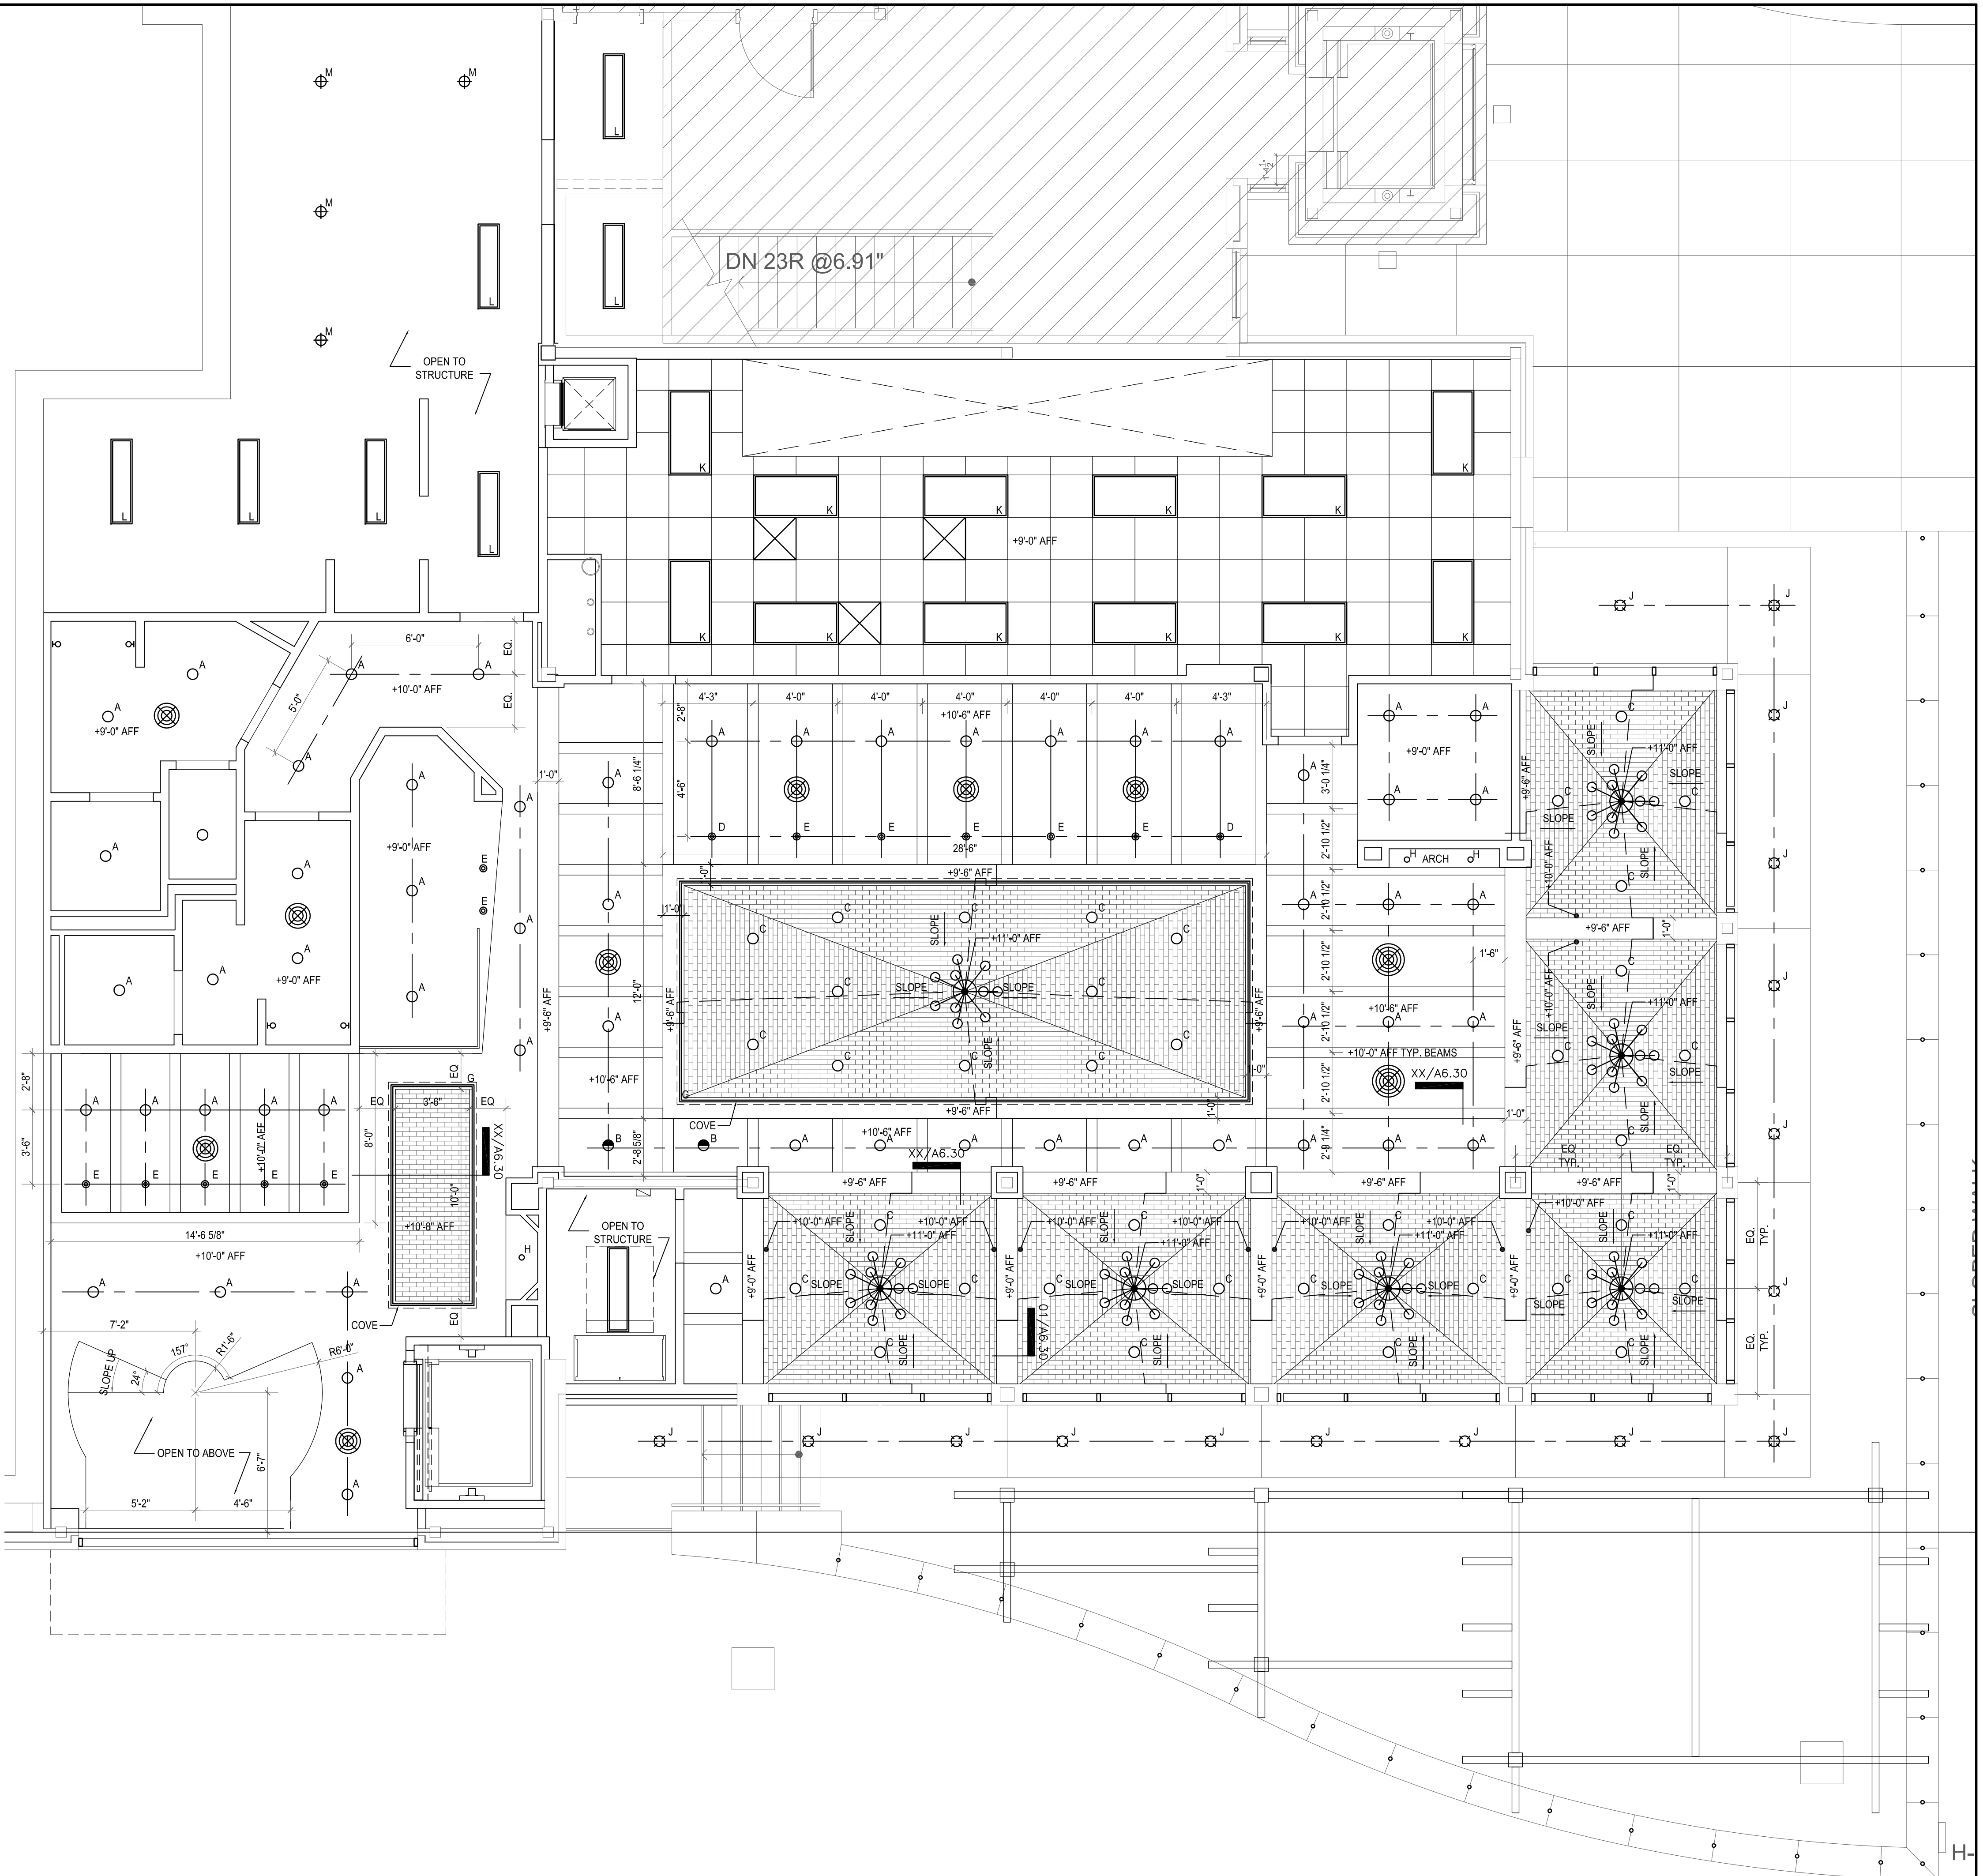

1/4" = 1'-0"

1



ISSUE
10-29-2010 Permit

HARRELL
ARCHITECTS, LP

9575 Katy Frwy., #200
Houston, Texas 77024
tel: 713.722.7071
fax: 713.722.7072

CONSULTANTS
Holste & Associates, Inc.
MEP Engineers

PROJECT NAME
**GUADALUPANA
RESTAURANT**



PROJECT ADDRESS
20 WATERWAY
THE WOODLANDS, TEXAS

PROJECT NUMBER
10019

SHEET NAME

**REFLECTED
CEILING PLAN**

SHEET NUMBER

A3.00