

ISSUE
11-30-10 ISSUED FOR PERMIT

HARRELL
ARCHITECTS, LP

9275 Kuhl Fwy. #200
Houston, Texas 77024
Tel: 713.722.7071
Fax: 713.722.7072

CONSULTANTS
HQS SITE & ASSOCIATES
MEP Engineers


PROJECT NAME
GUADALUPANA
RESTAURANT



PROJECT ADDRESS
29 WATERWAY
THE WOODLANDS, TEXAS

PROJECT NUMBER
SHEET NAME
**MECHANICAL
ROOF PLAN**
SHEET NUMBER

M1.01

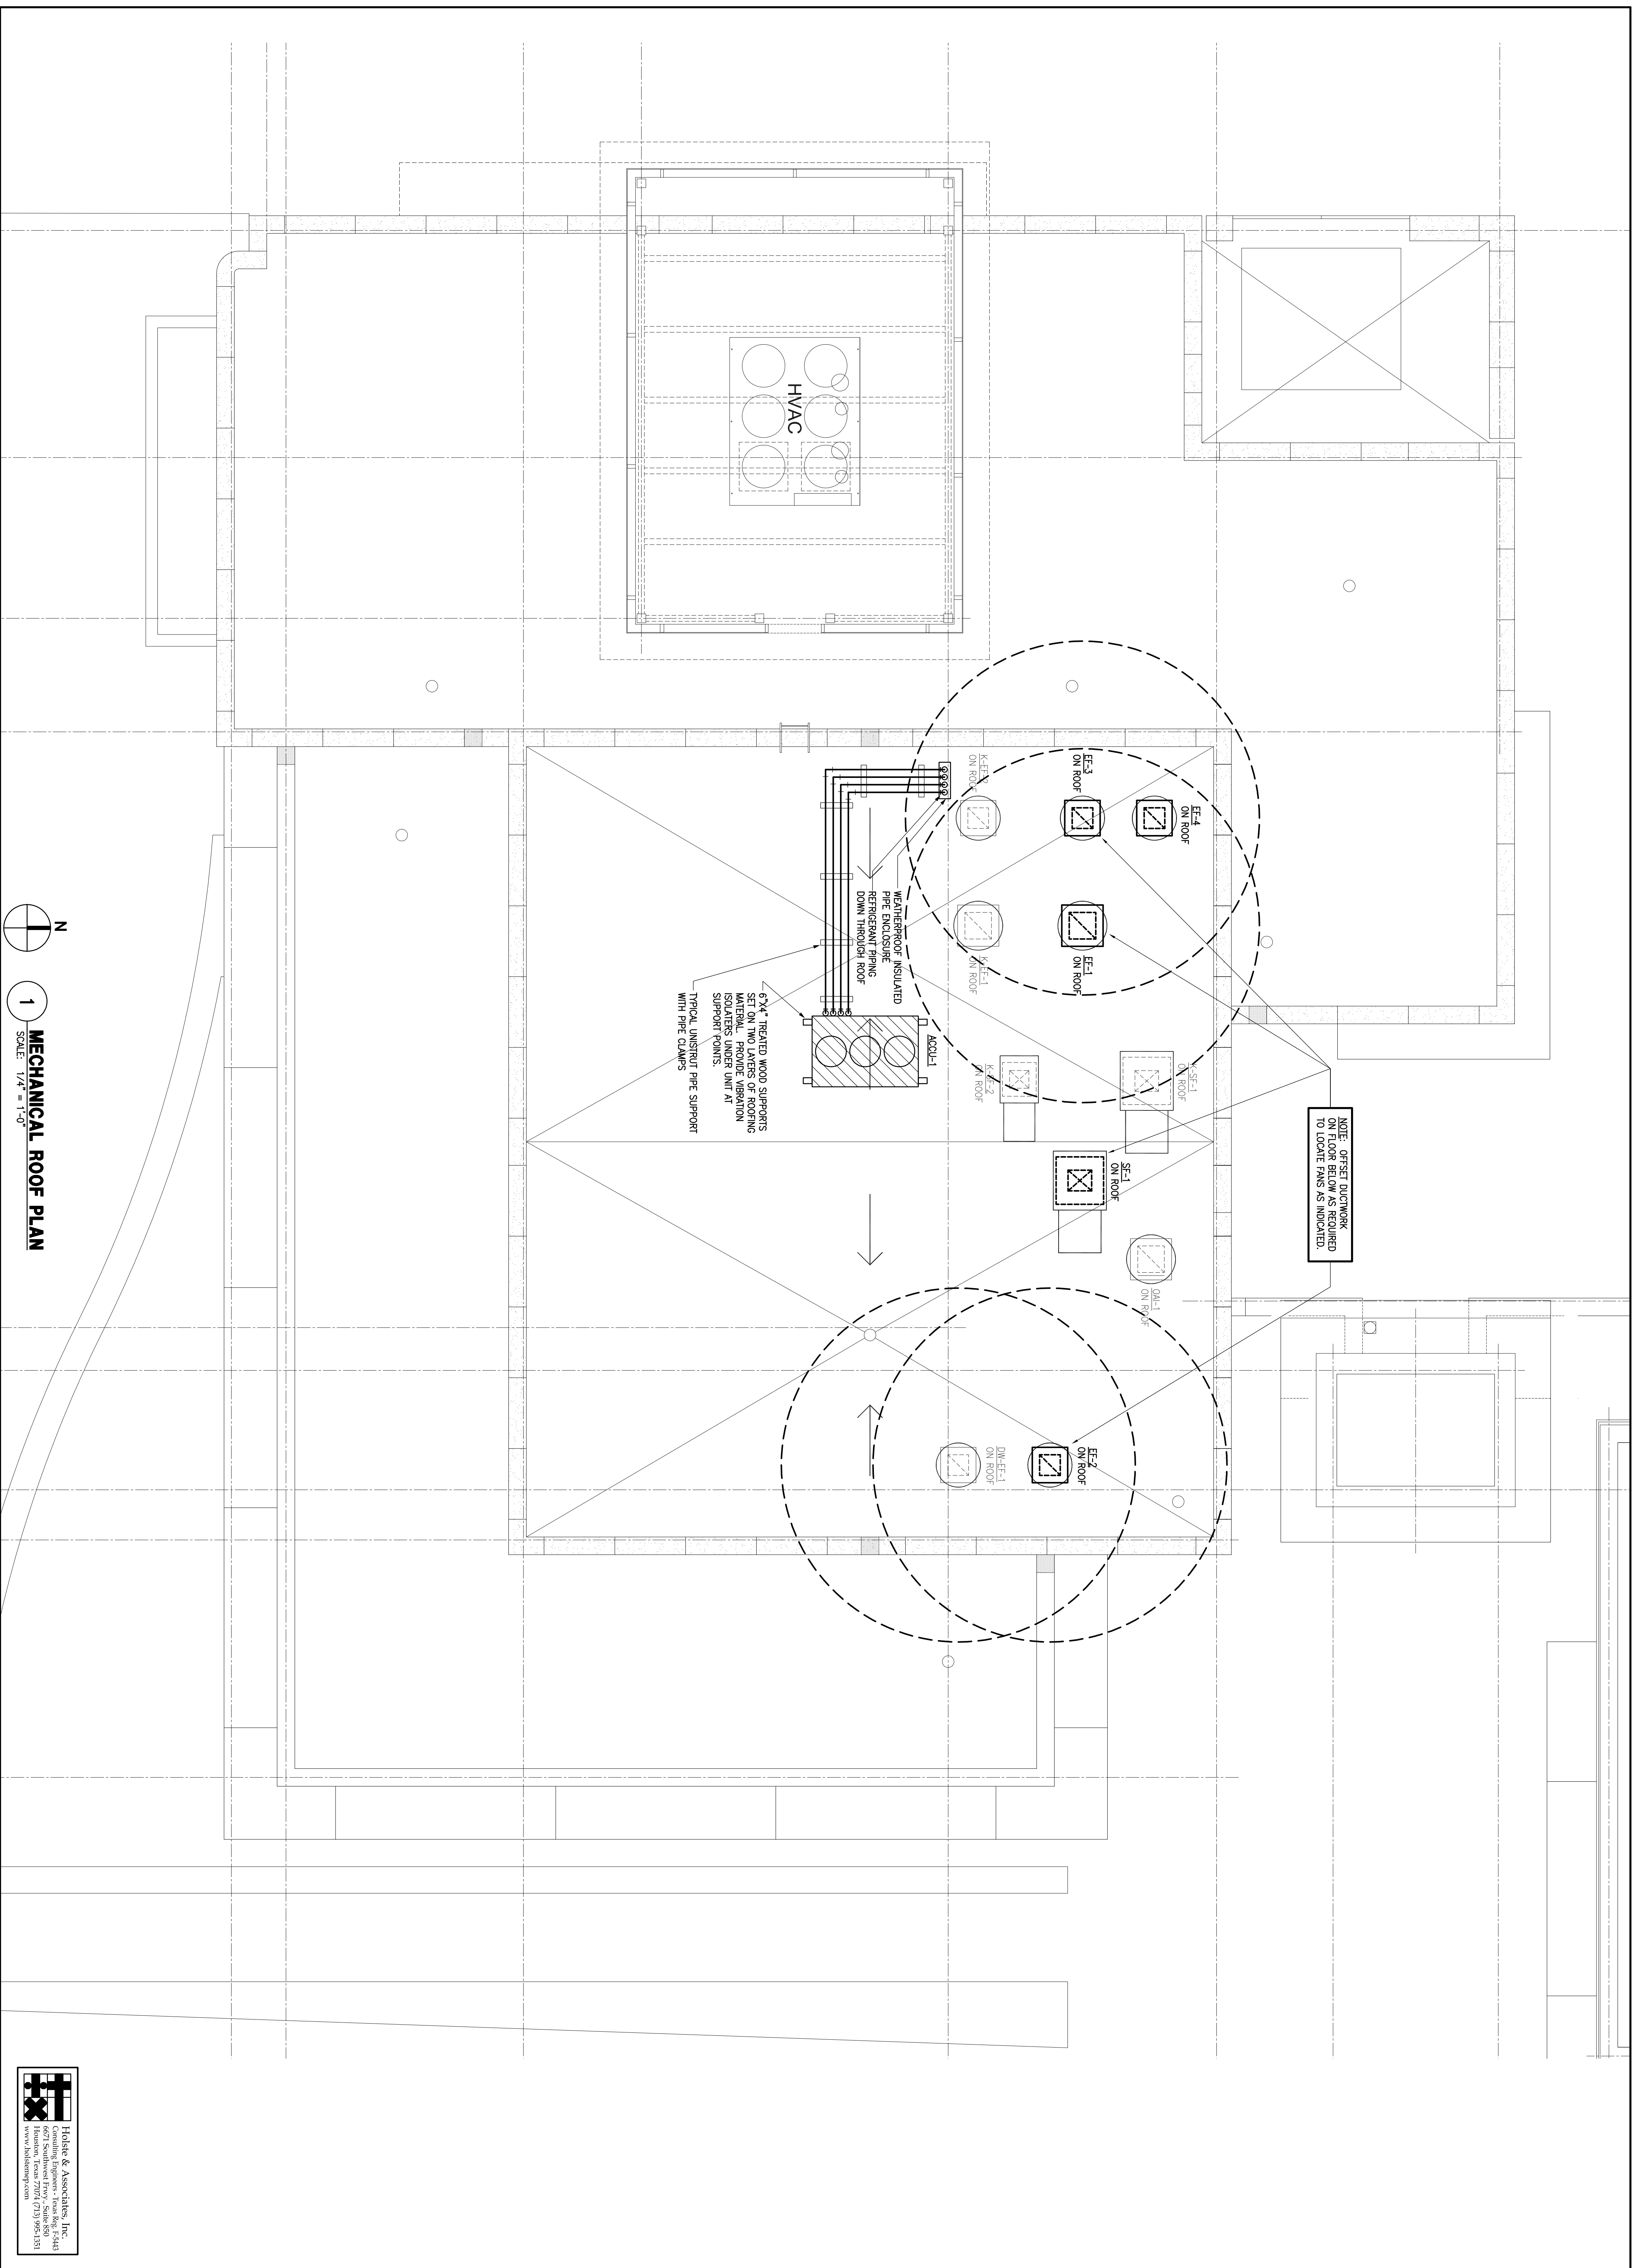

N
1
MECHANICAL ROOF PLAN
SCALE: 1/4" = 1'-0"



Hobbs & Associates, Inc.
Consulting Engineers - Texas Reg. 15843
Houston, Texas 77071 (713) 962-1371
www.hobbsinc.com