


ISSUE
 09-09-2010 Permit 1
 10-22-2010 Construction 2

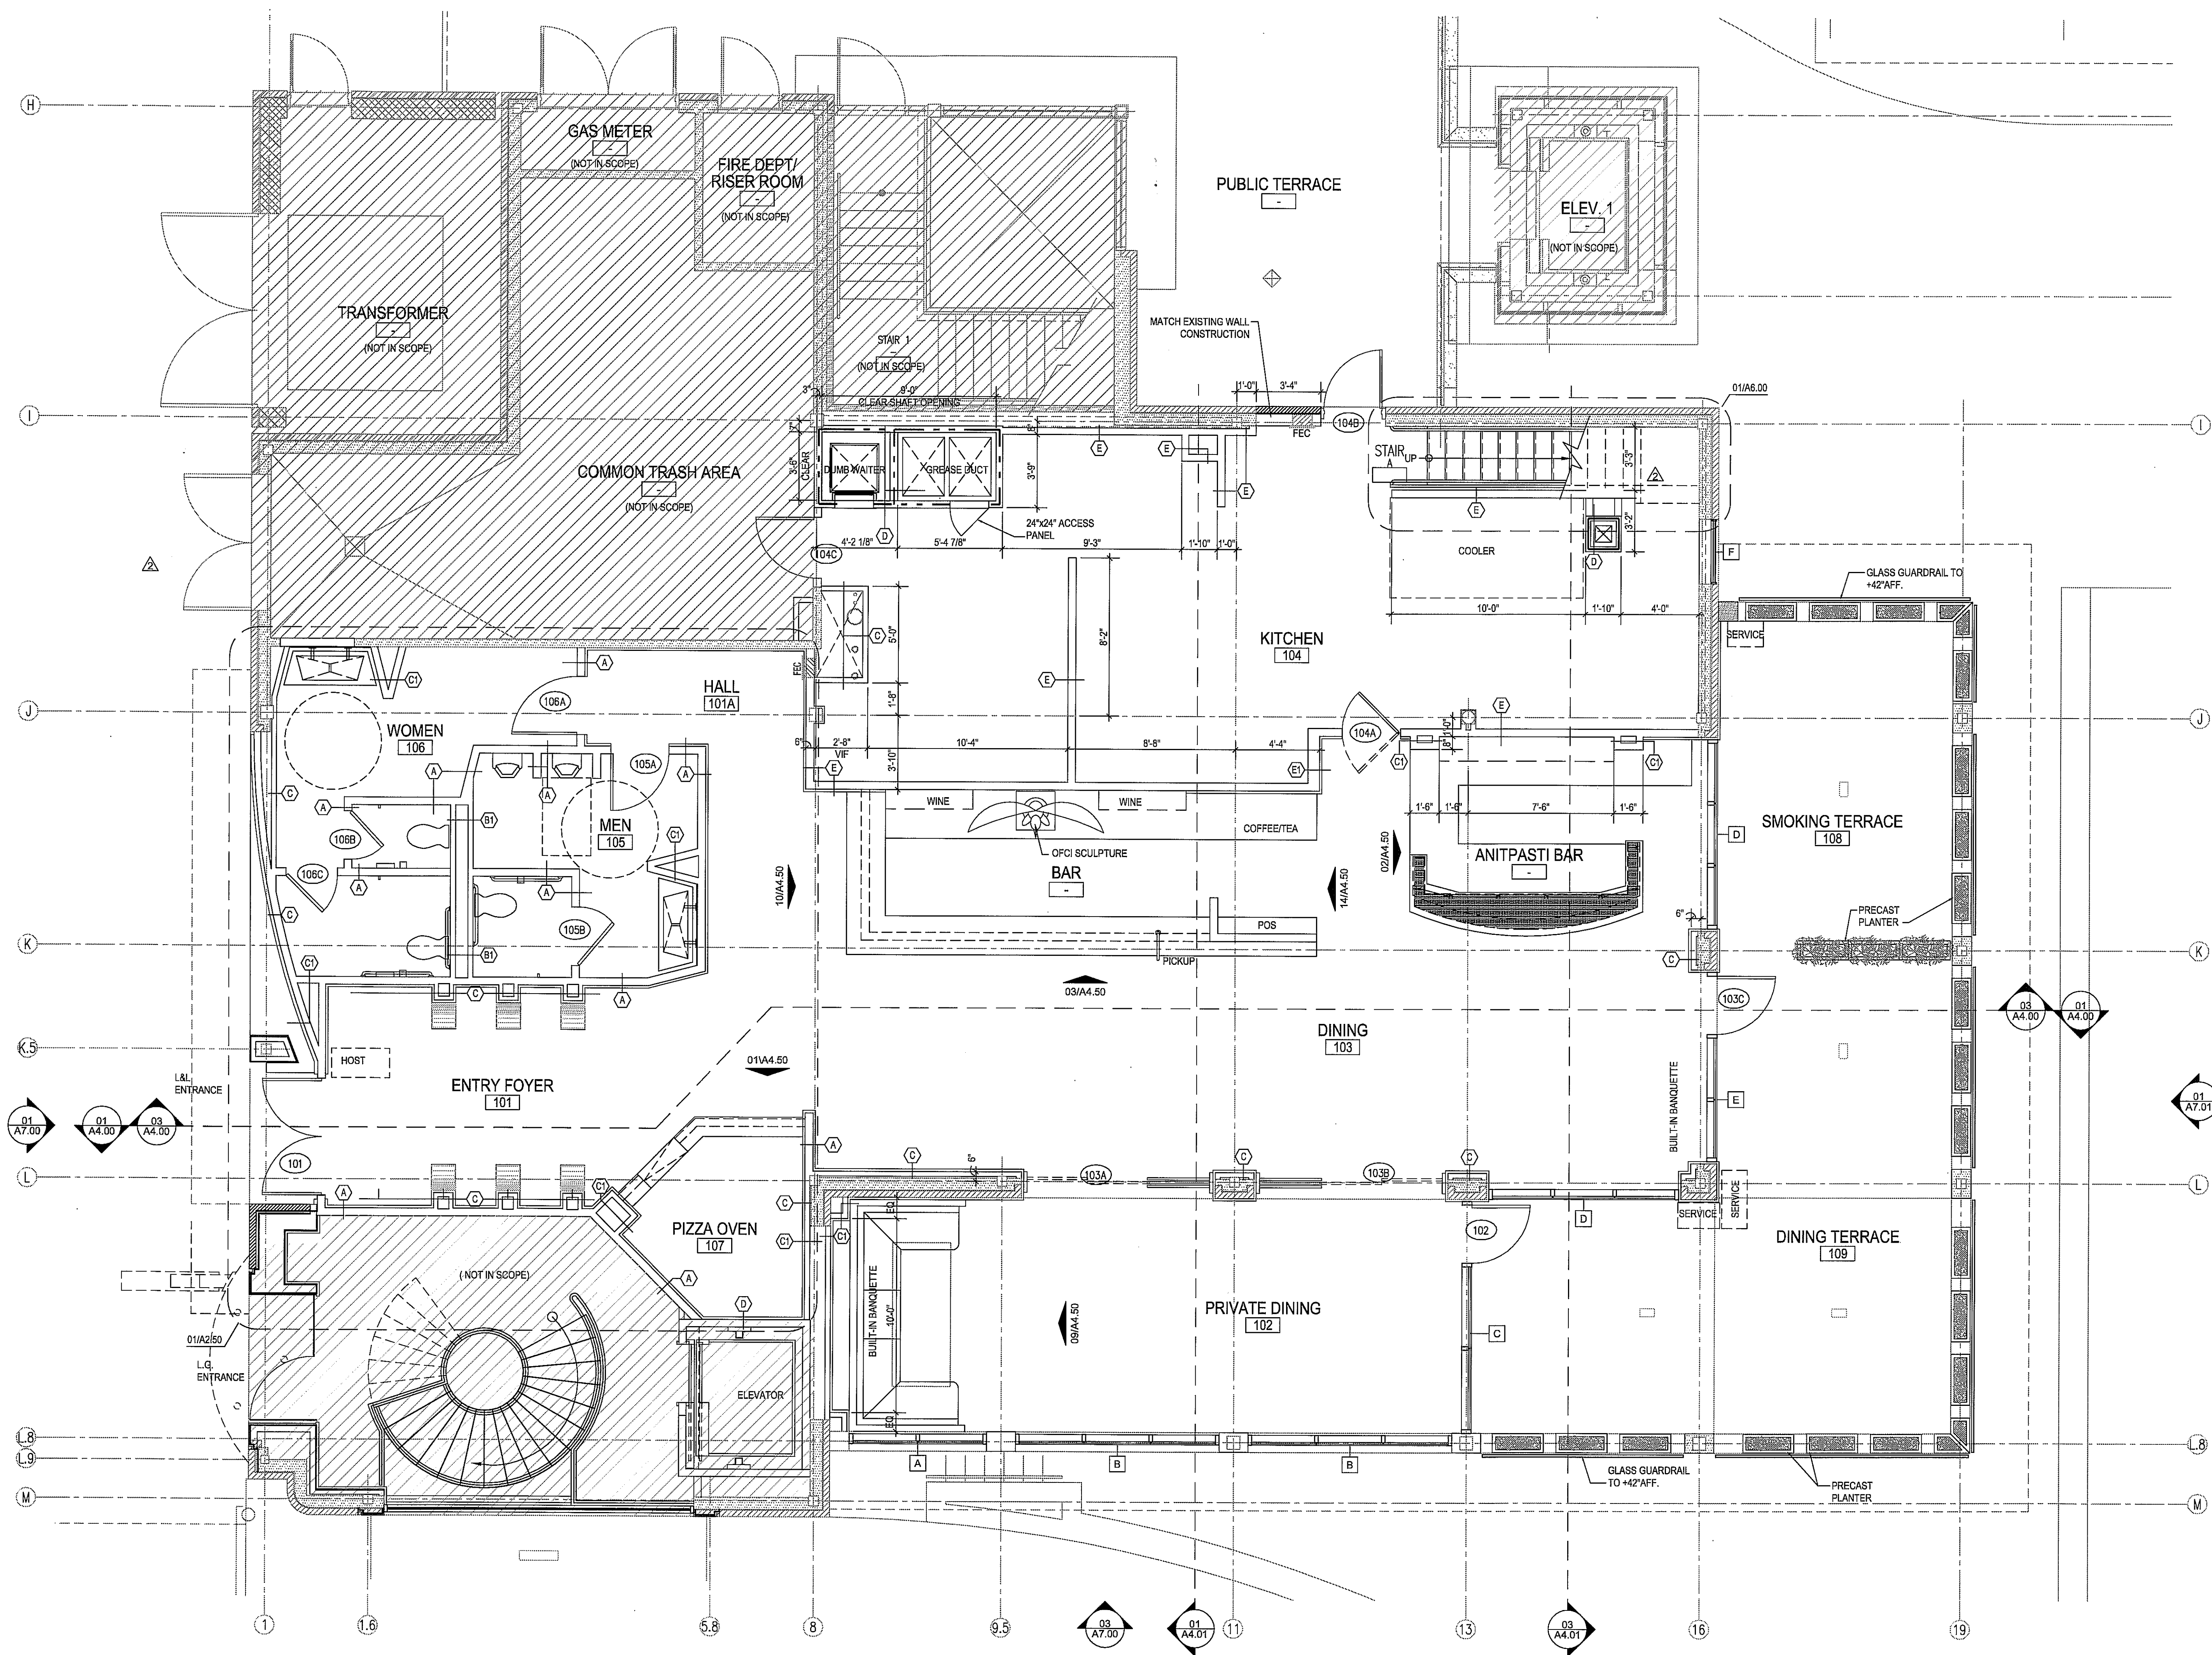

HARRELL
 ARCHITECTS, LP

9575 Katy Frwy., #200
 Houston, Texas 77024
 tel: 713.722.7071
 fax: 713.722.7072

CONSULTANTS
 Holste & Associates, Inc
 MEP Engineers
 TDG
 Food Service
 Paul Engineering
 Structural Engineers

PROJECT NAME

LUCA &
 LEONARDO
 RESTAURANT

**LUCA &
 LEONARDO**
 RESTAURANTE

PROJECT ADDRESS
 20 WATERWAY
 THE WOODLANDS, TEXAS

PROJECT NUMBER
 10018
 SHEET NAME

FLOOR PLAN

SHEET NUMBER

A2.00