

ISSUE
09-09-2010 Permit
10-22-2010 Construction

- TYPE A & H : RECESSED COMPACT FLUORESCENT FIXTURE
- ✿ TYPE B: LARGE CHANDELIER
- ⊙ TYPE C & D: PENDANT FIXTURE
- ▽▽▽— TYPE E: CABLE RAIL SYSTEM
- ☁ TYPE E1: WALL MONORAIL SYSTEM
- ◀ TYPE F: WALL SCONCE
- TYPE G: COVE LIGHT FIXTURE
- TYPE J: RECESSED WALL WASHER
- ✪ TYPE K: EXTERIOR CEILING FAN
- ▭ TYPE L: 2X4 FLUORESCENT FIXTURE W/ ACRYLIC DIFFUSER
- ▬ TYPE M: 24" WALL MOUNTED FLUORESCENT STRIP FIXTURE
- ⊕ TYPE N: SURFACE MOUNTED COMPACT FLUORESCENT FIXTURE - DAMP PROOF LENS
- ⊞ TYPE P: EXTERIOR RECESSED DOWNLIGHT
- EXIT TYPE X: EXIT SIGN
- ▬ LINEAR SIDE DISCHARGE SUPPLY AIR DIFFUSER
- ⊞ SUPPLY AIR DIFFUSER
- ⊞ RETURN AIR GRILLE

LEGEND

- A. ALL CEILING TO BE +9'-0" AFF. UNLESS NOTED OTHERWISE.
- B.

HARRELL ARCHITECTS, LP

9575 Katy Frwy., #200
Houston, Texas 77024
tel: 713.722.7071
fax: 713.722.7072

CONSULTANTS
Holste & Associates, Inc
MEP Engineers
TDG
Food Service
Paul Engineering
Structural Engineers

PROJECT NAME

LUCA & LEONARDO RESTAURANT




PROJECT ADDRESS
20 WATERWAY
THE WOODLANDS, TEXAS

PROJECT NUMBER
10018
SHEET NAME

REFLECTED CEILING PLAN
SHEET NUMBER

A3.00

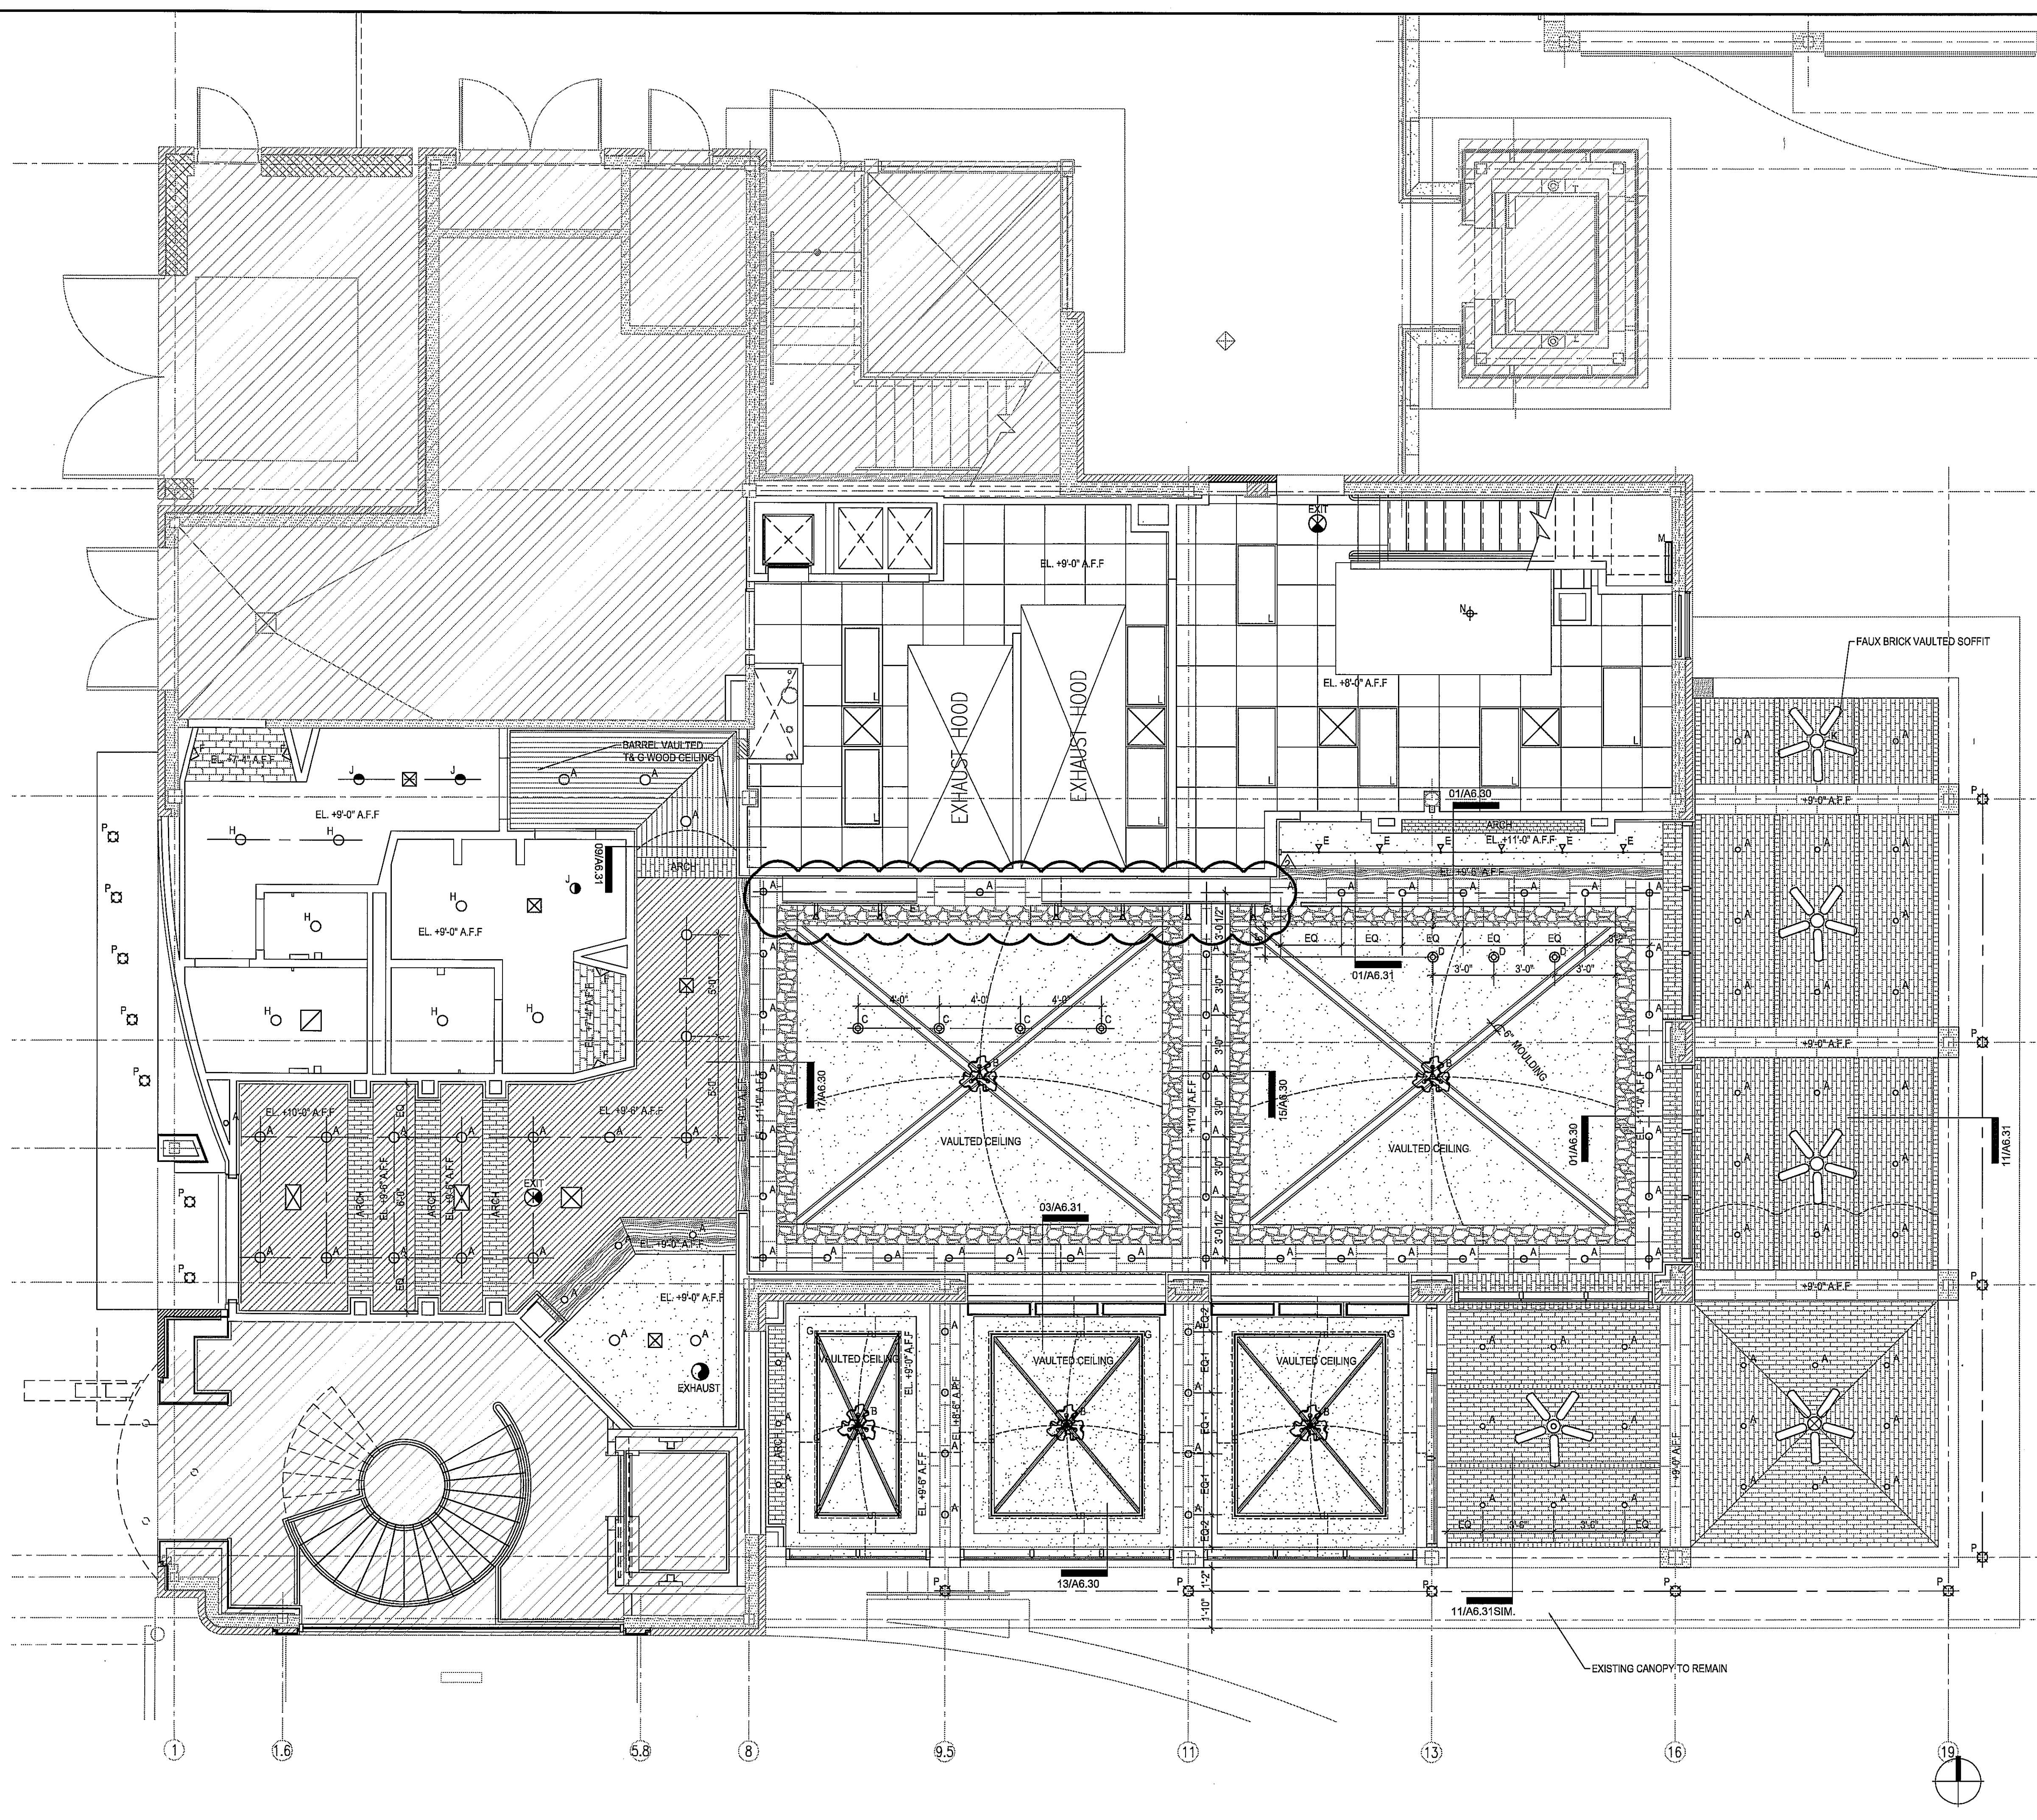

REFLECTED CEILING PLAN

1/4" = 1'-0"

5

GENERAL NOTES

N.T.S.

1