




ISSUE
 09-10-10 ISSUED FOR PERMIT
 10-08-10 DBR REVIEW COMMENTS
 11-02-10 ISSUED FOR CONSTRUCTION

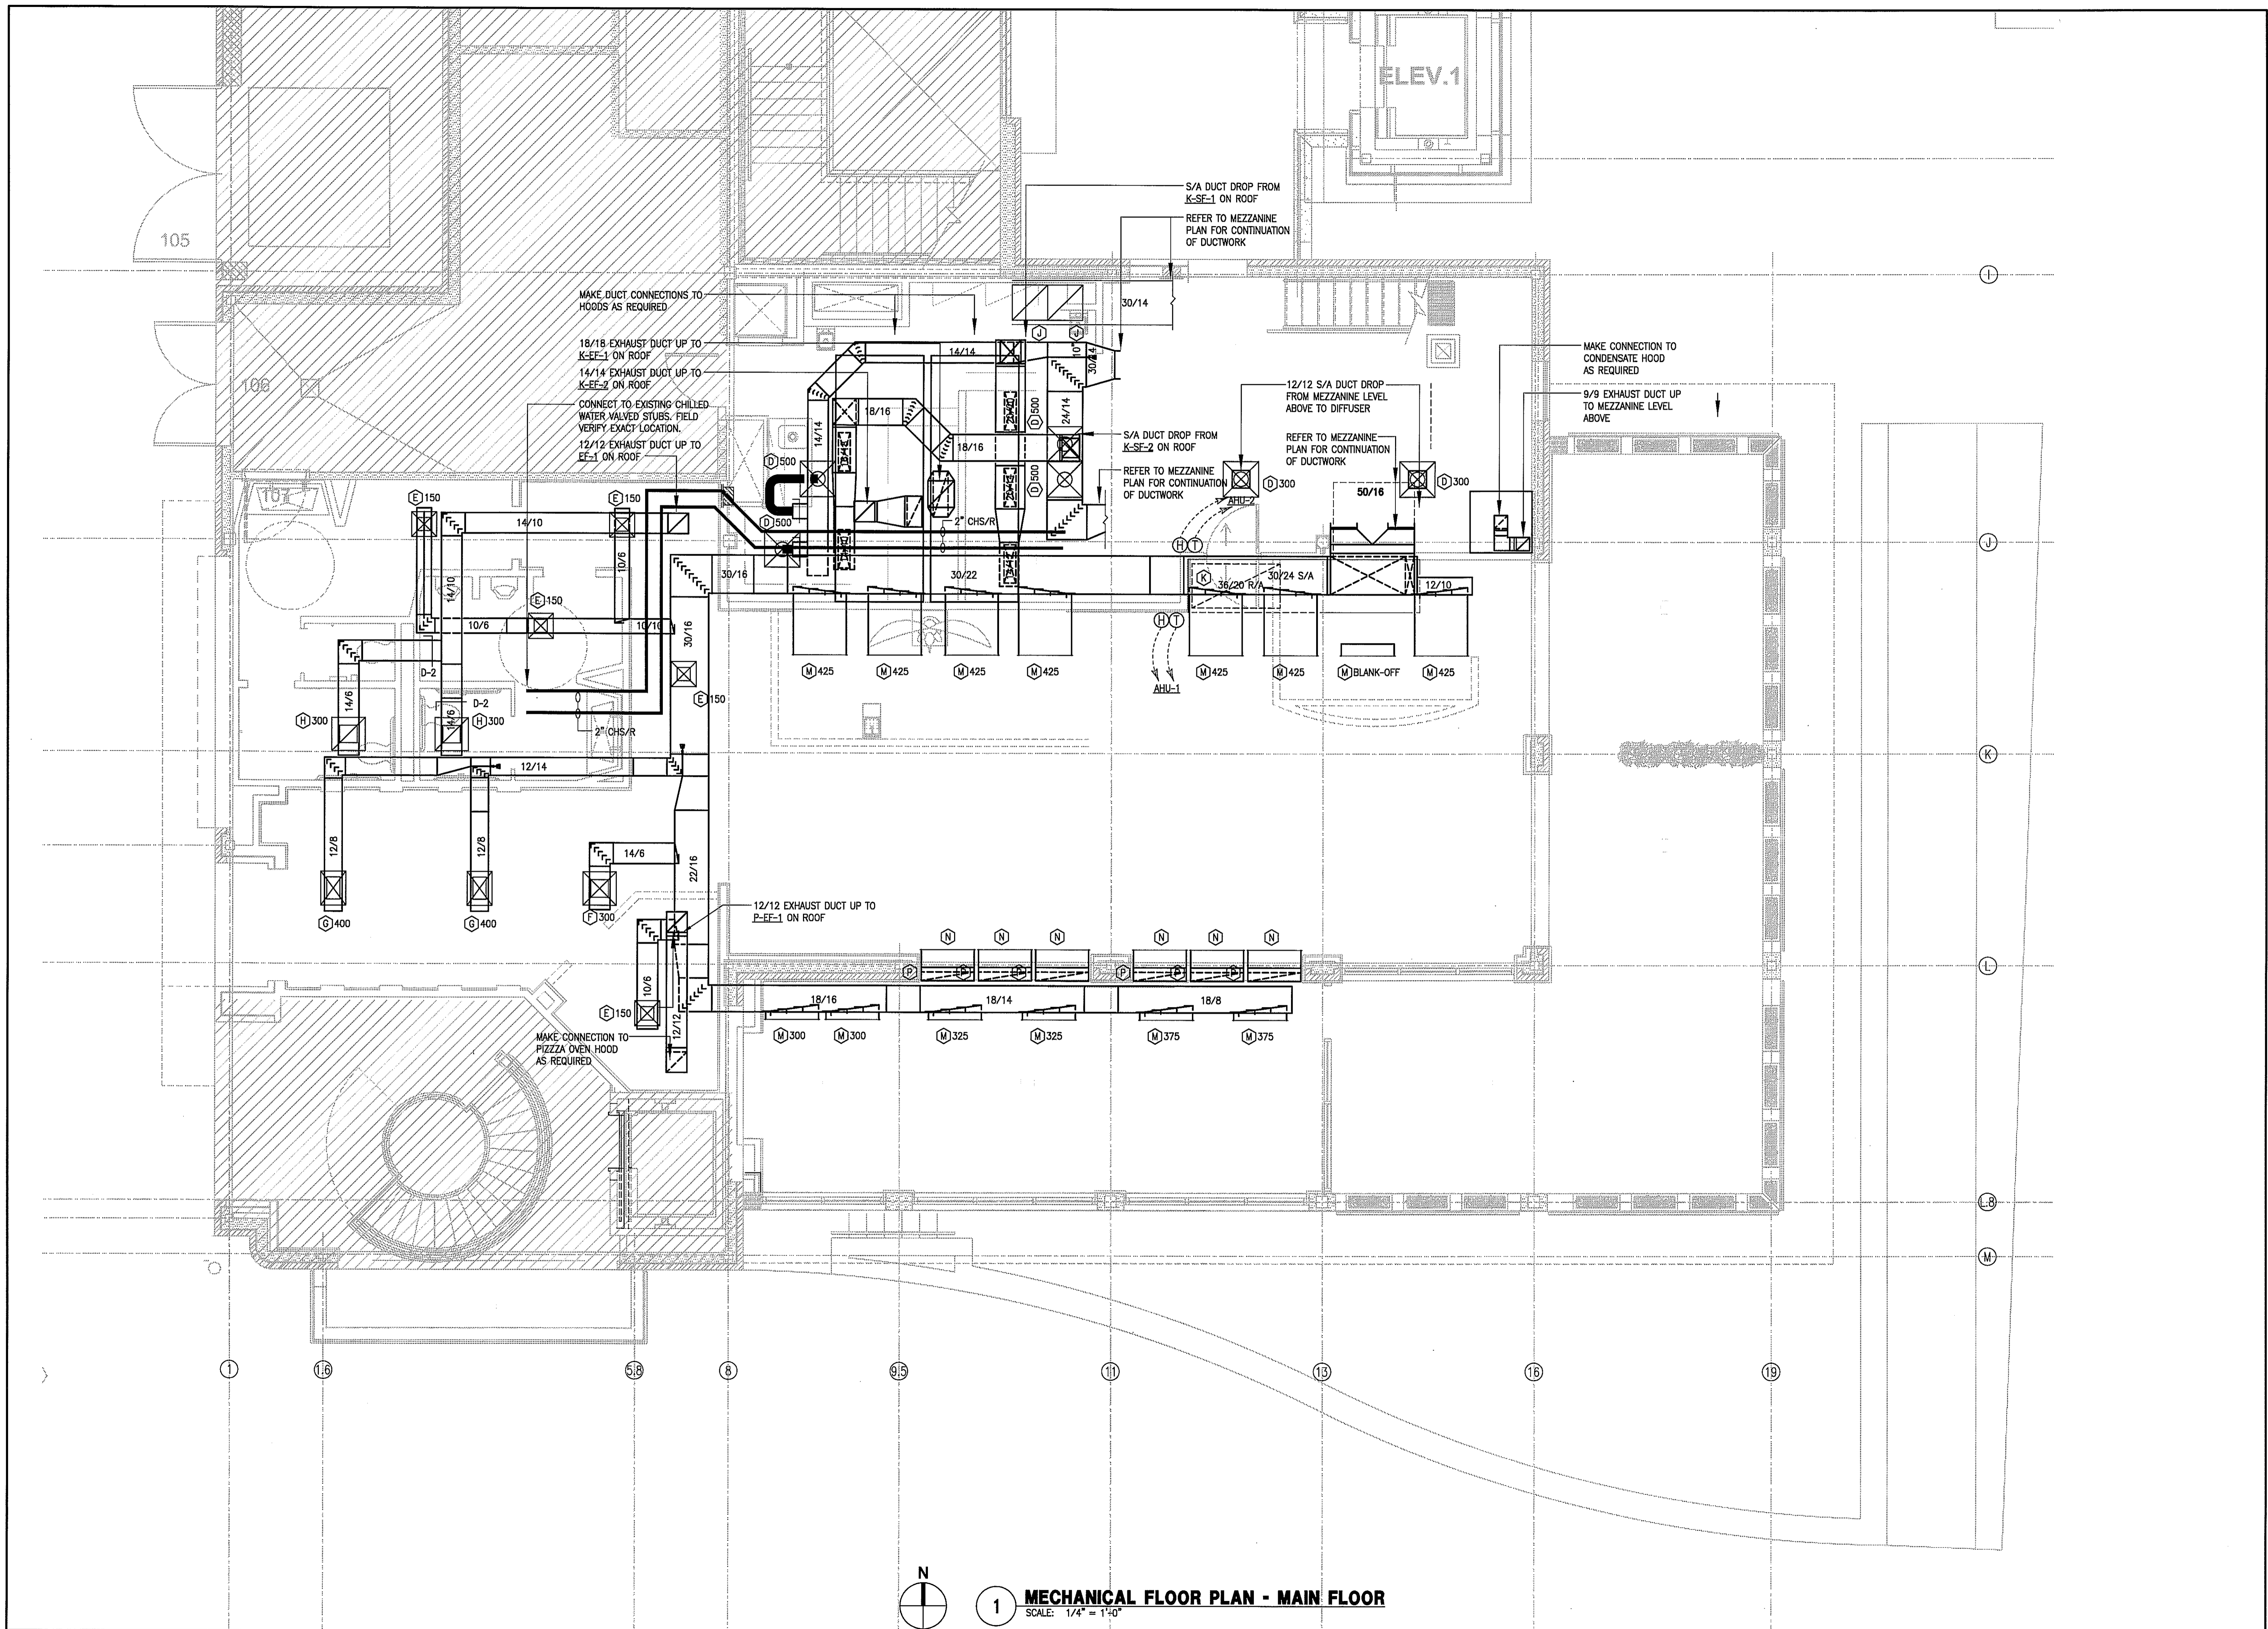

1 MECHANICAL FLOOR PLAN - MAIN FLOOR
 SCALE: 1/4" = 1'-0"

HARRELL
 ARCHITECTS, LP

9575 Katy Frwy., #200
 Houston, Texas 77024
 tel: 713.722.7071
 fax: 713.722.7072

CONSULTANTS
HOLSTE & ASSOCIATES
 MEP Engineers

Holste & Associates, Inc.
 Consulting Engineers - Texas Reg. F-5443
 6671 Southwest Frwy., Suite 850
 Houston, Texas 77074 (713) 955-1351
 www.holstemep.com

PROJECT NAME
LUCA & LEONARDO RESTAURANT
LUCA & LEONARDO
 HISTORIC

PROJECT ADDRESS
 20 WATERWAY
 THE WOODLANDS, TEXAS

PROJECT NUMBER
 10018
 SHEET NAME
MECHANICAL FLOOR PLAN
 SHEET NUMBER

M1.00