


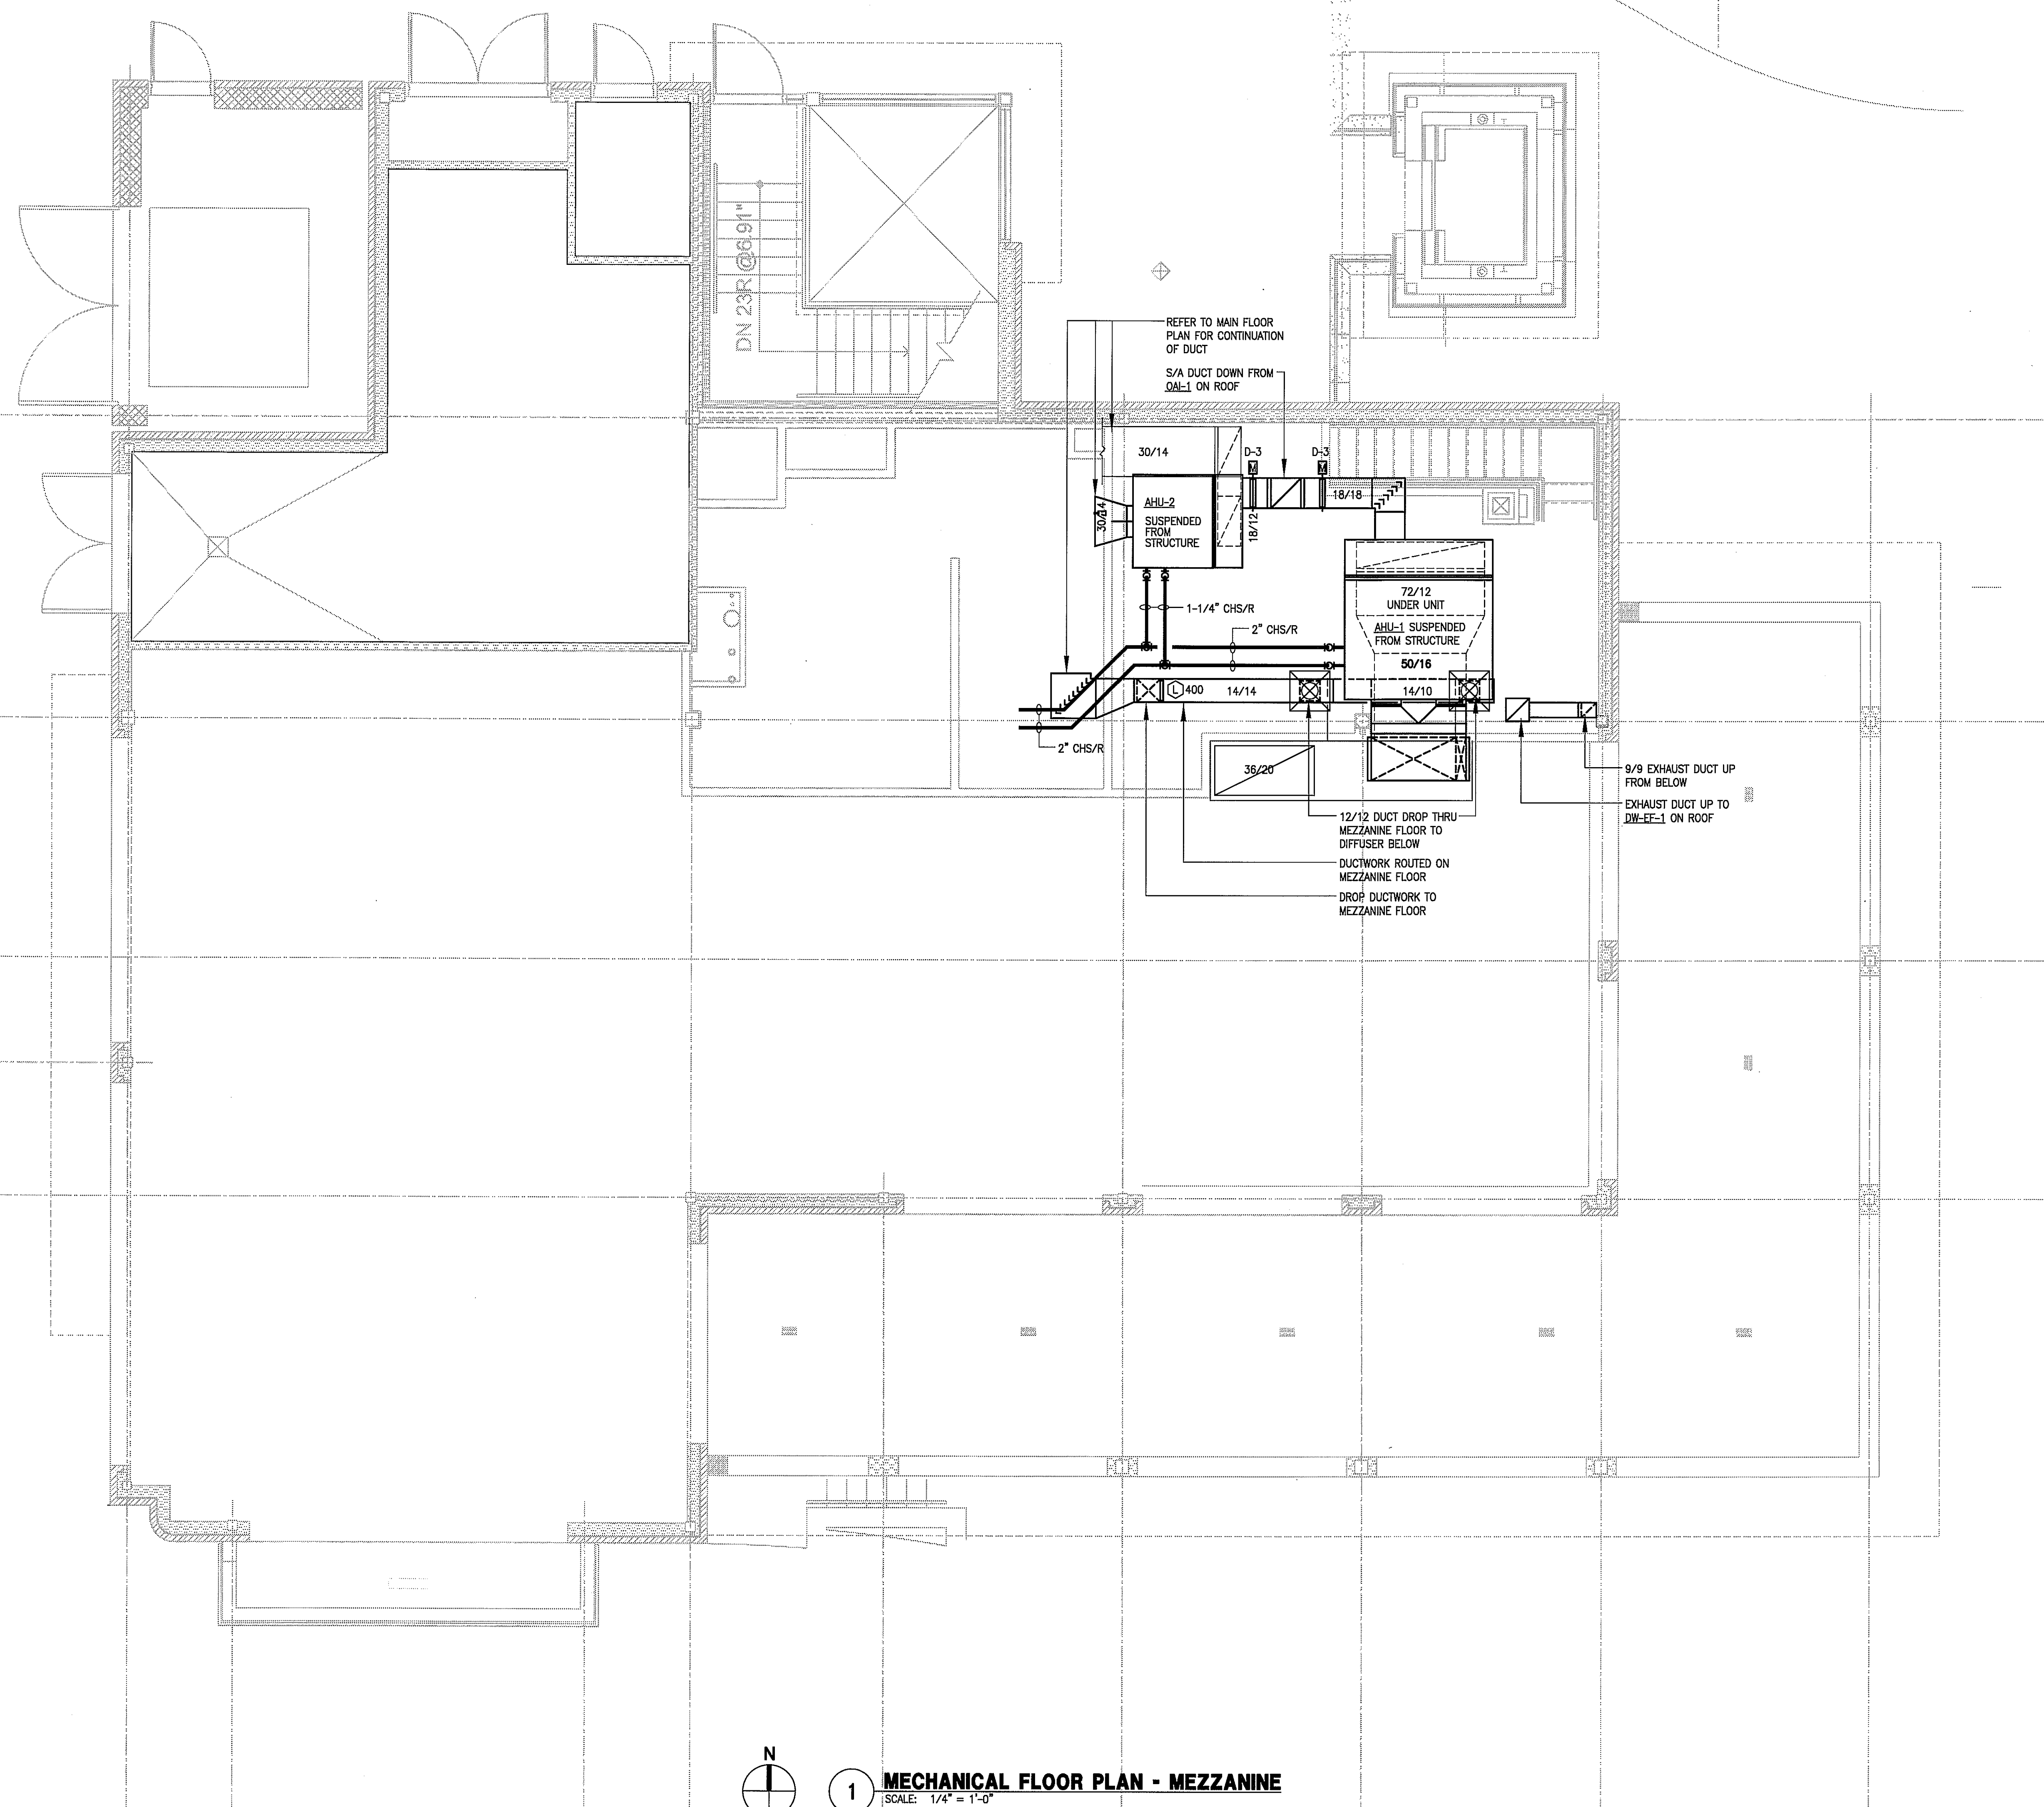


ISSUE  
 08-10-10 ISSUED FOR PERMIT  
 10-08-10 DBR REVIEW COMMENTS  
 11-02-10 ISSUED FOR CONSTRUCTION



9575 Katy Frwy., #200  
 Houston, Texas 77024  
 tel: 713.722.7071  
 fax: 713.722.7072

CONSULTANTS  
 HOLSTE & ASSOCIATES  
 MEP Engineers

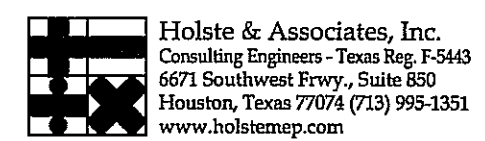


PROJECT NAME  
**LUCA & LEONARDO RESTAURANT**  
**LUCA & LEONARDO**  
 RESTAURANT

PROJECT ADDRESS  
 20 WATERWAY  
 THE WOODLANDS, TEXAS

PROJECT NUMBER  
 10018  
 SHEET NAME  
**MEZZANINE FLOOR PLAN**  
 SHEET NUMBER

**M1.01**

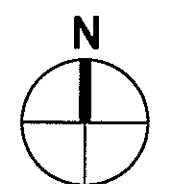

**1 MECHANICAL FLOOR PLAN - MEZZANINE**  
 SCALE: 1/4" = 1'-0"