



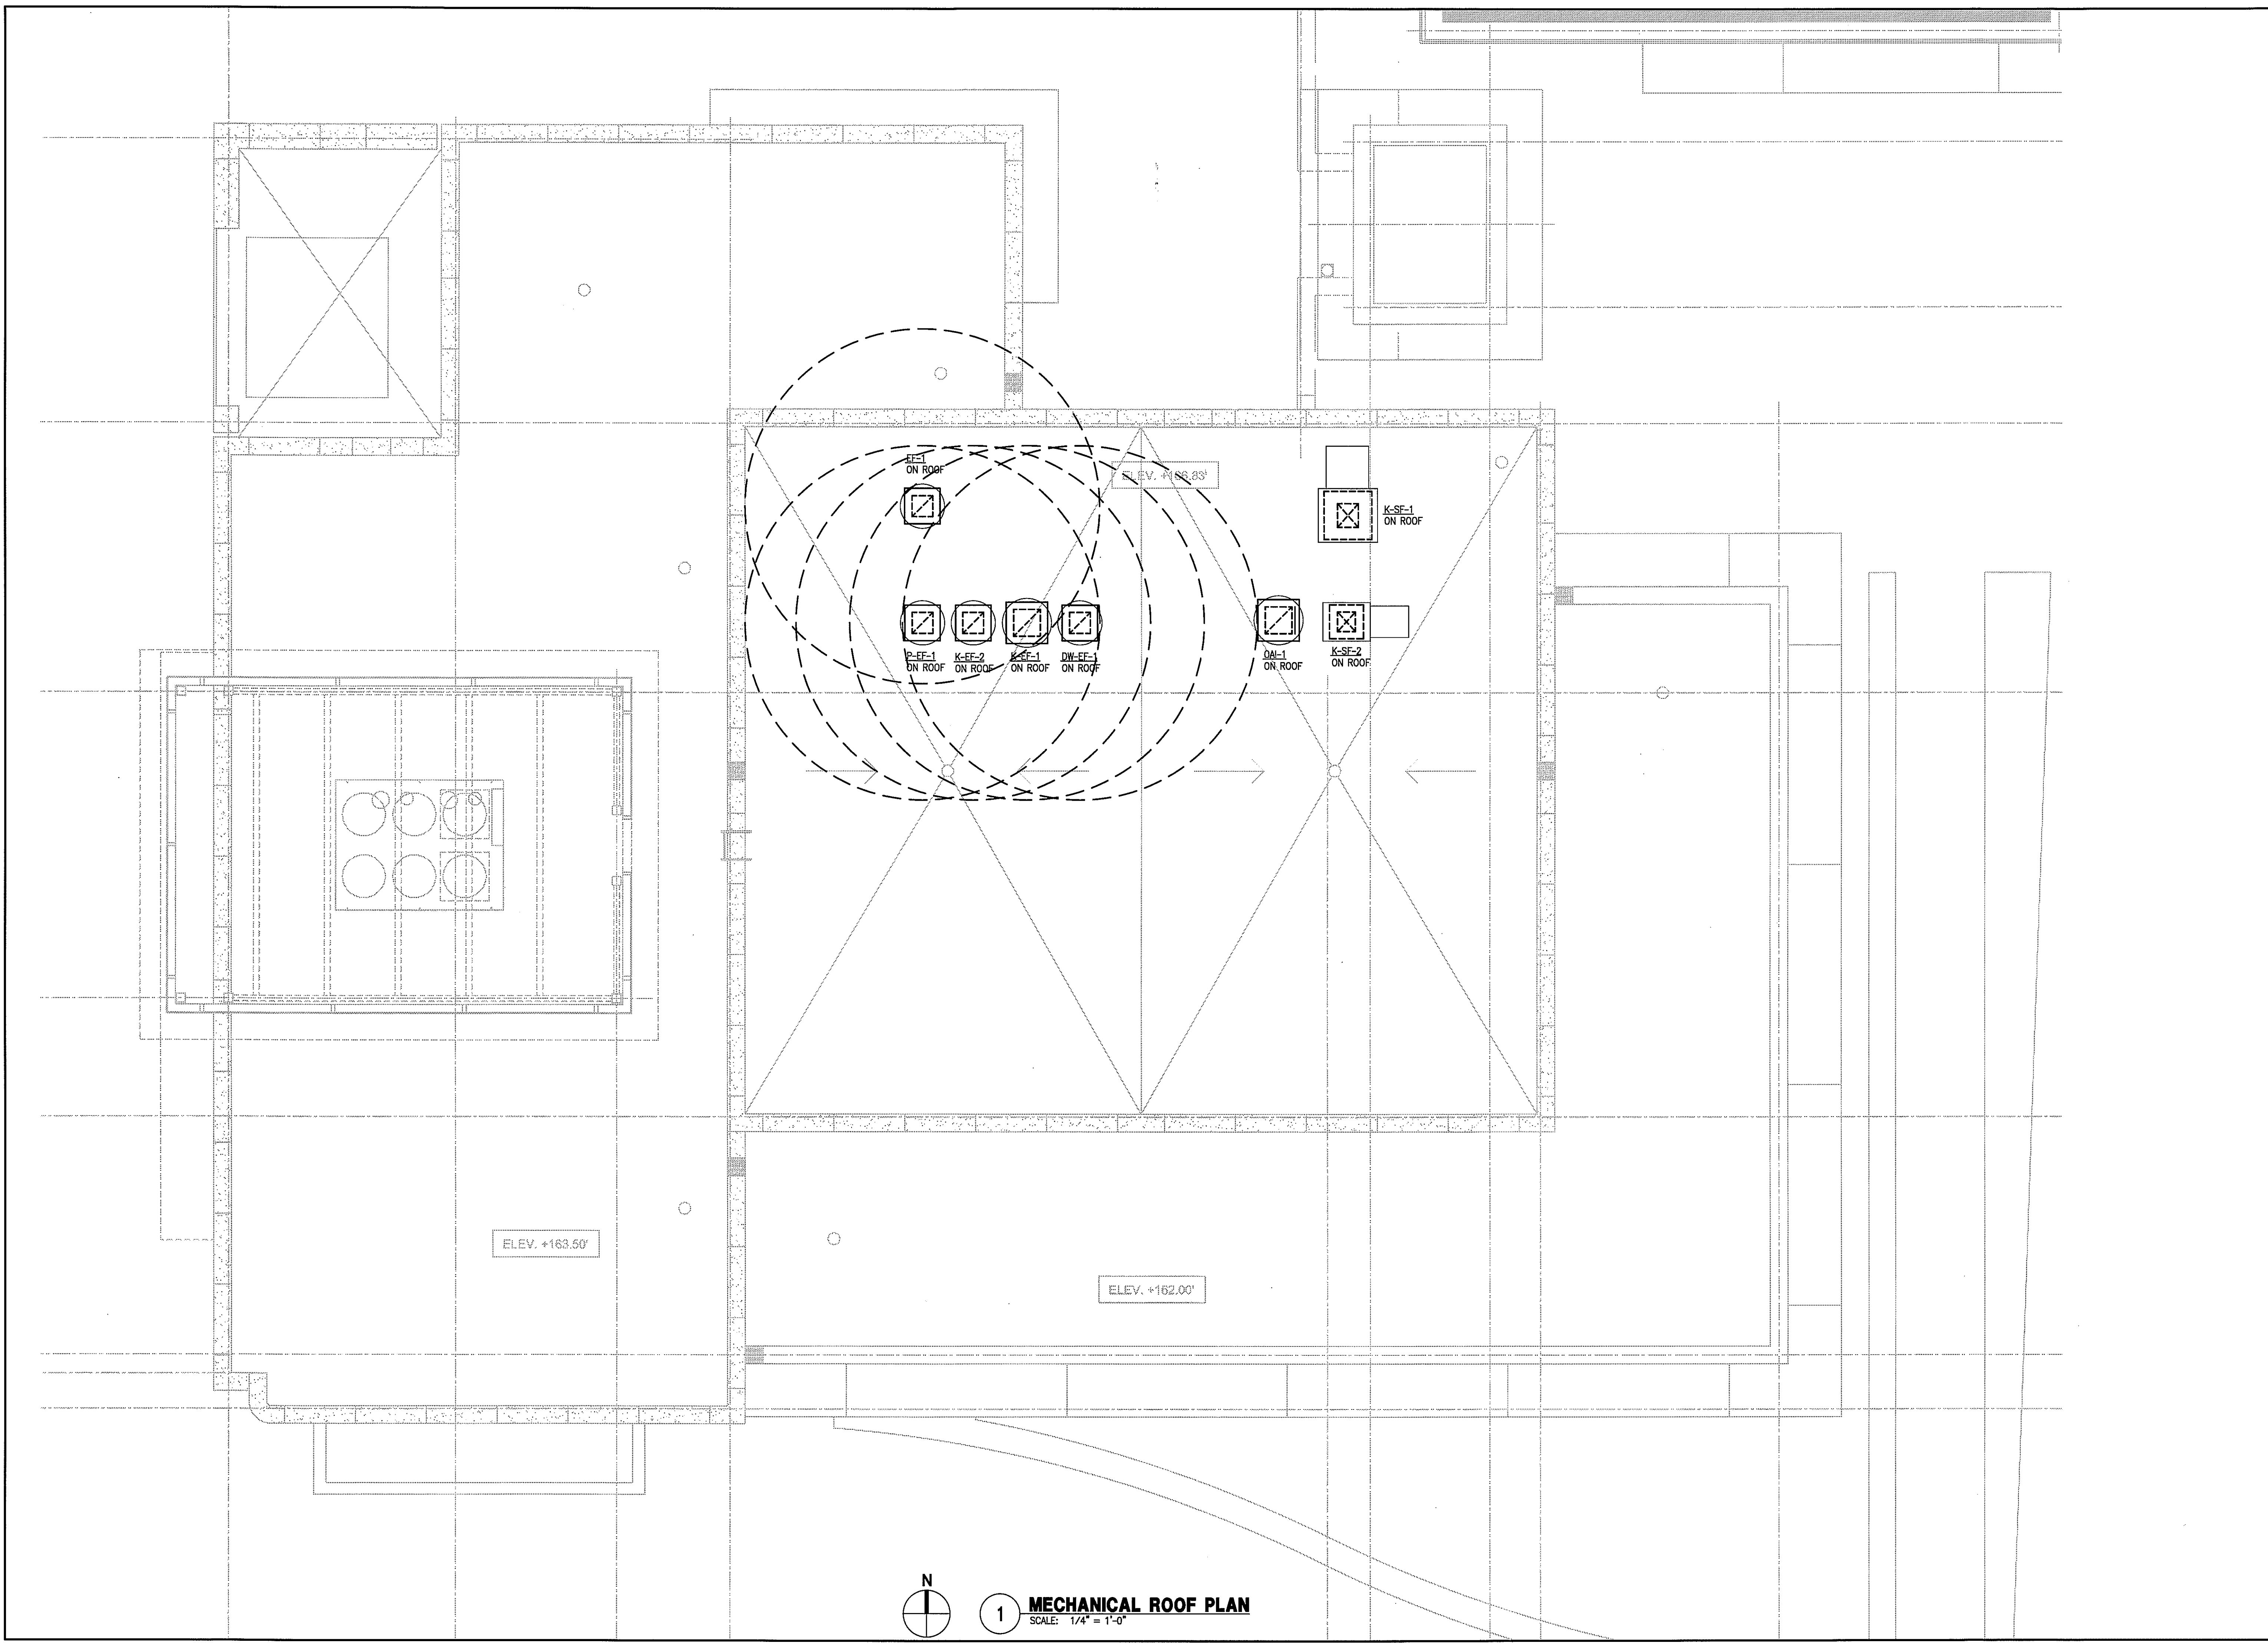


ISSUE  
 09-10-10 ISSUED FOR PERMIT  
 10-08-10 DBR REVIEW COMMENTS  
 11-02-10 ISSUED FOR CONSTRUCTION

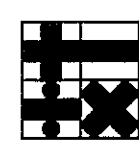

**HARRELL**  
 ARCHITECTS, LP  
 9575 Katy Frwy., #200  
 Houston, Texas 77024  
 tel: 713.722.7071  
 fax: 713.722.7072

CONSULTANTS  
**HOLSTE & ASSOCIATES**  
 MEP Engineers  
 Holste & Associates, Inc.  
 Consulting Engineers - Texas Reg. P-5443  
 6671 Southwest Frwy., Suite 530  
 Houston, Texas 77074 (713) 995-1351  
 www.holstemep.com

PROJECT NAME  
**LUCA & LEONARDO RESTAURANT**  
  
 PROJECT ADDRESS  
 20 WATERWAY  
 THE WOODLANDS, TEXAS

PROJECT NUMBER  
 10018  
 SHEET NAME  
**MECHANICAL ROOF PLAN**  
 SHEET NUMBER

**M1.02**

N  
 1 **MECHANICAL ROOF PLAN**  
 SCALE: 1/4" = 1'-0"