





ISSUE
 09-10-10 ISSUED FOR PERMIT
 10-08-10 DBR REVIEW COMMENTS
 11-02-10 ISSUED FOR CONSTRUCTION

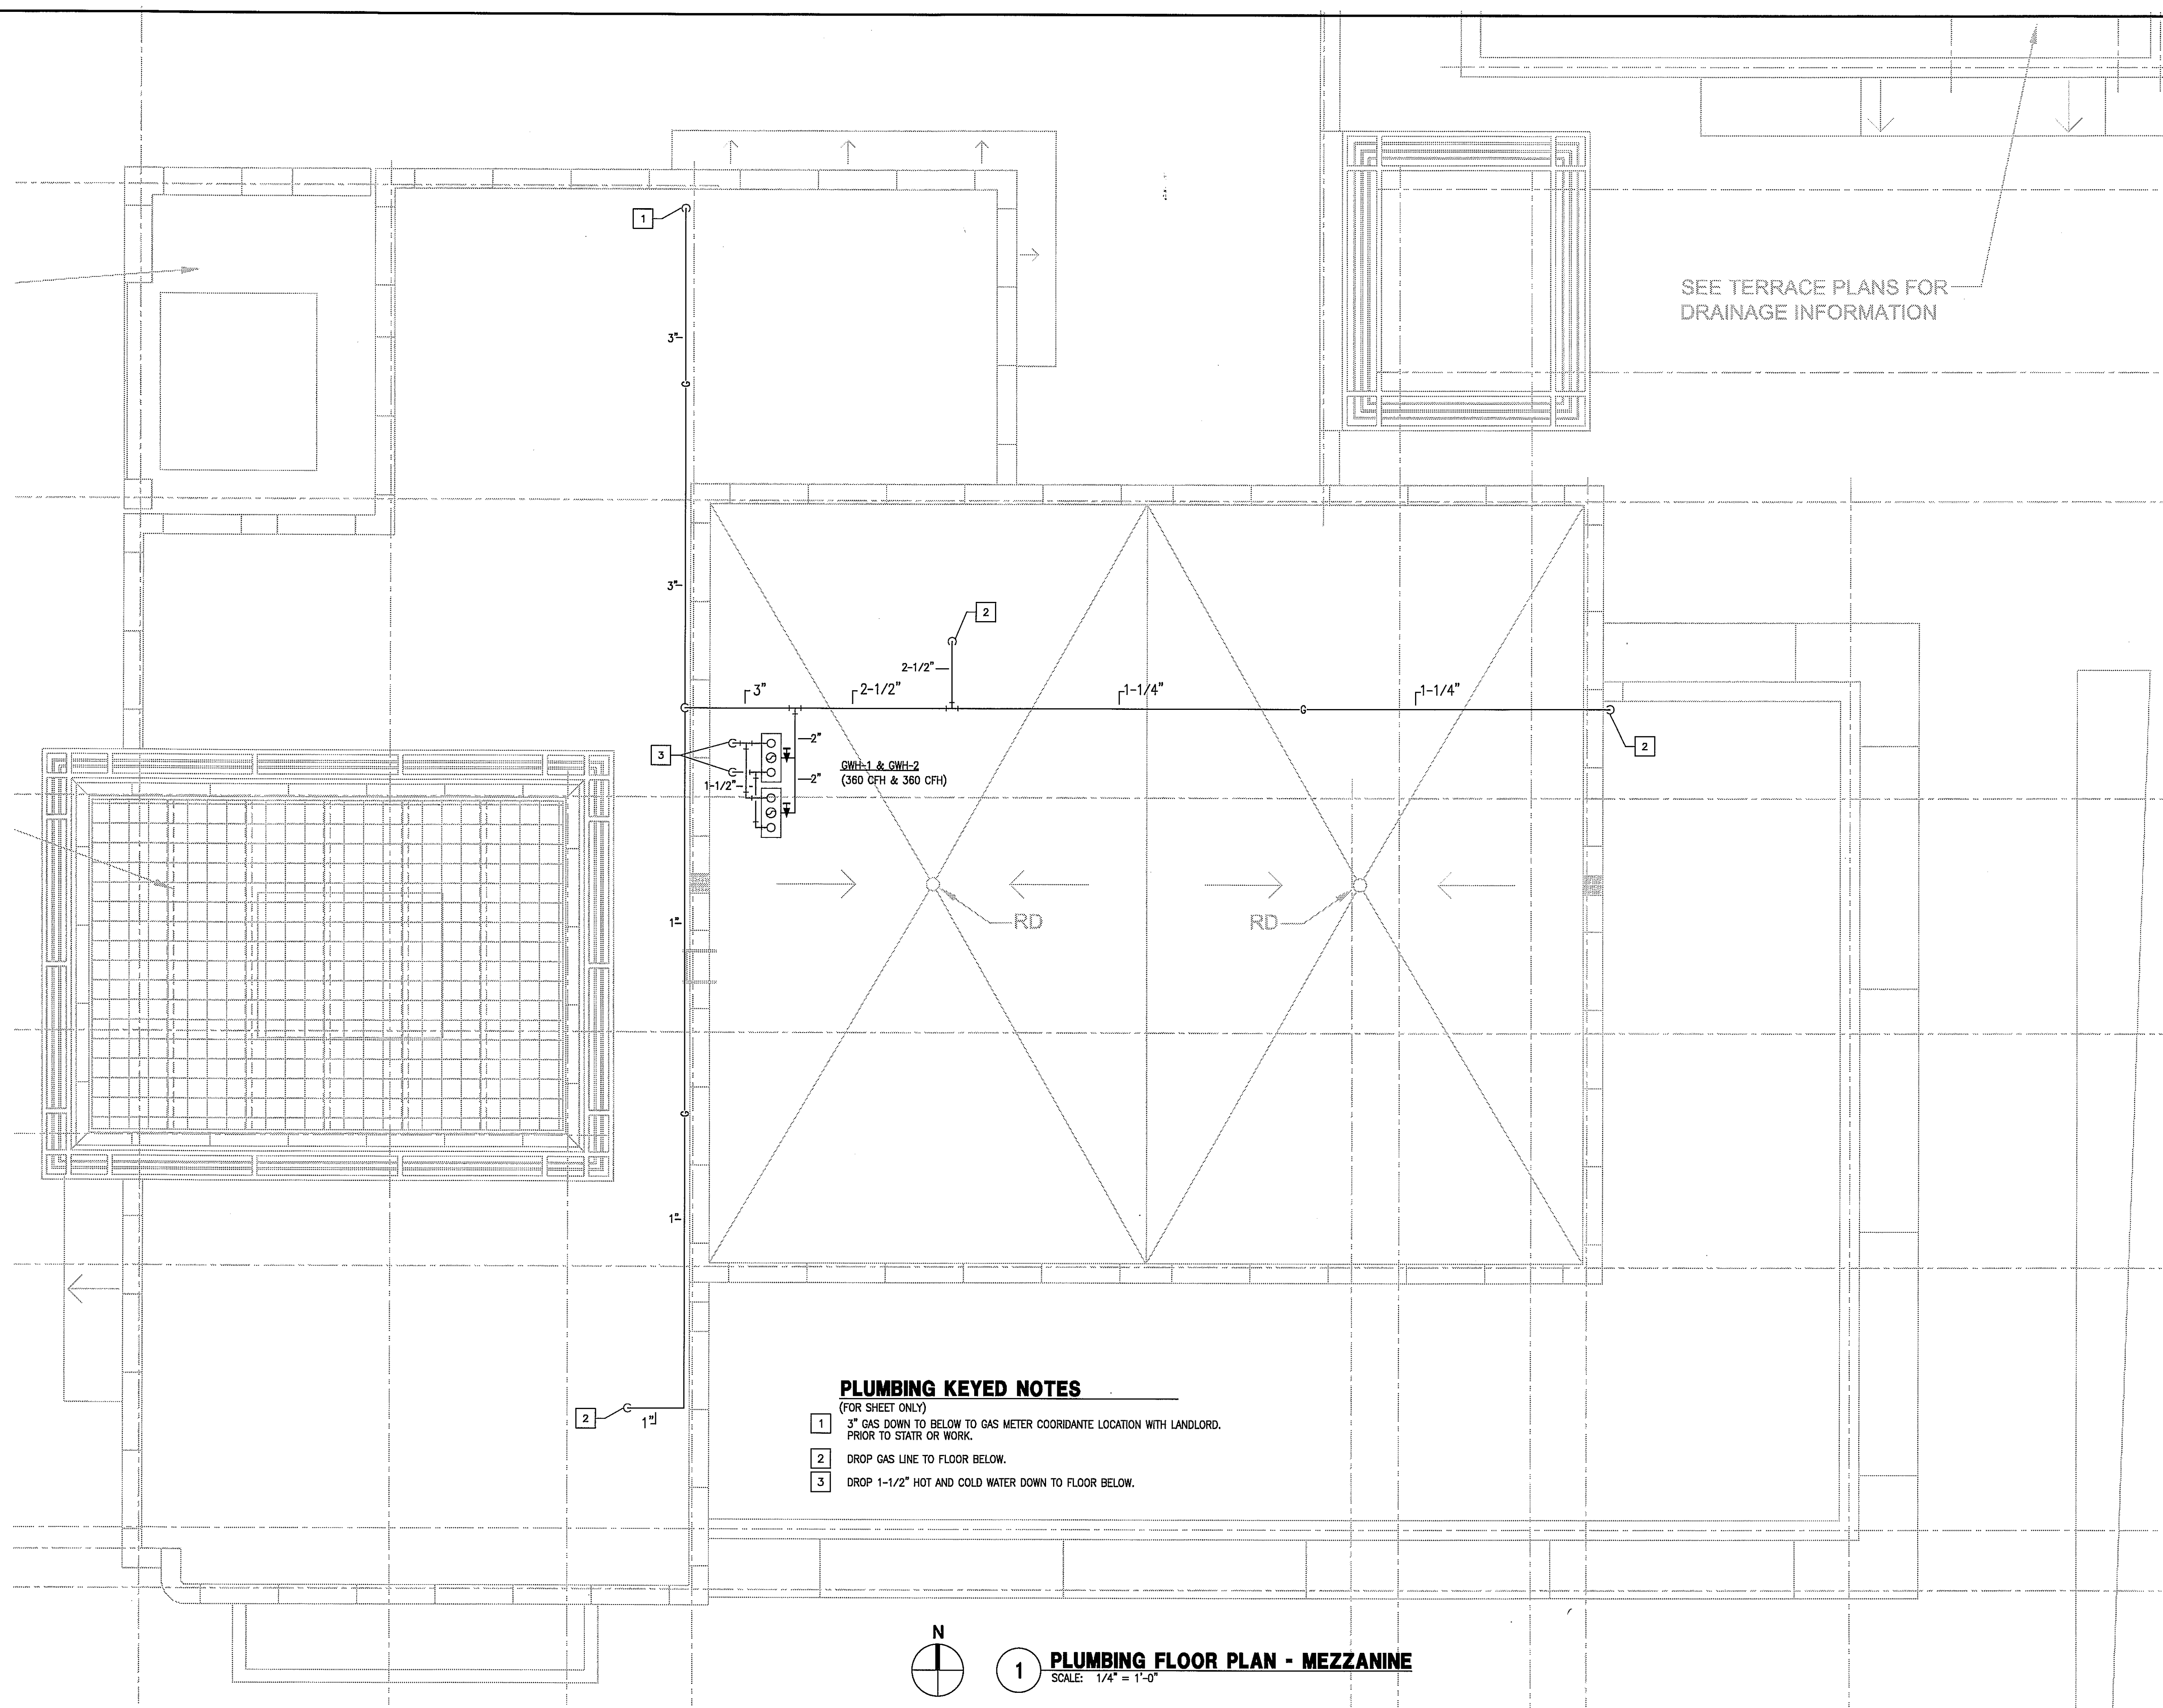

PLUMBING KEYED NOTES

- (FOR SHEET ONLY)
- 1 3" GAS DOWN TO BELOW TO GAS METER COORDINATE LOCATION WITH LANDLORD. PRIOR TO START OR WORK.
 - 2 DROP GAS LINE TO FLOOR BELOW.
 - 3 DROP 1-1/2" HOT AND COLD WATER DOWN TO FLOOR BELOW.

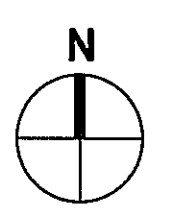

1 PLUMBING FLOOR PLAN - MEZZANINE
 SCALE: 1/4" = 1'-0"

HARRELL
 ARCHITECTS, LP

9575 Katy Frwy., #200
 Houston, Texas 77024
 tel: 713.722.7071
 fax: 713.722.7072

CONSULTANTS
HOLSTE & ASSOCIATES
 MEP Engineers

Holste & Associates, Inc.
 Consulting Engineers - Texas Reg. P-5443
 6671 Southwest Frwy., Suite 850
 Houston, Texas 77074 (713) 995-1351
 www.holstemep.com

PROJECT NAME
LUCA & LEONARDO
 RESTAURANT

LUCA & LEONARDO
 RESTAURANT

PROJECT ADDRESS
 20 WATERWAY
 THE WOODLANDS, TEXAS

PROJECT NUMBER
 10018
 SHEET NAME
PLUMBING
MEZZANINE PLAN
 SHEET NUMBER

P1.01