




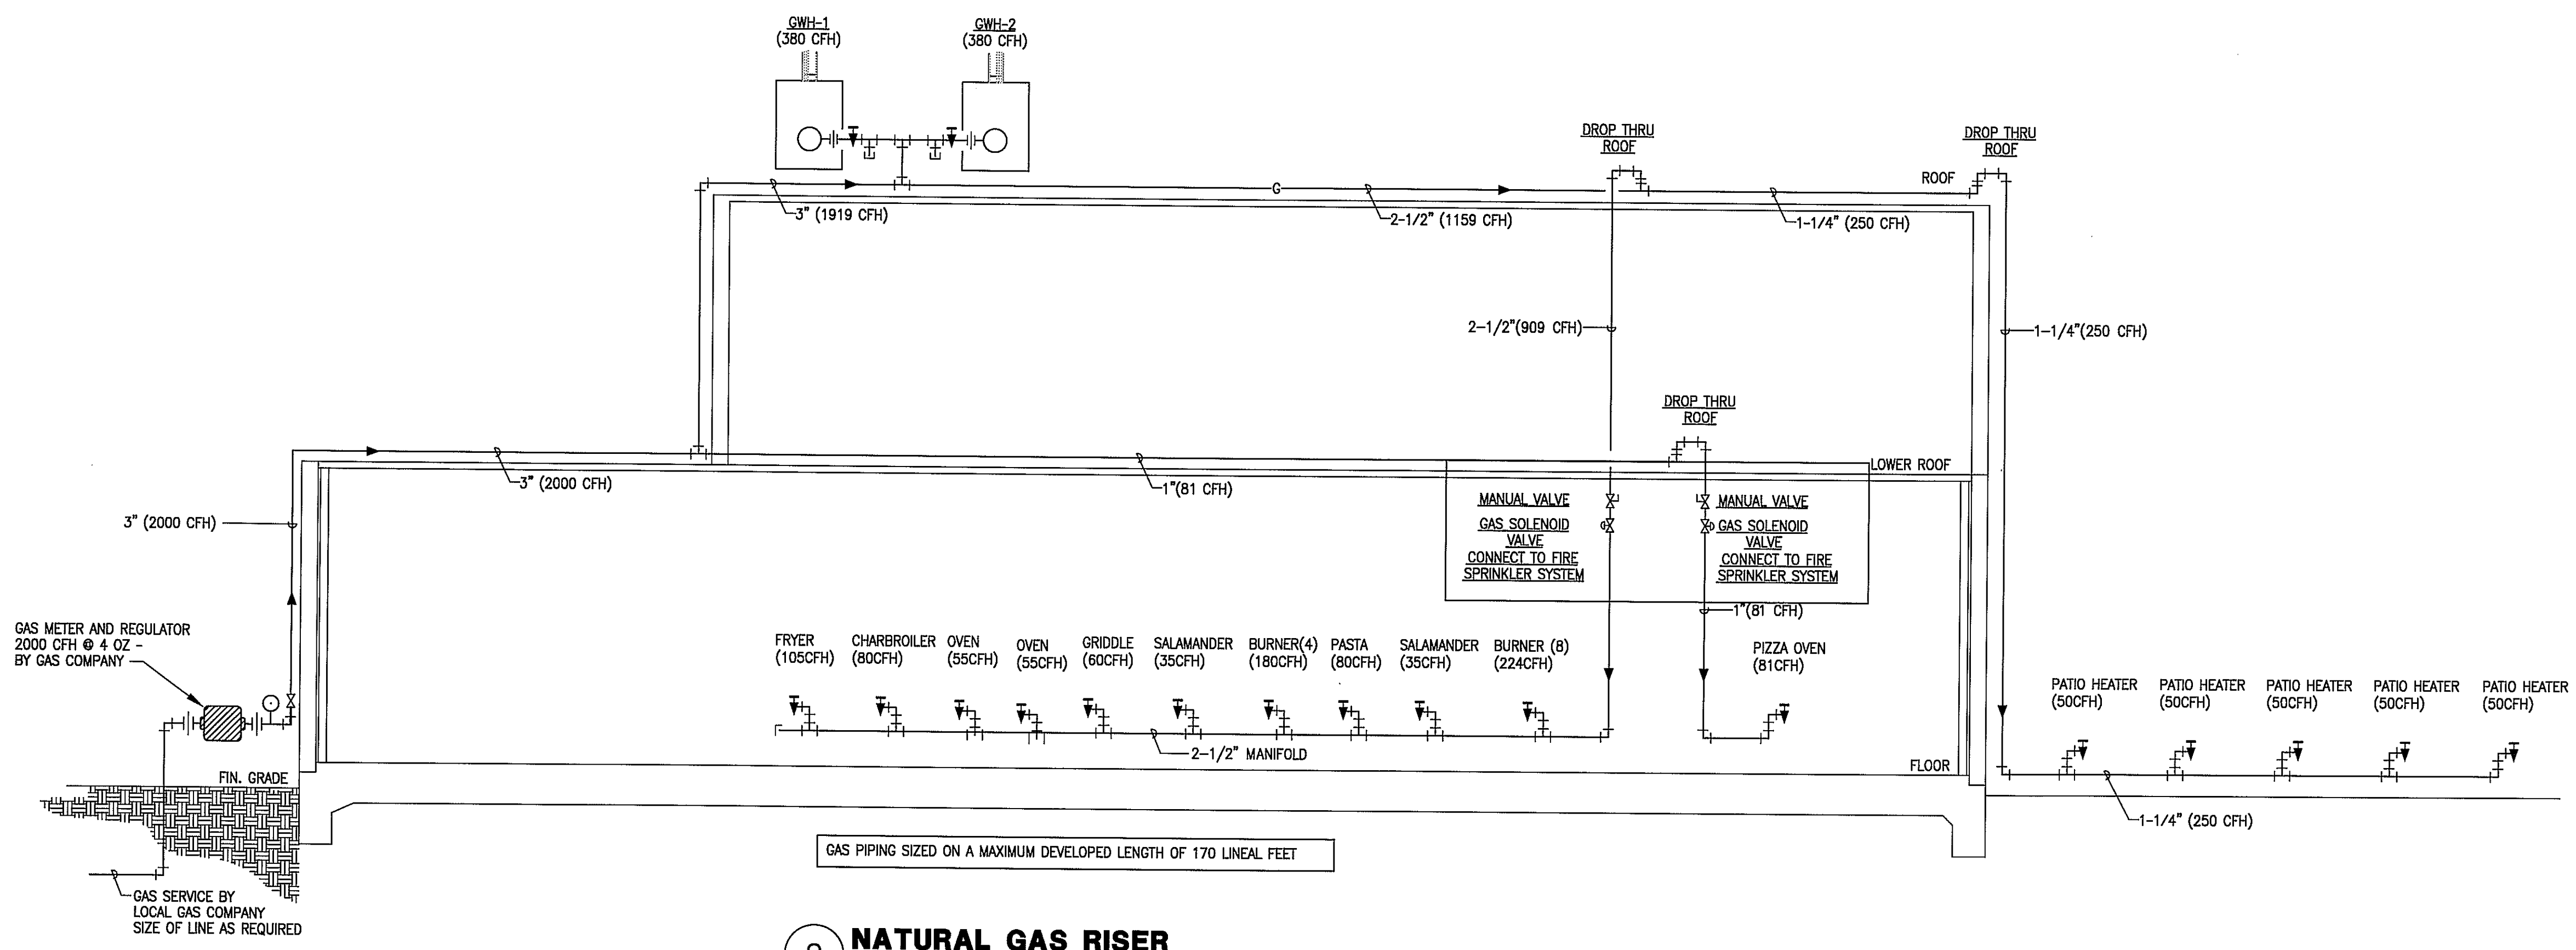

ISSUE
 09-10-10 ISSUED FOR PERMIT
 10-08-10 DBR REVIEW COMMENTS
 11-02-10 ISSUED FOR CONSTRUCTION

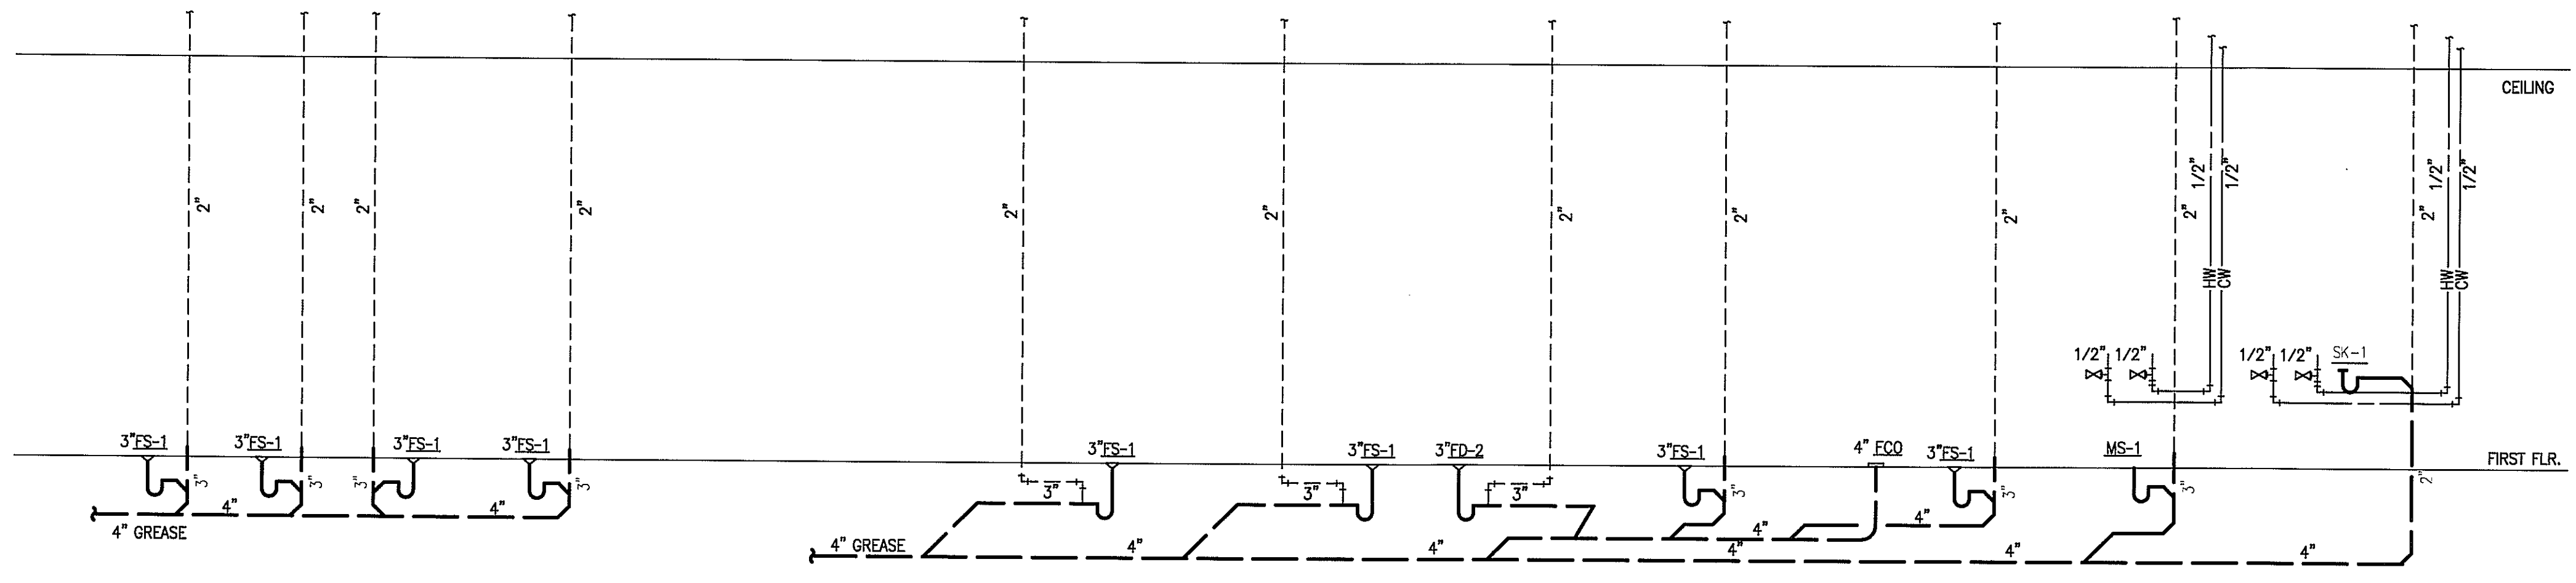

2 NATURAL GAS RISER
 SCALE: NONE

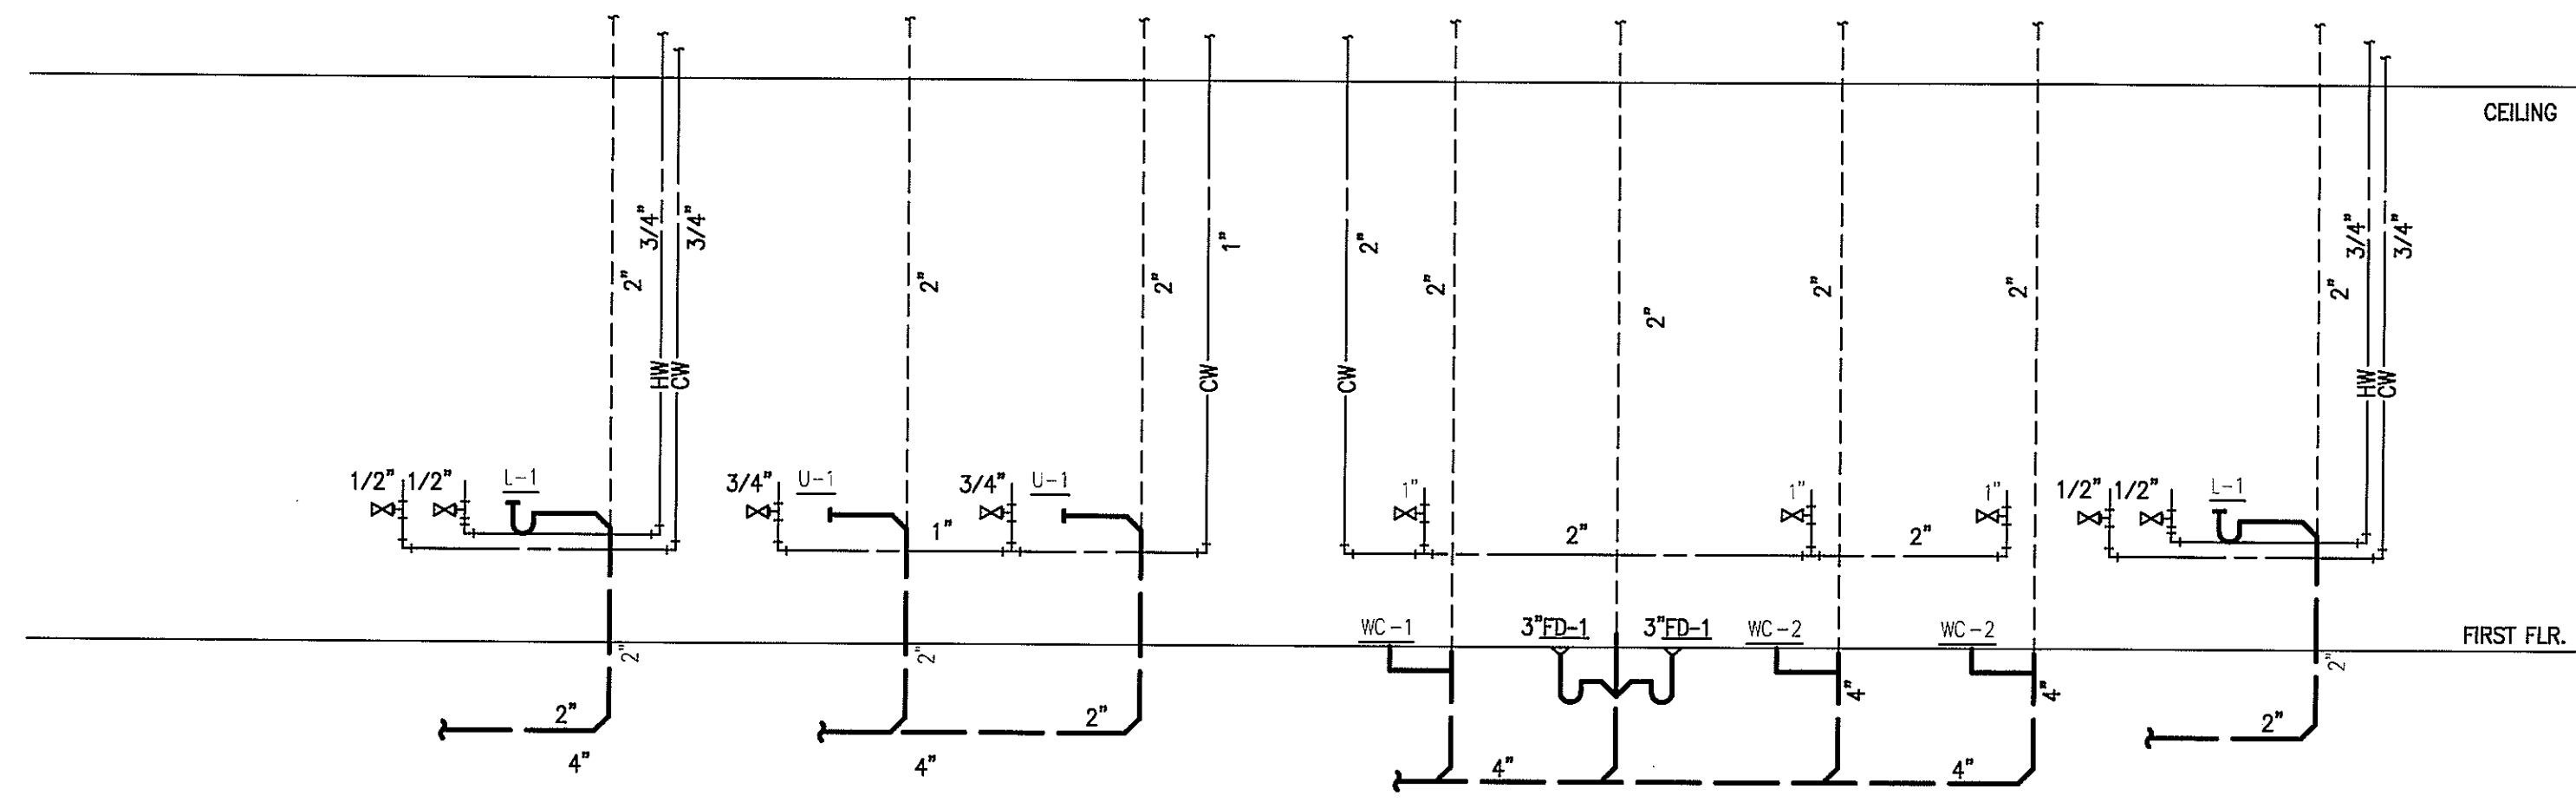

1 PLUMBING RISER DIAGRAM
 SCALE: NONE

HARRELL
 ARCHITECTS, LP
 9575 Katy Frwy., #200
 Houston, Texas 77024
 Tel: 713.722.7071
 Fax: 713.722.7072

CONSULTANTS
HOLSTE & ASSOCIATES
 MEP Engineers
 Holste & Associates, Inc.
 Consulting Engineers - Texas Reg. F-5448
 6071 Southwest Freeway, Suite 500
 Houston, Texas 77056 (713) 999-1351
 www.holstemepe.com

PROJECT NAME
LUCA & LEONARDO RESTAURANT
LUCA & LEONARDO
 RESTAURANTE
 PROJECT ADDRESS
 20 WATERWAY
 THE WOODLANDS, TEXAS

PROJECT NUMBER
 10018
 SHEET NAME
PLUMBING GAS RISER & DETAILS
 SHEET NUMBER

P4.00