
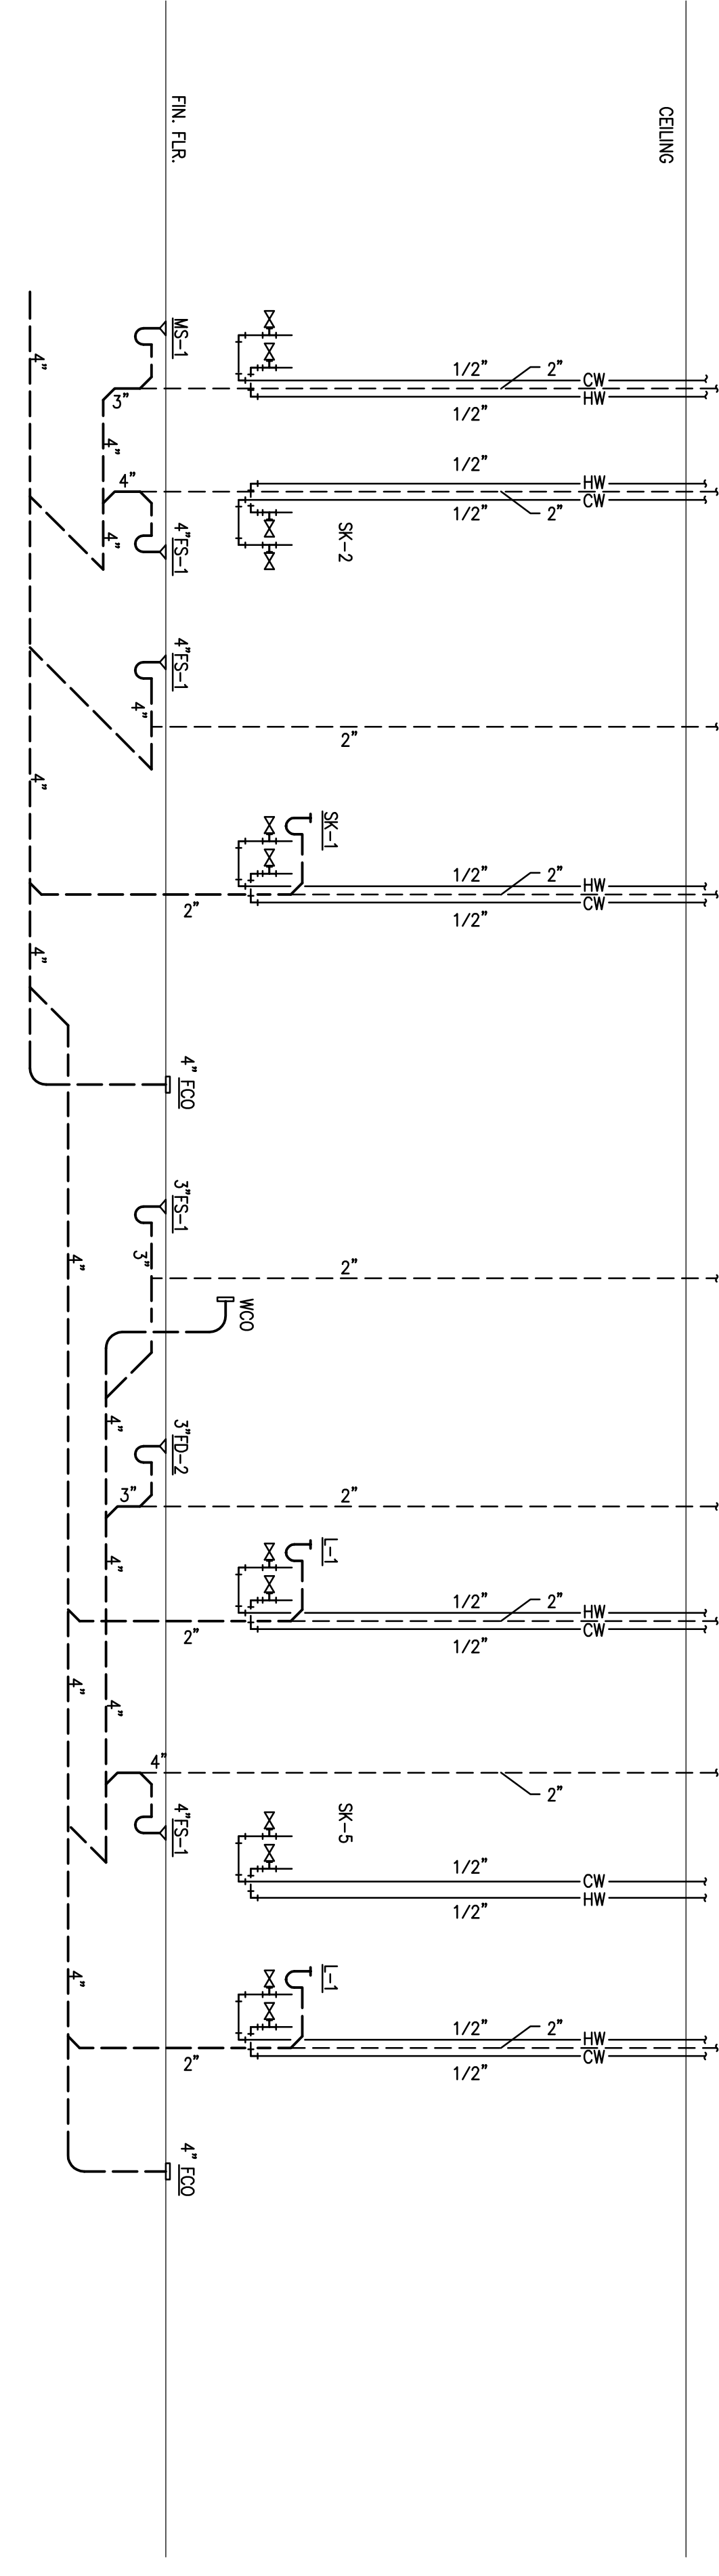



ISSUE
 01/29/12 ISSUED FOR PERMIT
 02/16/12 ISSUE FOR BID

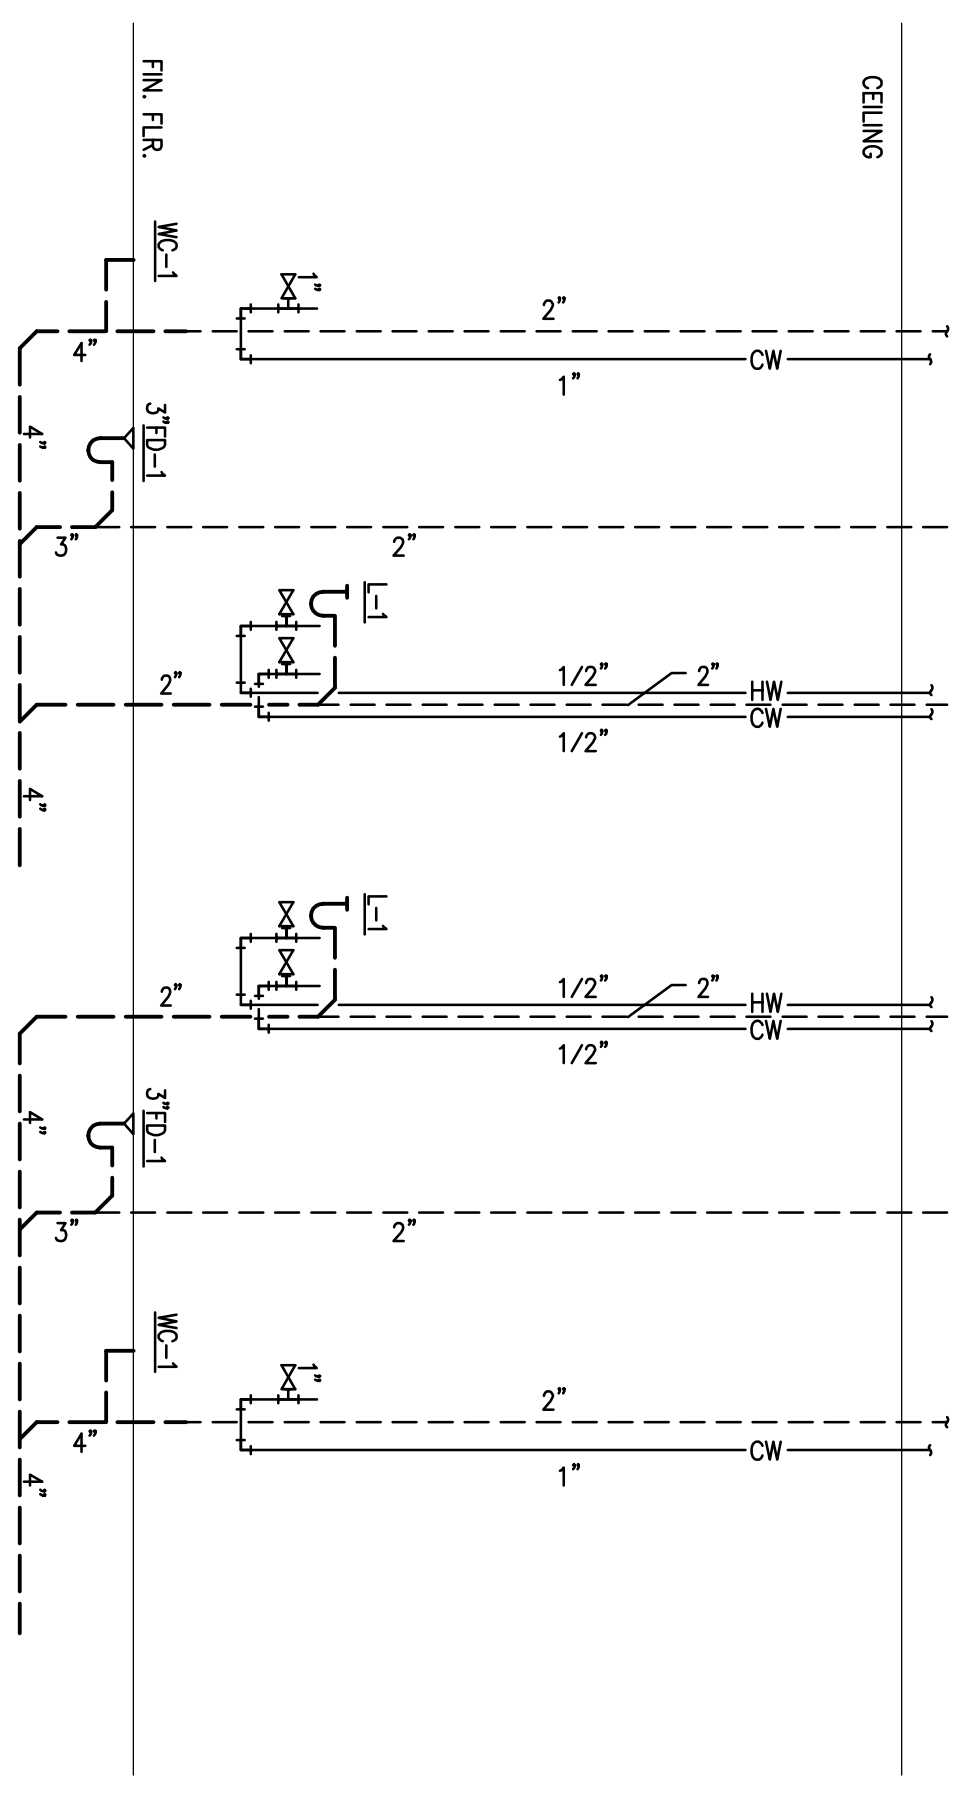

1
 PLUMBING RISER DIAGRAMS
 SCALE: NONE

HARRELL
 ARCHITECTS, LP

9272 Katy Frewy, #208
 Houston, Texas 77024
 Tel: 713.222.7071
 Fax: 713.222.7072

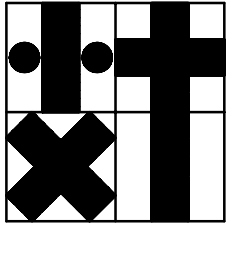

Holsie & Associates, Inc.
 Consulting Engineers - Texas Reg. F-5443
 6671 Southwest Frewy., Suite 850
 Houston, Texas 77074 (713) 995-1351
 www.holsie.com
 Contact: Bob Schmitt (832) 943-0898

PROJECT NAME
Maharaja Bhog

PROJECT ADDRESS
 8338 Southwest Freeway
 Houston, Texas 77074

PROJECT NUMBER
 11078

SHEET NAME
**PLUMBING
 RISER DIAGRAMS**

SHEET NUMBER
P5.1