


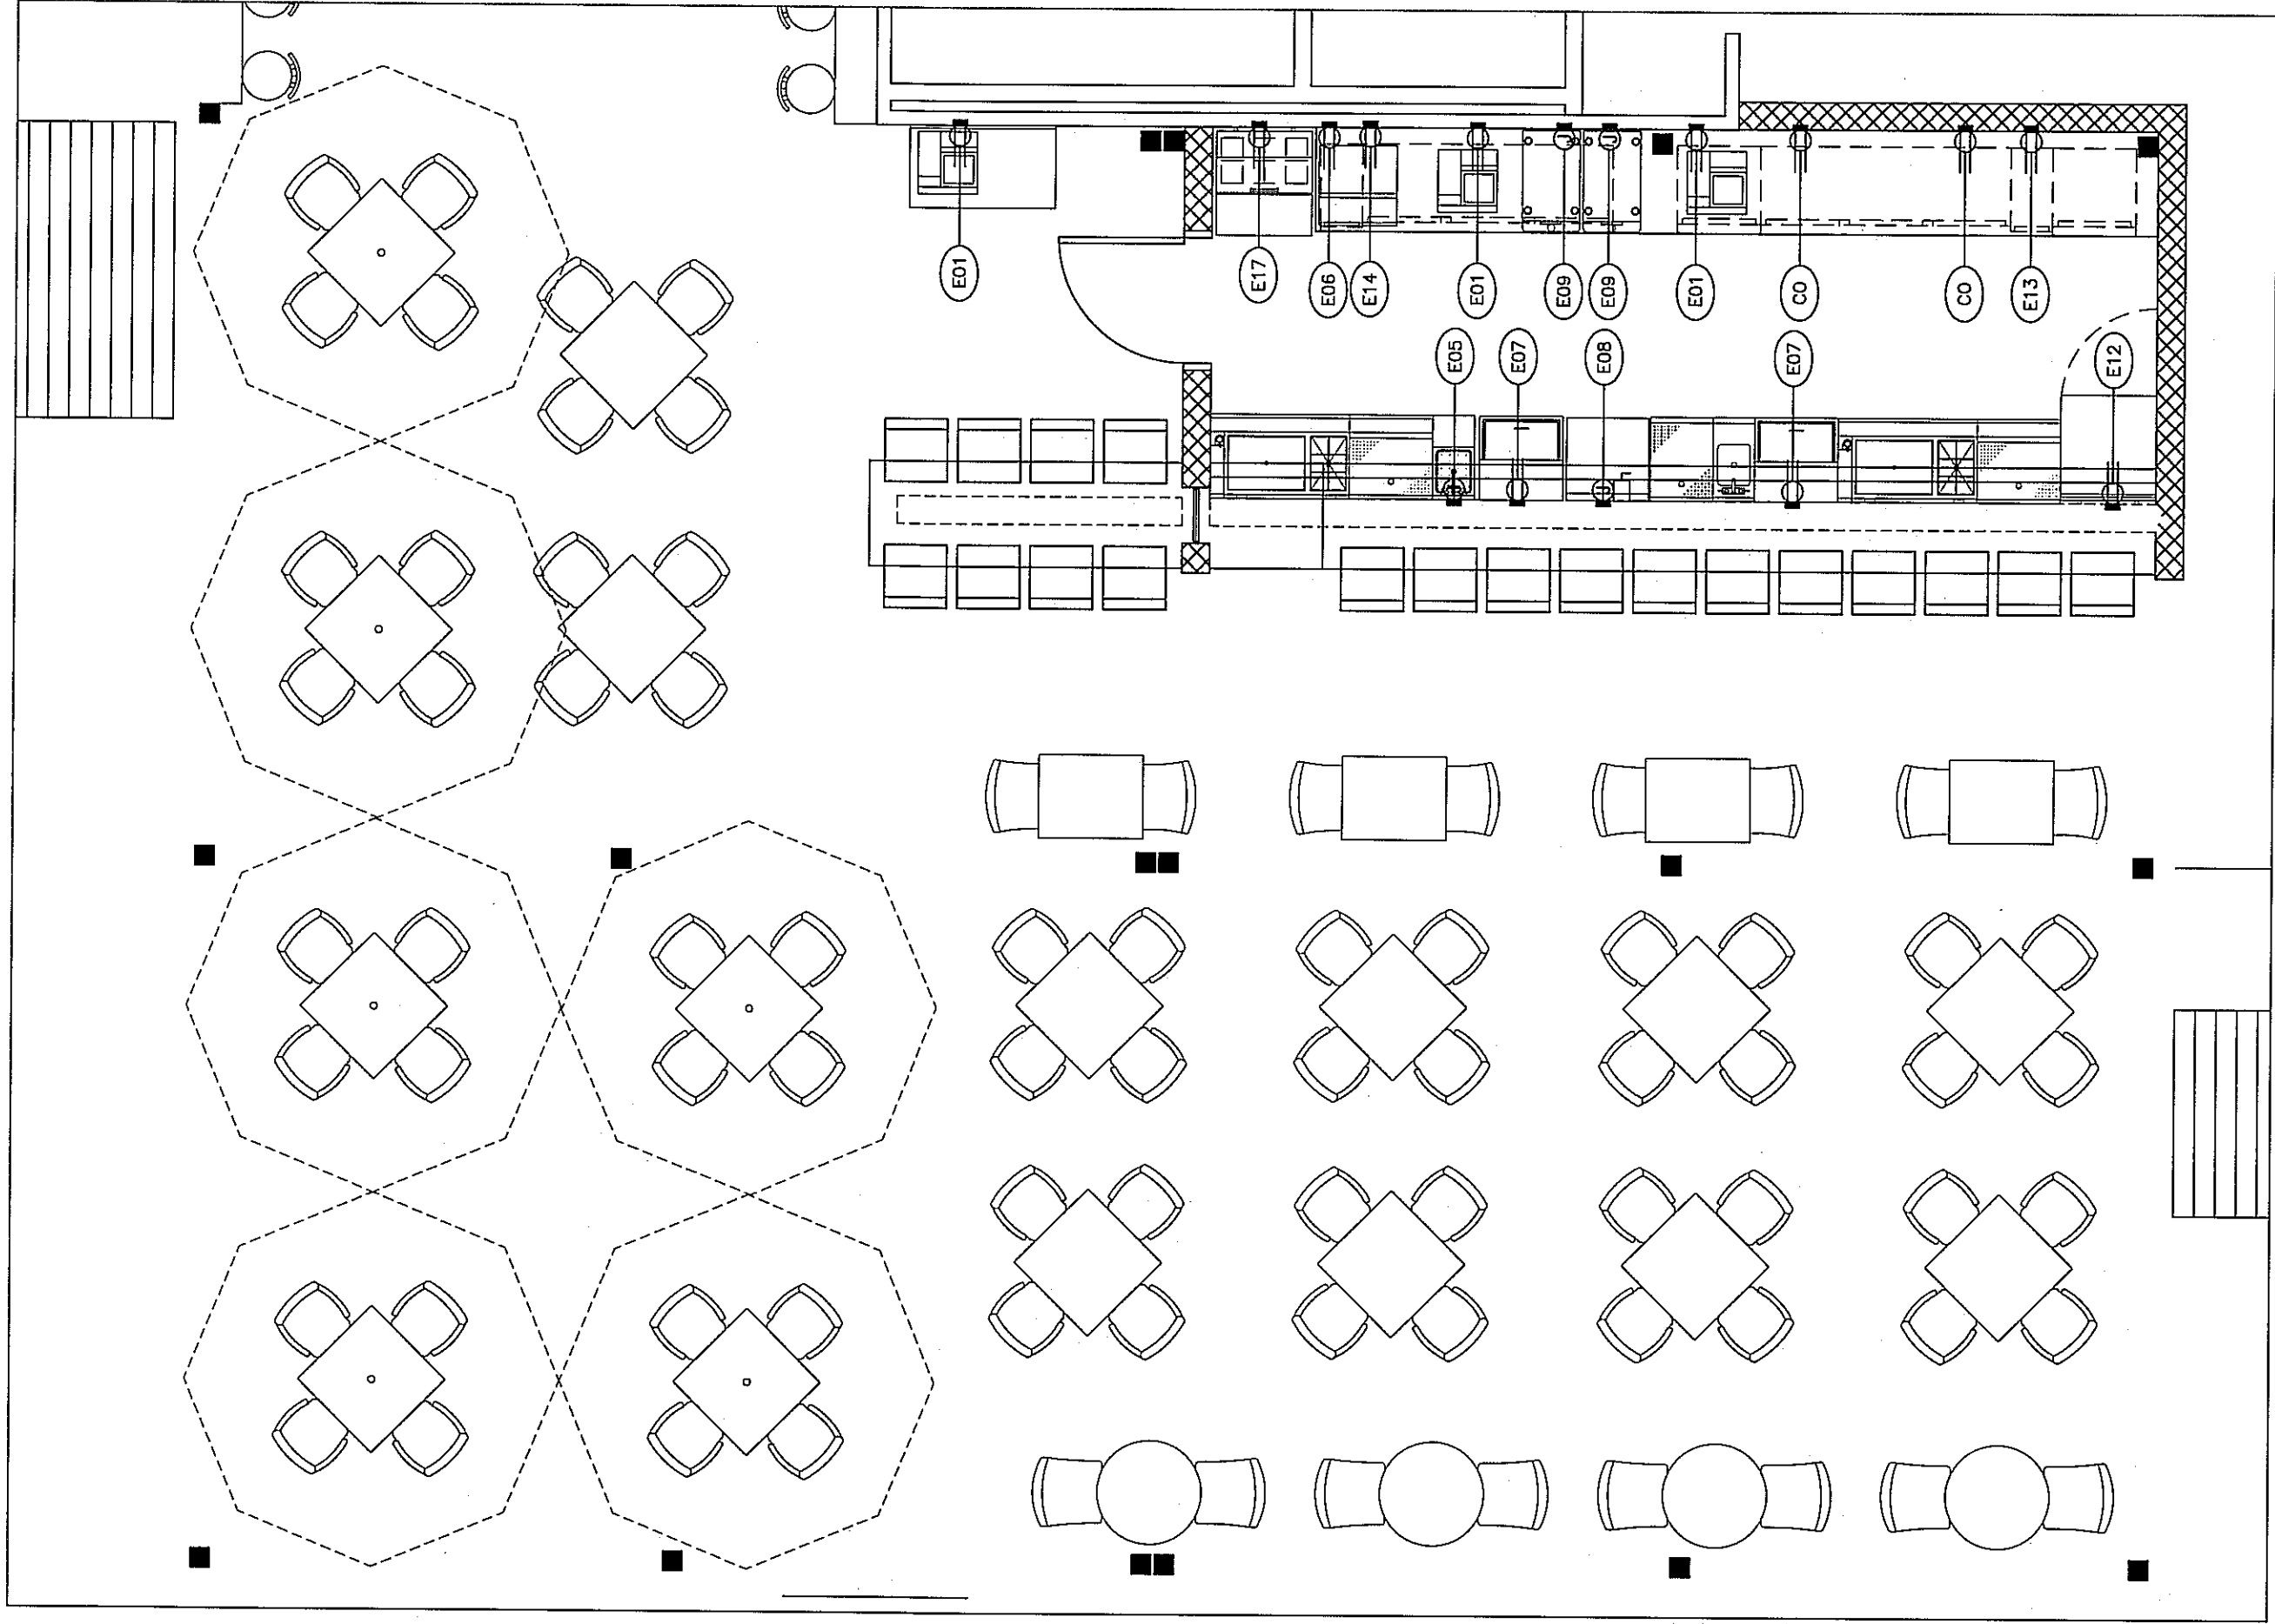

MAIN BAR
ELECTRICAL ROUGH-IN

SCALE: 1/4"=1'-0"


ELECTRICAL SCHEDULE

Item	Qty	Equipment Category	Volts	Amps	Phase	Electrical Aff	Location	Direct Connection	NEMA	Electrical Remarks
E01	2	CONVENIENT OUTLET	120	15.0	1	48"	WALL	—	5-15P	MAX 3 PER CIRCUIT
E01	3	P.O.S.	120	15.0	1	48"	WALL	—	5-15P	—
E05	1	BLENDER STATION	120	15.0	1	24"	WALL	X	—	BRANCH TO RECEPTACLE IN EQUIPMENT
E06	1	BACK BAR COOLER	120	8.8	1	24"	WALL	—	5-15P	—
E07	2	MUG FROSTER	120	8.2	1	24"	WALL	—	5-15P	—
E08	1	GLASS WASHER	208	25.7	3	24"	WALL	X	—	BTC: PROVIDE DISCONNECT
E09	2	MARGARITA MACHINE	208	20.0	3	54"	WALL	X	—	BTC
E12	1	WORK TOP FREEZER	115	8.3	1	24"	WALL	—	5-15P	—
E13	1	BACK BAR COOLER	120	8.8	1	24"	WALL	—	5-15P	—
E14	1	CHIP WARMER	120	12.6	1	48"	WALL	—	5-15P	—
E17	1	SALSA COOLER	115	4.9	1	24"	WALL	—	5-15P	—

NINFA'S ON NAVIGATION
2704 NAVIGATION BLVD.
HOUSTON, TX 77003

C & T DESIGN & EQUIPMENT Co., Inc.
2895 TOBEY DR. INDIANAPOLIS, INDIANA 46219
PHONE: 317-898-9602
DESIGN & SALES TO ALL TYPES OF FOOD SERVICE OPERATIONS
FOODSERVICE ELECTRICAL ROUGH-IN PLAN

PROJECT MANAGER
E-MAIL ADDRESS
CHARLES MUNRO
CMUNRO@C-DESIGN.COM

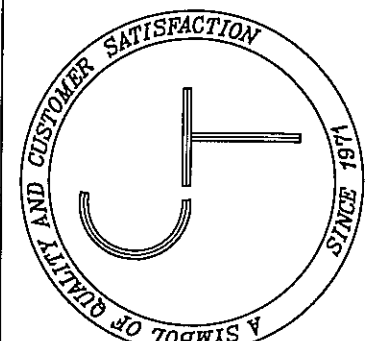

JOB NO. 90-6206

SHEET NUMBER

K3
OF 03

ELECTRICAL NOTES

- THE FOLLOWING WORK IS TO BE PERFORMED BY THE ELECTRICAL CONTRACTOR:
- ROUTING IN AND FINAL CONNECTIONS OF ELECTRICAL SYSTEMS TO FOODSERVICE EQUIPMENT
 - COMMUNICATION SYSTEMS, CLOCKS AND STAFF TIME CLOCKS IN FOODSERVICE AREA.
 - CONDUIT AND WIRING FROM DISPOSER SWITCH TO TIME DELAY MAGNETIC STARTER, MOTOR AND SOLENOID VALVES, ALL BELOW COUNTER TOP.
 - WALL SWITCH FOR LIGHT FIXTURES IN EXHAUST HOODS.
 - WALL SWITCH FOR FAN MOTOR FOR EXHAUST HOODS SYSTEM.
 - WIRING TO AND INSTALLATION OF ACCESSORIES (IF ANY) WHICH ARE FURNISHED STANDARD WITH FOODSERVICE EQUIPMENT.
 - EMERGENCY LIGHTING AND/OR POWER SYSTEMS.
 - ALL DISCONNECT SWITCHES AS REQUIRED. (NEUA 4, WATERPROOF SUGGESTED).
 - SPECIAL NOTE: ANSIUL FIRE SUPPRESSION SYSTEMS IS TO BE CONNECTED TO CORRESPONDING SHUNT TRIP BREAKERS FOR SHUT DOWN OF COOKING EQUIPMENT BELOW VENTILATOR DURING FIRE. IN ADDITION, THE SUPPRESSION SYSTEM SHALL BE REQUIRED TO BE INTERCONNECTED WITH MECHANICAL GAS SHUT OFF DURING FIRE.
 - DIVISION 16 TO PROVIDE 1" EMPTY CONDUIT FROM OCTAGONAL JIB IN WALL AT 54" FROM FINISHED FLOOR TO 6" ABOVE CEILING AND EXIT WALL - FOR FIRE SYSTEM REMOTE PULL.

ELECTRICAL LEGEND

- | | |
|-----|--|
| DR | DUPLEX RECEPTACLE |
| DR | DUPLEX RECEPTACLE IN WALL |
| PMR | PEDESTAL MOUNT DUPLEX RECEPTACLE |
| SR | SINGLE RECEPTACLE |
| SR | SINGLE RECEPTACLE IN WALL |
| SR | PEDESTAL MOUNT SINGLE RECEPTACLE |
| JB | JUNCTION BOX |
| JB | JUNCTION BOX IN WALL |
| JB | PEDESTAL MOUNT JUNCTION BOX |
| DCR | DROP CORD RECEPTACLE |
| CS | CONDUIT STUB |
| MC | LIGHT FIXTURE |
| SW | MOTOR CONTROL SWITCH |
| AFF | SWITCH (TOGGLE) |
| BTC | ABOVE FINISHED FLOOR
BRANCH TO CONNECTION |