

SLAB PLAN KEYED NOTES

- FLOOR SLAB TO BE POURED SEPARATELY IN THIS AREA. SLOPE TO DRAIN AS SHOWN
- SEALED CONCRETE
- PROVIDE CONCRETE BALLAST AT EACH DUCT SUPPORT AND UNDER EACH UNDER FLOOR JUNCTION BOX (BEFORE DUCT IN LEVELED AND ALIGNED) TO HOLD THE DUCT SECURELY IN PLACE DURING POURING OF CONCRETE FLOOR.


FLOOR SLAB GENERAL NOTES

- REFER TO FLOOR PLAN-PLUMBING FOR ADDITIONAL IN FLOOR PLUMBING FIXTURES NOT SHOWN ON THE SLAB PLAN.
- ALL EXPOSED CONCRETE FLOORS SHALL BE SEALED.
- FINAL LOCATION OF FITTINGS AND FIXTURES SHALL BE COORDINATED WITH FIXTURE FIELD REPRESENTATIVE BEFORE BLOCKOUTS ARE FILLED.
- BLOCKOUTS AND/OR ROUGH IN REQUIREMENTS. SET REINFORCING, VAPOR BARRIER AND BACKFILL BLOCKOUT WITH CONCRETE TO MATCH SLAB AFTER INSTALLATION OF FIXTURE.
- DIMENSIONS THIS SHEET ARE SLAB SPECIFIC DIMENSIONS. FOR WALL DIMENSIONS SEE SHEET A-2.1
- ALL FLOOR TRANSITIONS TO BE FLUSH.
- USE FIFTEEN (15) MIL. POLYETHYLENE UNDER SLAB AS VAPOR BARRIER, WRAP AND TAPE VISQUEEN AT FOUNDATION. RE: STRUCTURAL DRAWINGS FOR SLAB SPECIFICATIONS.
- REFER TO M.E.P. DRAWINGS FOR ADDITIONAL HOUSEKEEPING PADS. PADS SHALL BE 6" HIGH WITH 6"x6"x8/16" NUM. PERIMETER OF PADS SHALL EXTEND A MIN. OF 6" BEYOND EDGES OF EQUIPMENT.
- PROVIDE CONCRETE BALLAST AT EACH UNDER FLOOR DUCT SUPPORT AND UNDER EACH UNDER FLOOR JUNCTION BOX (BEFORE DUCT IN LEVELED AND ALIGNED) TO HOLD THE DUCT SECURELY IN PLACE DURING POURING OF CONCRETE FLOOR.

SLAB PLAN
A2.3 SCALE: 1/8" = 1'-0"

SLAB SYMBOL LEGEND

	FLOOR DRAIN
	TRENCH DRAIN
	HUB DRAIN
	WATER CLOSET -- SEE SPECIFICATIONS
	NON-FOOD PREP. AREA LAVATORY -- SEE SPECIFICATIONS
	ACCESSIBLE LAVATORY -- SEE SPECIFICATIONS
	FOOD PREP. AREA LAVATORY -- SEE SPECIFICATIONS
	SERVICE SINK -- SEE SPECIFICATIONS
	FLOOR SINK -- REFER PLUMBING SPECS

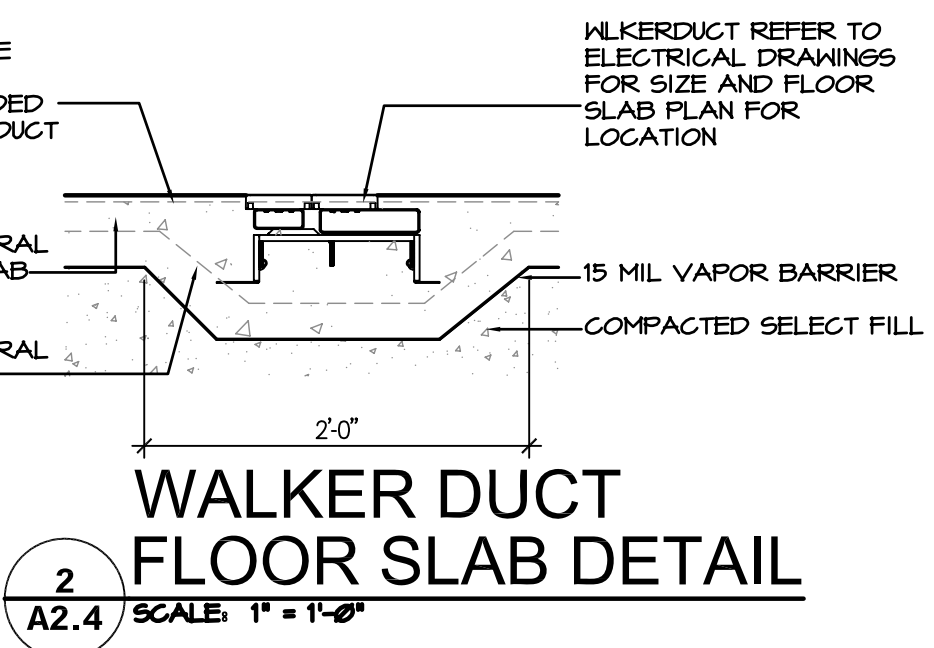

Hermes Architects

Members A.L.A.
1177 West Loop South, Ste. 500
Houston, Texas 77027
Tel. 713-785-3644
www.hermesarchitects.com
Houston • Dallas • Ft. Worth

This document is an instrument of service protected by the copyright law of the United States of America, 17 U.S.C. § 102, and shall not be copied or reproduced without the express written consent of Hermes Architects, Inc.



Shaw's Jewelers
West Gray
1021 West Gray Ave.
Houston, Texas

Shaw's Jewelers
1014 West Gray Street
Houston, Texas 77019

DATE 11.11.2011
PROJECT NO. 1102100
DRAWN BY --
CHECKED BY --

Floor Slab Plan

A2.4