



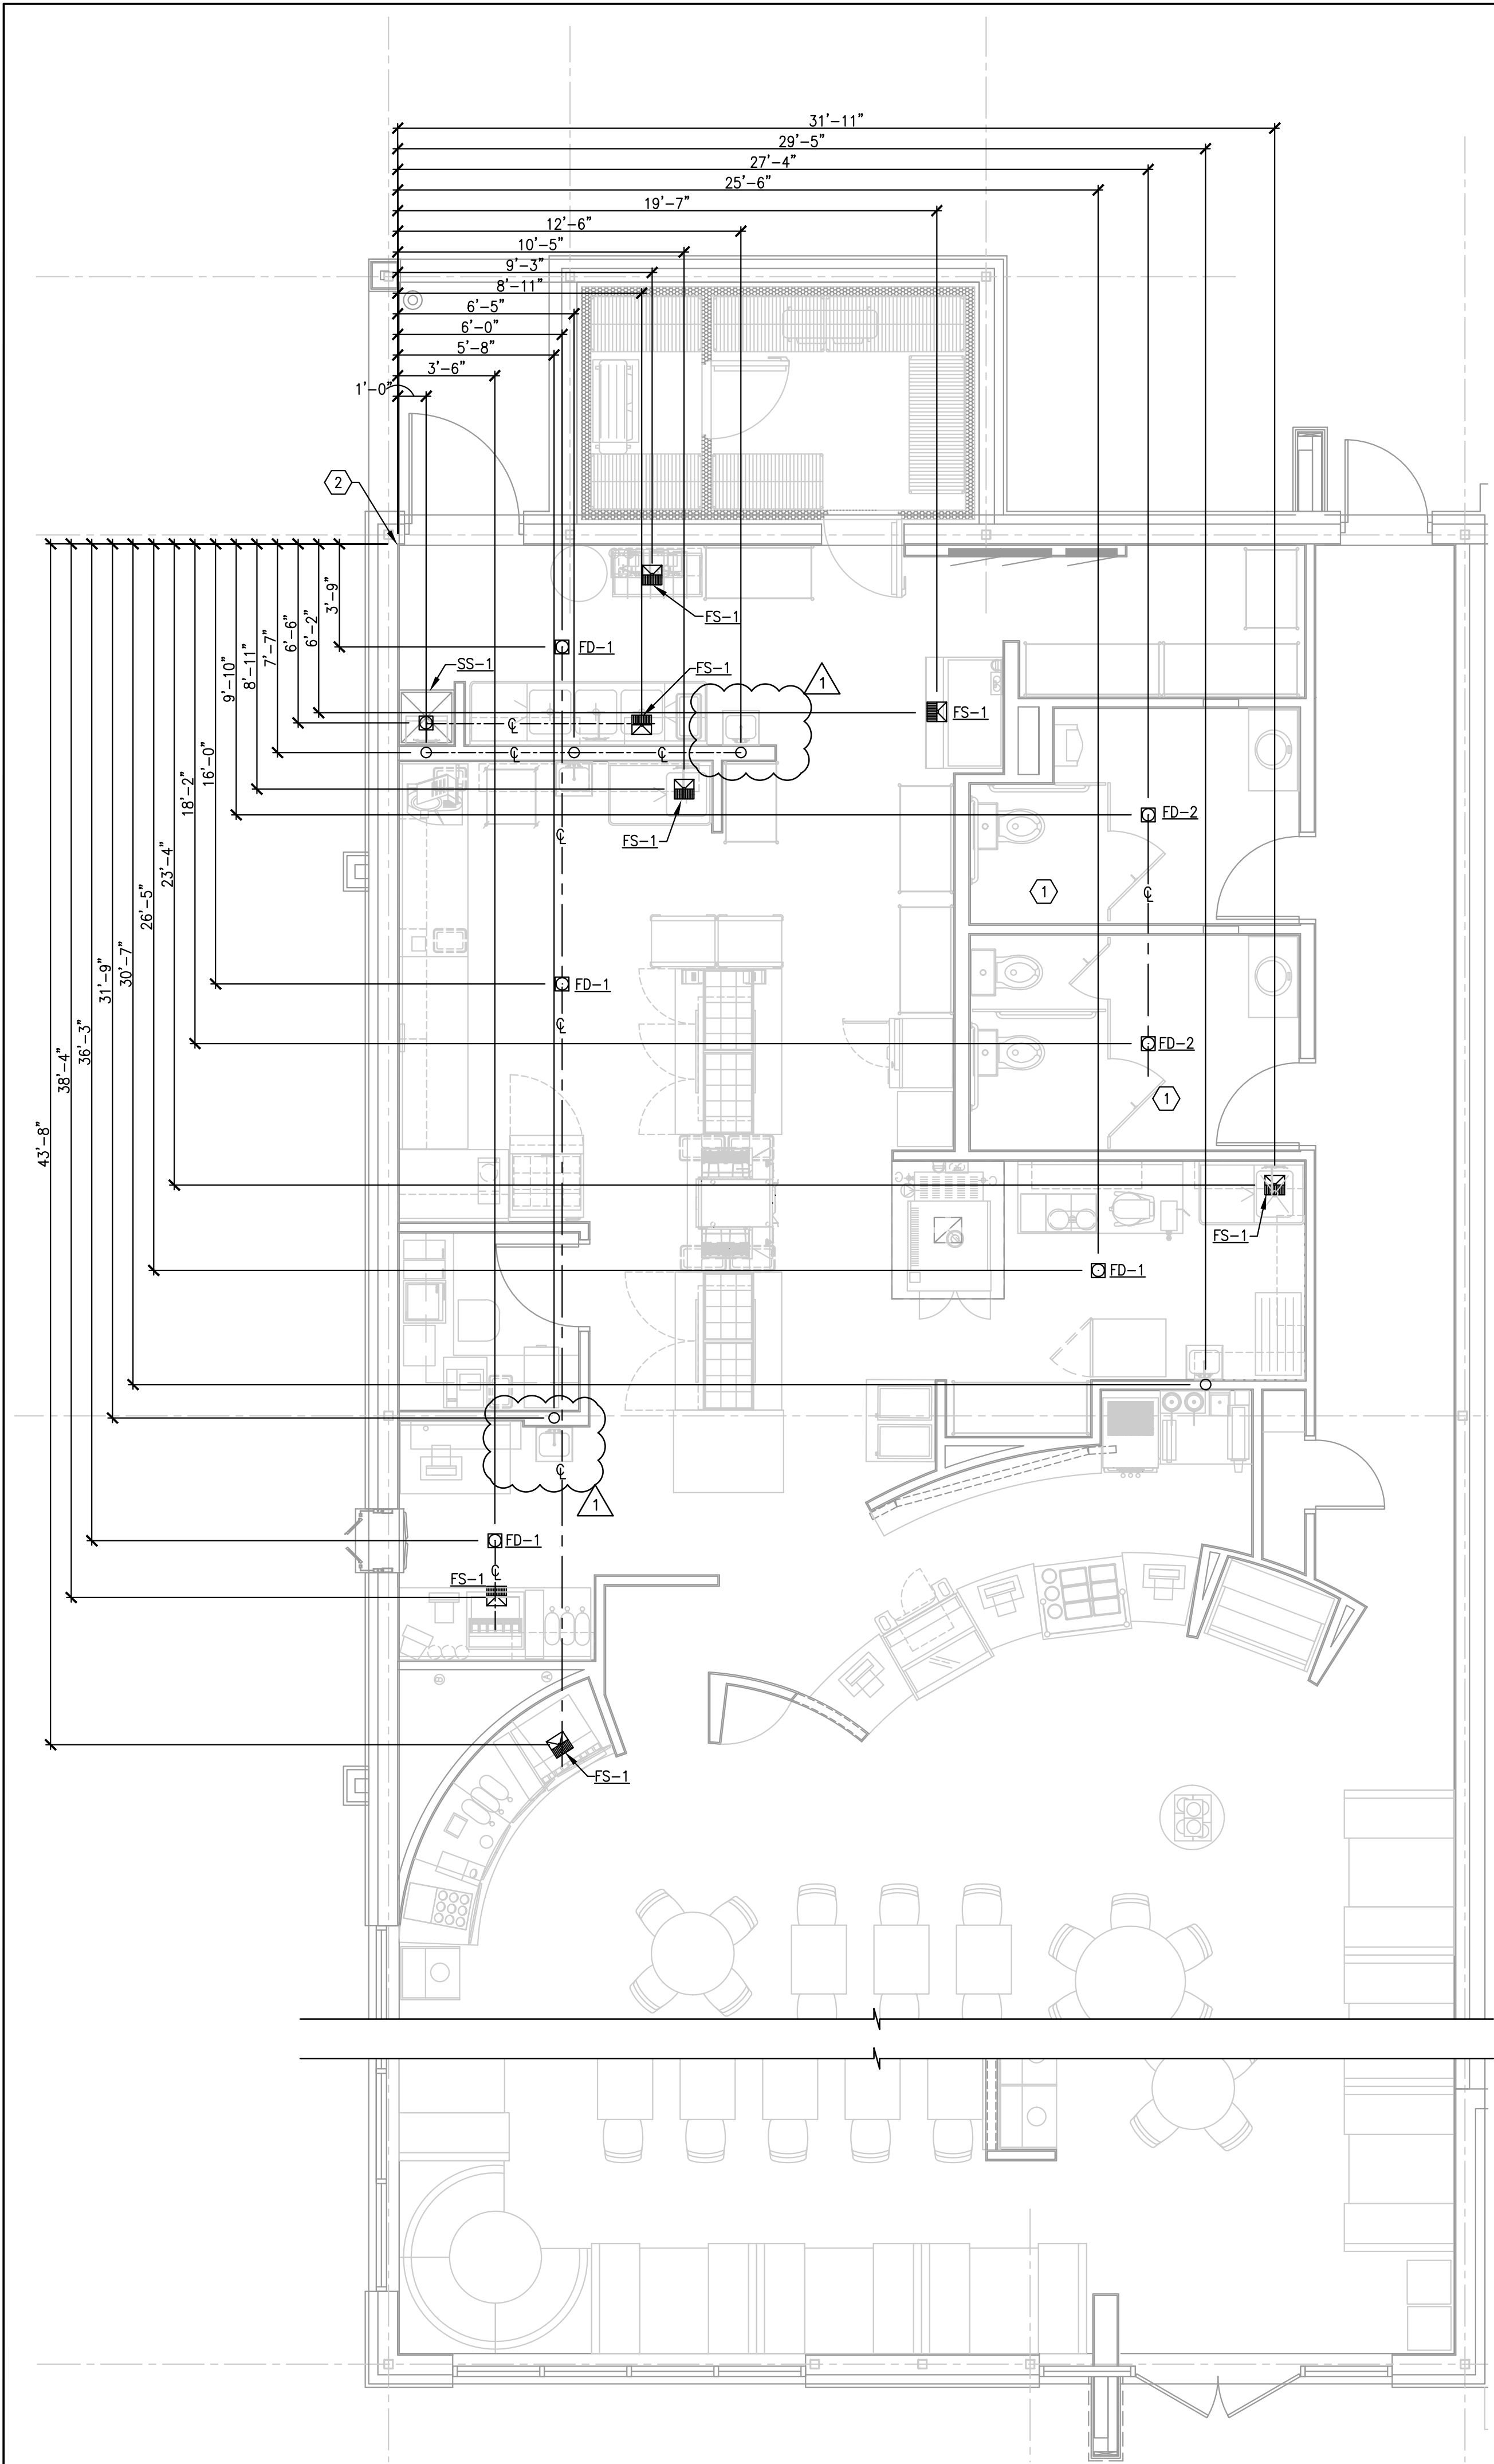

UNDERSLAB ROUGH-IN PLAN  
SCALE: 1/4"=1'-0"


1

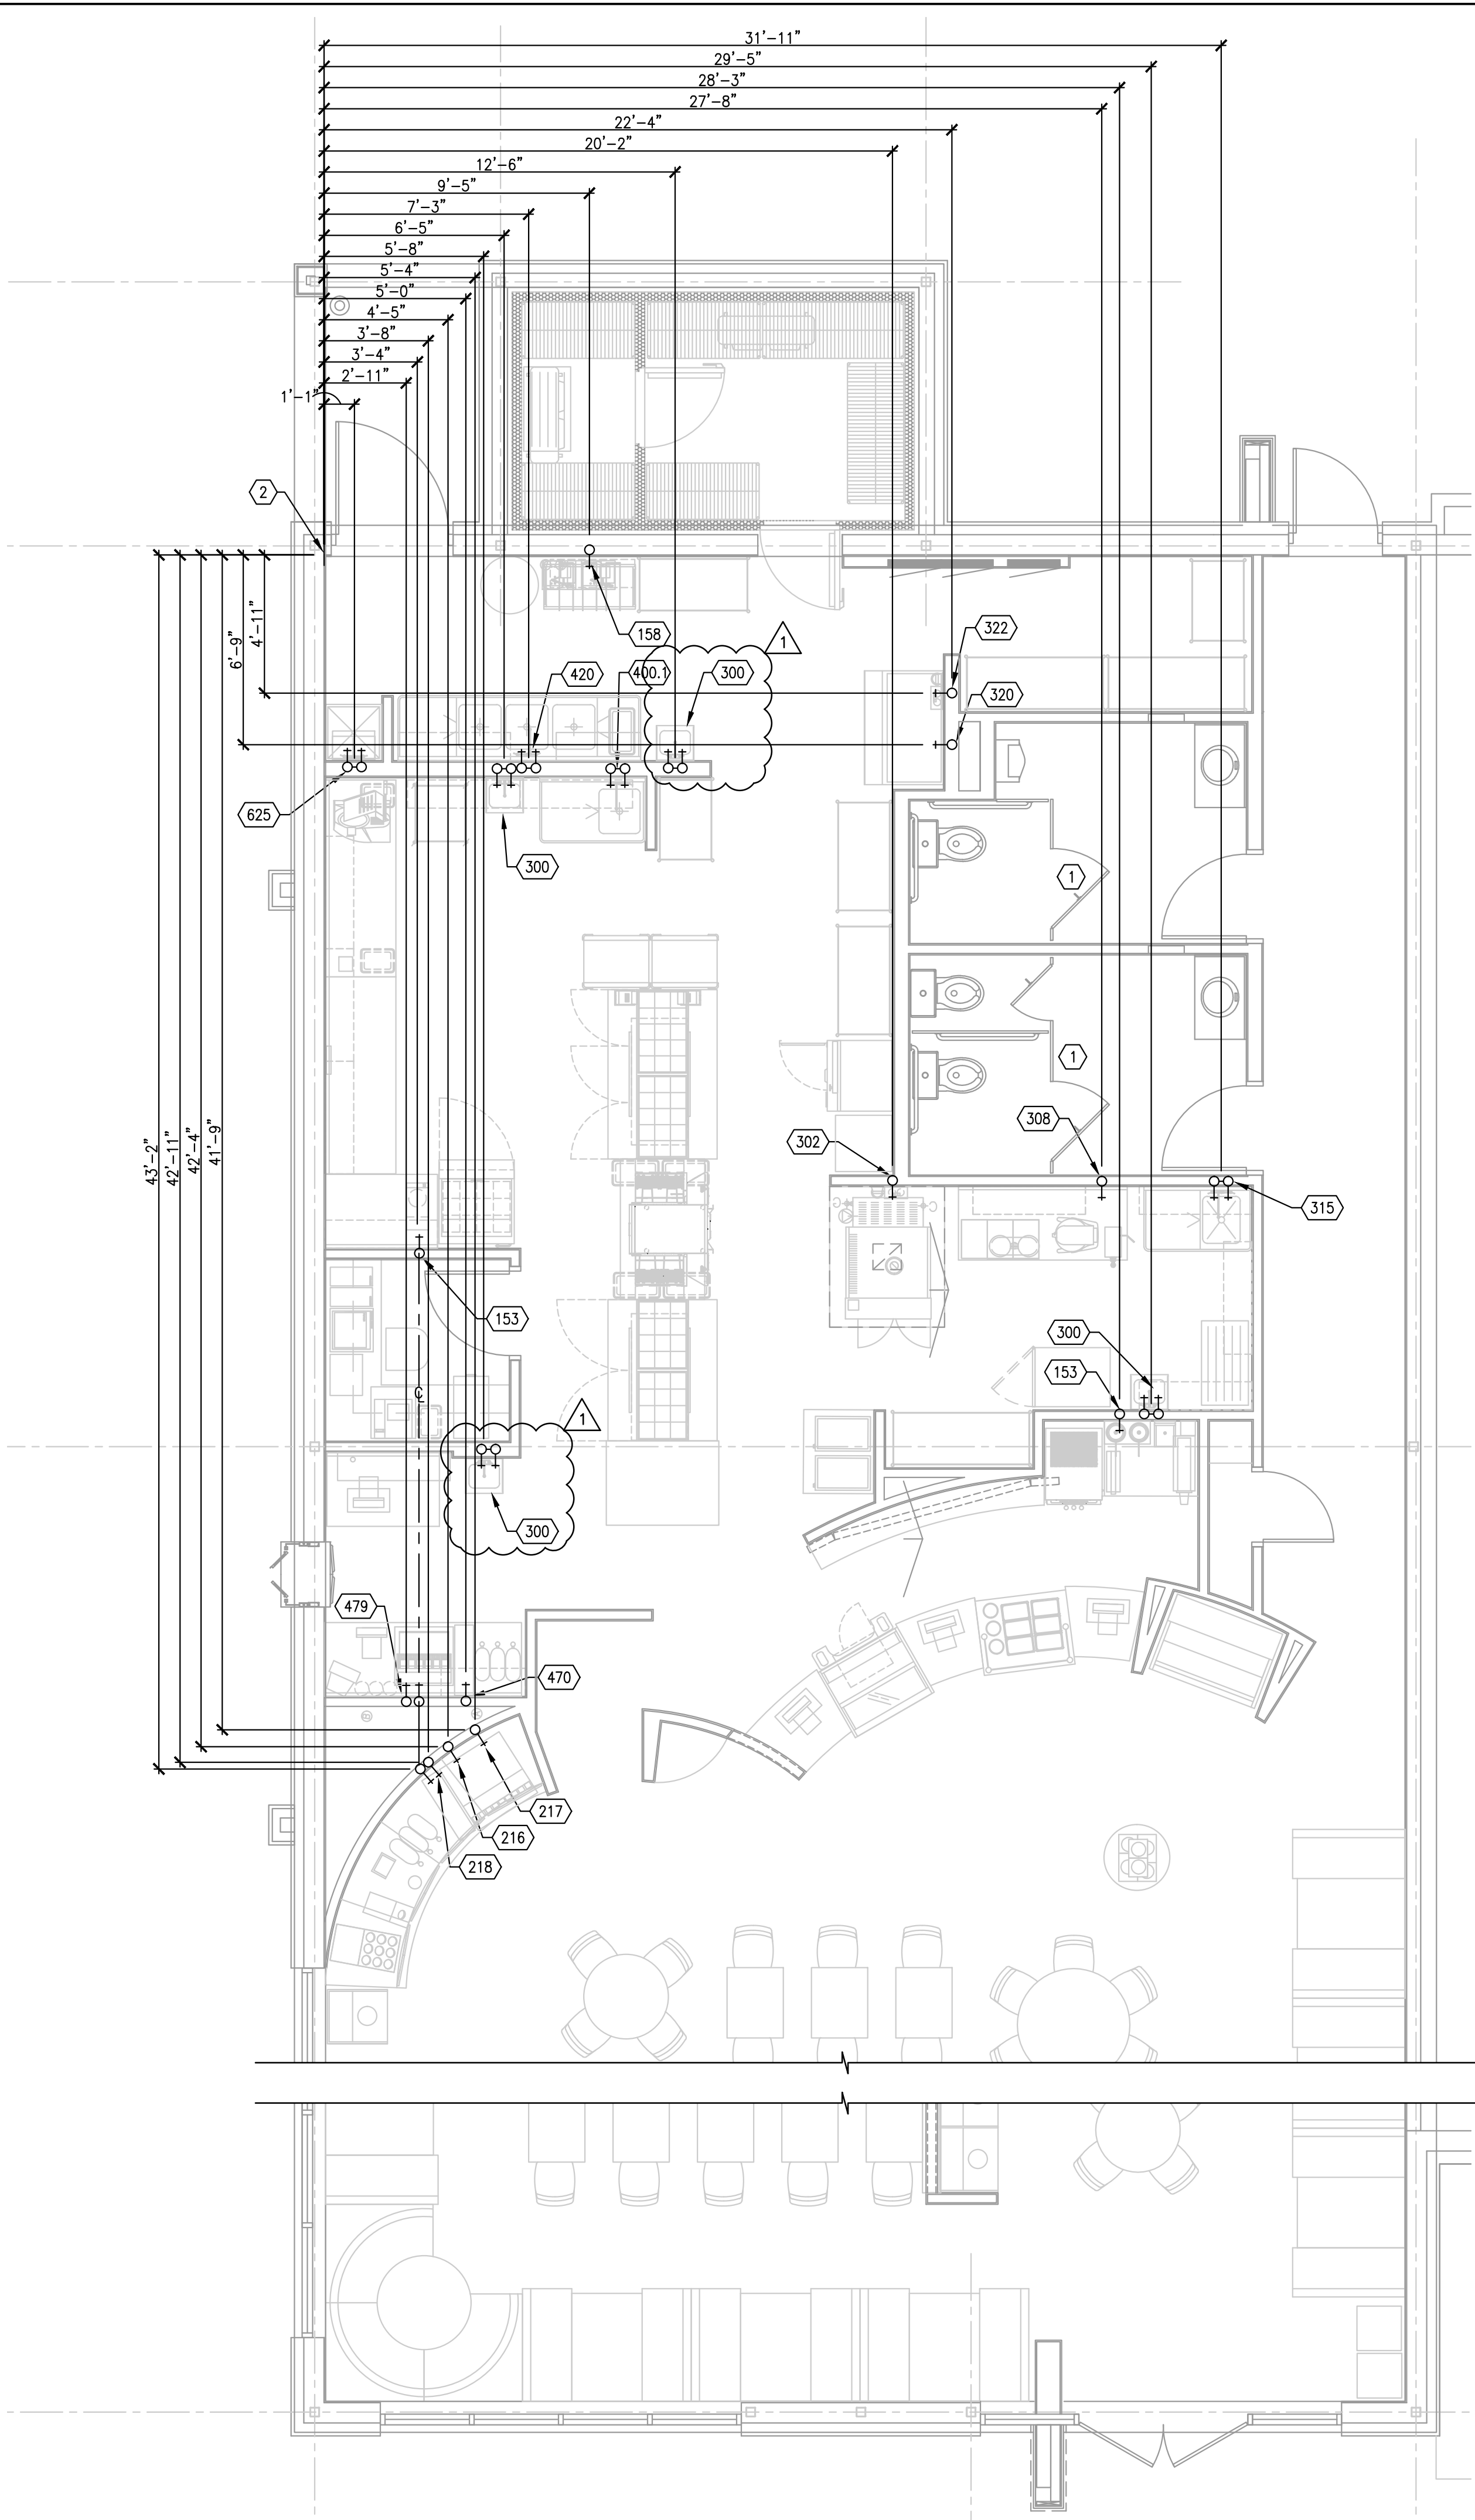

WATER ROUGH-IN PLAN  
SCALE: 1/4"=1'-0"

2


| KEYED NOTES |                                                                                     |
|-------------|-------------------------------------------------------------------------------------|
| 1.          | REFER TO ARCHITECTURAL PLANS FOR ROUGH-IN DIMENSIONS OF RESTROOM PLUMBING FIXTURES. |
| 2.          | DIMENSIONS SHOWN ARE FROM THE INSIDE FACE OF EXISTING STRUCTURAL LANDMARK.          |

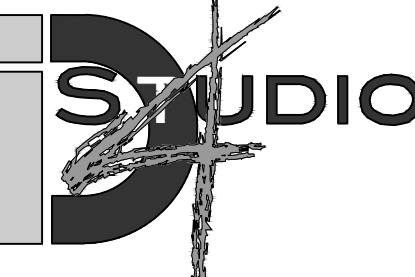

**ID STUDIO 4, LLC**  
1431 GREENWAY DR, SUITE 150  
IRVING, TEXAS 75038  
TEL: 972.870.1288  
WWW.IDSTUDIO4.COM

CLIENT:  
FOCUS Brands  
301 S. CONGRESS AVE., STE 11000  
AUSTIN, TX 78701  
512.236.3600  
www.focusbrands.com

TBPE FIRM REGISTRATION# F-11678

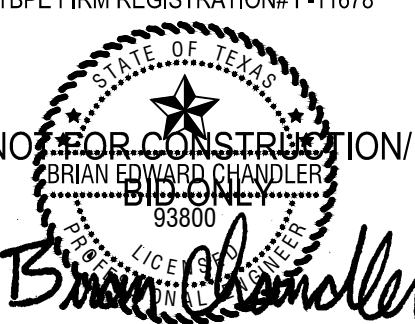

NOT FOR CONSTRUCTION/  
BRIAN EDWARD CHANDLER  
LICENSED PROFESSIONAL ENGINEER  
83800  
Brian Chandler

12-15-11

**SCHLOTZSKY'S DELI  
THE TRAILS AT 620**  
8300 N. FM 620 STE 103  
AUSTIN, TX 78776

CLIENT: FOCUS Brands  
301 S. CONGRESS AVE. STE 11000  
AUSTIN, TX 78701



| DATE     | DESCRIPTION      |
|----------|------------------|
| 11.21.11 | ISSUE FOR PERMIT |
| 12.16.11 | ISSUE FOR BID    |
|          |                  |
|          |                  |
|          |                  |

| DATE | DESCRIPTION              |
|------|--------------------------|
| 1    | 12.09.11 HEALTH COMMENTS |
|      |                          |
|      |                          |
SHEET TITLE:  
**PLUMBING  
ROUGH-IN PLANS**

SHEET NUMBER:  
**P1.0**

PROJECT NUMBER:  
**FOC11003**