

Rev.	By	Date

TRIMCOS DESIGN & ENG.
 11222 RICHMOND AVE.
 SUITE# 225 HOUSTON TX, 77082
 (281) 558-9696
 F-3926

SCHLOTZSKY'S VICTORY LAKES TOWN CENTER
 TRACK 7A, NEC INTERSTATE HWY 45 & F.M.646
 LEAGUE CITY TEXAS 77000

ARCH
Woo Associates, LLC
 ARCHITECTS - PLANNERS
 13734 Brandford Green Dr.
 Houston, TX, 77083
 (832) 228-8128

Date 07-14-2010
 Scale AS SHOWN
 Drawn by
 Job#:
 SHEET NO:
P-01

PIPE PLUMBING MATERIAL LEGEND	
1	WATER PIPING INSIDE BUILDING WILL BE COPPER.
2	SANITARY SEWER IS TO BE SCHEDULE 40 PVC W/DWV FITTINGS
3	VENT PIPING SHALL BE SCHEDULE 40 PVC
4	CLEANOUTS SHALL BE ZURN OR APPROVED EQUAL
5	WATER LINES ABOVE SLAB SHALL BE TYPE "L" COPPER. WATER LINES BELOW THE SLAB SHALL BE TYPE "M".
6	HOT WATER: INSULATION 1" FIBERGLAS PIPE
7	GAS PIPING: WILL BE BLACK IRON PIPE


PLUMBING SYMBOL LEGEND			
	NEW PVC WASTE LINE	LAV	LAVATORY
	NEW PVC VENT LINE	WC	WATER CLOSET
	NEW COLD WATER LINE	FD	FLOOR DRAIN
	HOT WATER LINE	FS	FLOOR SINK
	HOT WATER LINE RETURN	3-S	3 COMP. SINK
	GAS SUPPLY	FCO	FLOOR CLEANOUT
	ISOLATION VALVE	(HW)	WATER HEATER
	PIPE UP		
	PIPE DOWN		

NOTE: NOT ALL SYMBOLS SHOWN MAY BE USED ON THIS PROJECT.

- CODED NOTES**
- SERVICE SHUT OFF VALVE AND WATER ENTRY
 - 3/4" COLD WATER TO DROP DOWN IN WALL TO SERVE WATER CLOSET.
 - 1/2" CW AND 1/2" HW TO DROP DOWN IN WALL TO SERVE LAVATORY.
 - 1/2" CW AND 1/2" HW TO DROP DOWN IN WALL TO SERVE TO SINK.
 - 1/2" CW AND 1/2" HW TO DROP DOWN IN WALL TO SERVE TO PREP.SINK.
 - 1/2" CW AND 1/2" HW TO DROP DOWN IN WALL TO SERVE TO MOP.SINK.
 - 1/2" CW AND 1/2" HW TO DROP DOWN IN WALL TO SERVE TO 3 COMP.SINK.
 - 3/4" COLD WATER TO DROP DOWN IN WALL TO SERVE SODA MACHINE.
 - 3/4" COLD WATER TO DROP DOWN IN WALL TO SERVE TEA MACHINE.
 - 1/2" COLD WATER TO DROP DOWN IN WALL TO SERVE WATER HEATER.

PLUMBING FIXTURE SCHEDULE

SYMBOL	DESCRIPTION	PROVIDE THE FOLLOWING SIZE BRANCH CONNECTION TO THE DISTRIBUTION MAIN—UNLESS OTHERWISE SPECIFIED	CW	HW	SAN.	VENT	REMARKS	"P" TRAP SIZE	SPECIFICATION
WC	WATER CLOSET	3/4"	1/2"	1/2"	4"	2"	MOUNT SUPPLY LINE 9" AFF MIN.	1 1/4"	INTEGRAL W/STANDARD "GADGET ELONGATED, PRESSURE ASSISTED TOILET" #2333100 15 GALLON PER FLUSH LOW FLOW TOILET WITH CHROME PLATED RIFLED RISER. MOUNT 9" AFF MIN.
LAV	LAVATORY	1/2"	1/2"	2"	2"	2"	--	1 1/4"	LAVATORY WITH RELIANT 2385.001 SINGLE LEVER 4" CENTER SET FAUCET W/POP UP DRAIN 1 1/4" C.P. P-TRAP 3/8" CHROME PLATED ANGLE STOPS W/FLEX RISERS.
3 COMP. SINK	3 COMPARTMENT SINK	1/2"	1/2"	2"	2"	2"	--	1 1/4"	--
P.S.	PREP SINK	1/2"	1/2"	2"	2"	2"	--	--	--
M.S.	MOP SINK	1/2"	1/2"	2"	2"	2"	--	--	--
S.M.	SODA MACHINE	1/2"					--	--	--
W.H.	WATER HEATER	3/4"					100 GAL.		

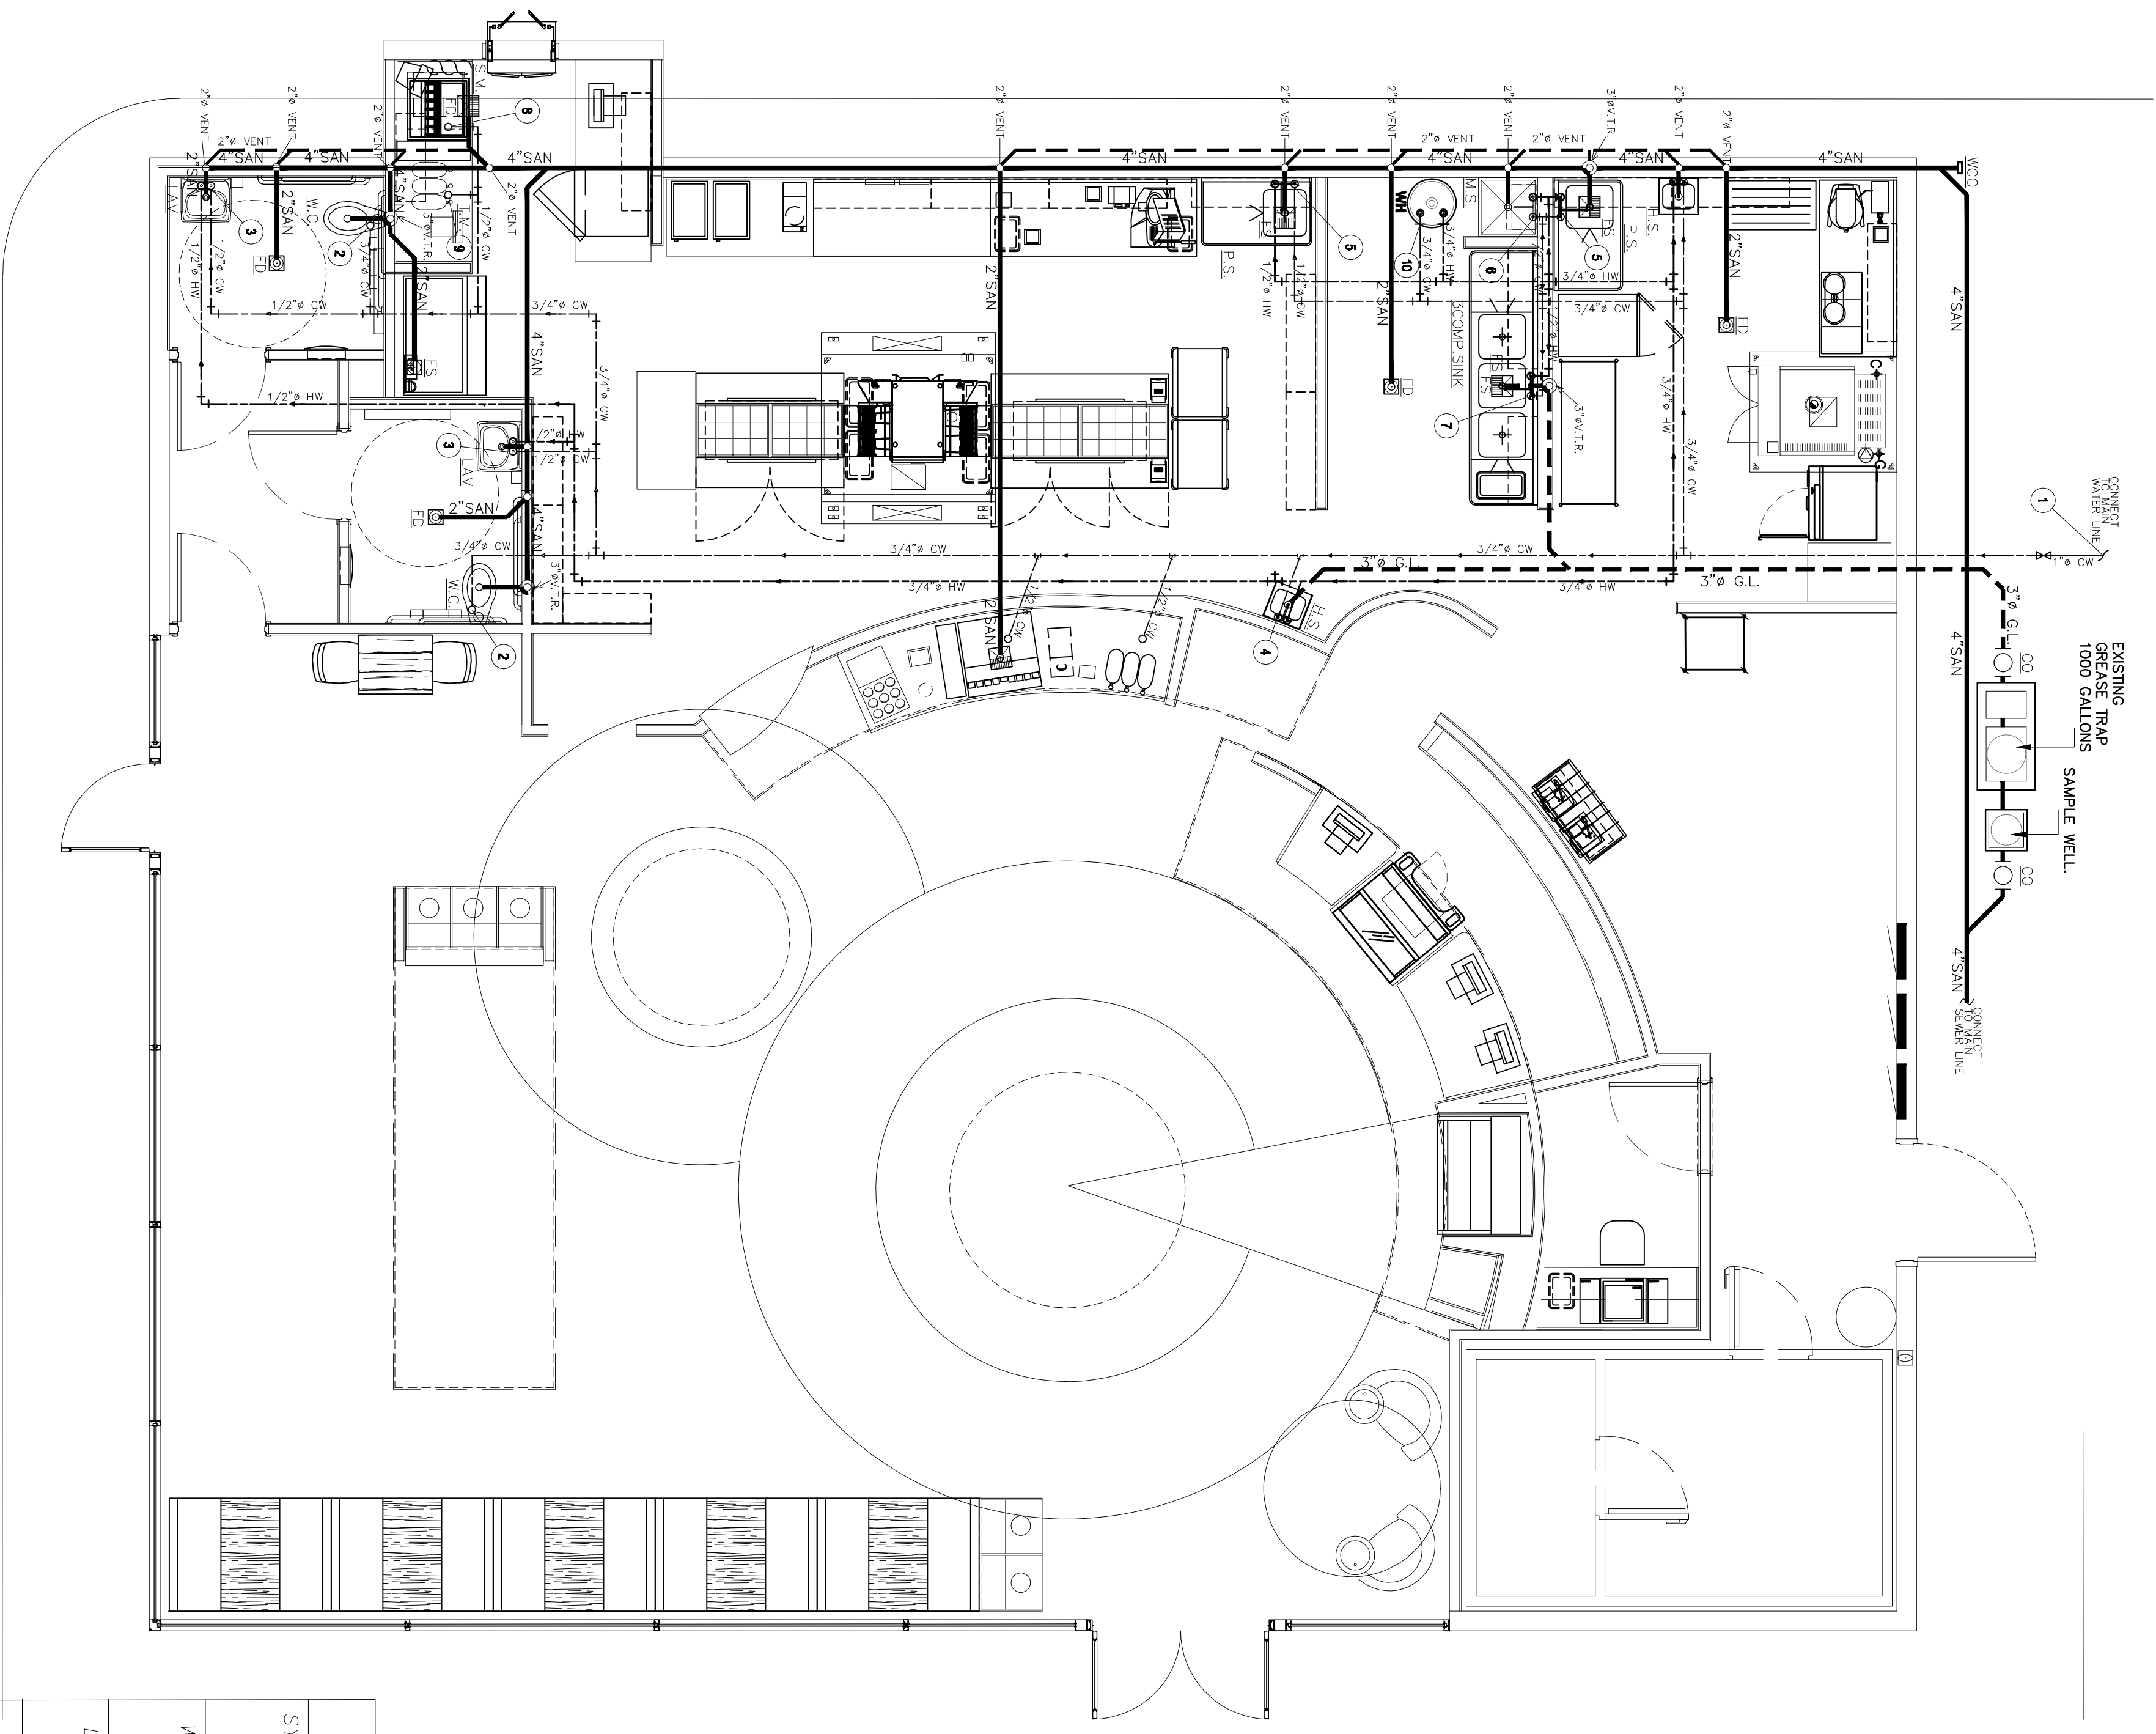

1 ENLARGED PLUMBING PLAN
 Scale: 1/4"=1'-0"