


FIRE SPRINKLER NOTE:
 LICENSED SPRINKLER ENGINEER OR LICENSED SPRINKLER CONTRACTOR, TO VERIFY THE SYSTEM AND TO OBTAIN THE NECESSARY PERMITS. REFER TO SPECIFICATIONS FOR ADDITIONAL INFORMATION.

- PLUMBING KEYS NOTES**
- 1" SWIMMER SERVICE STUB OUT AND CONNECT TO SITE UTILITY. RE: CIVIL DRAWINGS.
 - 6" FIRE SERVICE LINE. STUB OUT AND CONNECT TO SITE UTILITY. RE: CIVIL DRAWINGS.
 - 3" DOMESTIC WATER SERVICE. STUB OUT AND CONNECT TO SITE UTILITY. RE: CIVIL DRAWINGS.
 - 6" FIRE LINE ENTRY FROM FIRE PUMP. RE: DETAIL #2 ON SHEET P2.1.
 - 3" DOMESTIC WATER ENTRY. RE: DETAIL SHEET P2.1.
 - VALVE AND CAP 1 1/2" COLD WATER FOR TANK USE. TYPICAL.
 - 4" DOMESTIC WATER LINE DOWN FROM SECOND FLOOR. RE: 1/9/12 FOR CONTINUATION.
 - 2" SWIMMER WASTE LINE DOWN FROM SECOND FLOOR. RE: 1/9/12 FOR CONTINUATION.
 - 2 1/2" CW LINE UP TO SECOND FLOOR. RE: 1/9/12 FOR CONTINUATION.
 - 3" SWIMMER WASTE LINE DOWN FROM D2-1 ABOVE.
 - REGRESSED VALVE BOX WITH BALL VALVE.
 - STUB-OUT AND CAP 2" VENT LINE ABOVE CEILING.
 - 4" GREASE LINE. CAP AT BOTH ENDS.
 - RE: CIVIL DRAWINGS FOR CONTINUATION.
 - 3" SWIMMER WASTE LINE DOWN FROM D2-2 ABOVE.
 - 2 1/2" FIRE LINE DOWN TO FIRE DET. 2 1/2" ANGLE VALVE CONNECTION WITH CAP W/ COCK.
 - 17" CONTINUATION PIPE UP TO SECOND FLOOR. RE: P1.2 FOR CONTINUATION.
 - 1" FIRE SPRINKLE TEST DOWN LINE DOWN FROM SECOND FLOOR. RE: 1/9/12 FOR CONTINUATION.
 - STUB-OUT 1" F.S. TEST DOWN LINE AT 12' ABOVE GRADE.
 - STUB-OUT 2 1/2" FIRE SPRINKLER LINE FOR RETAIL SPACES.

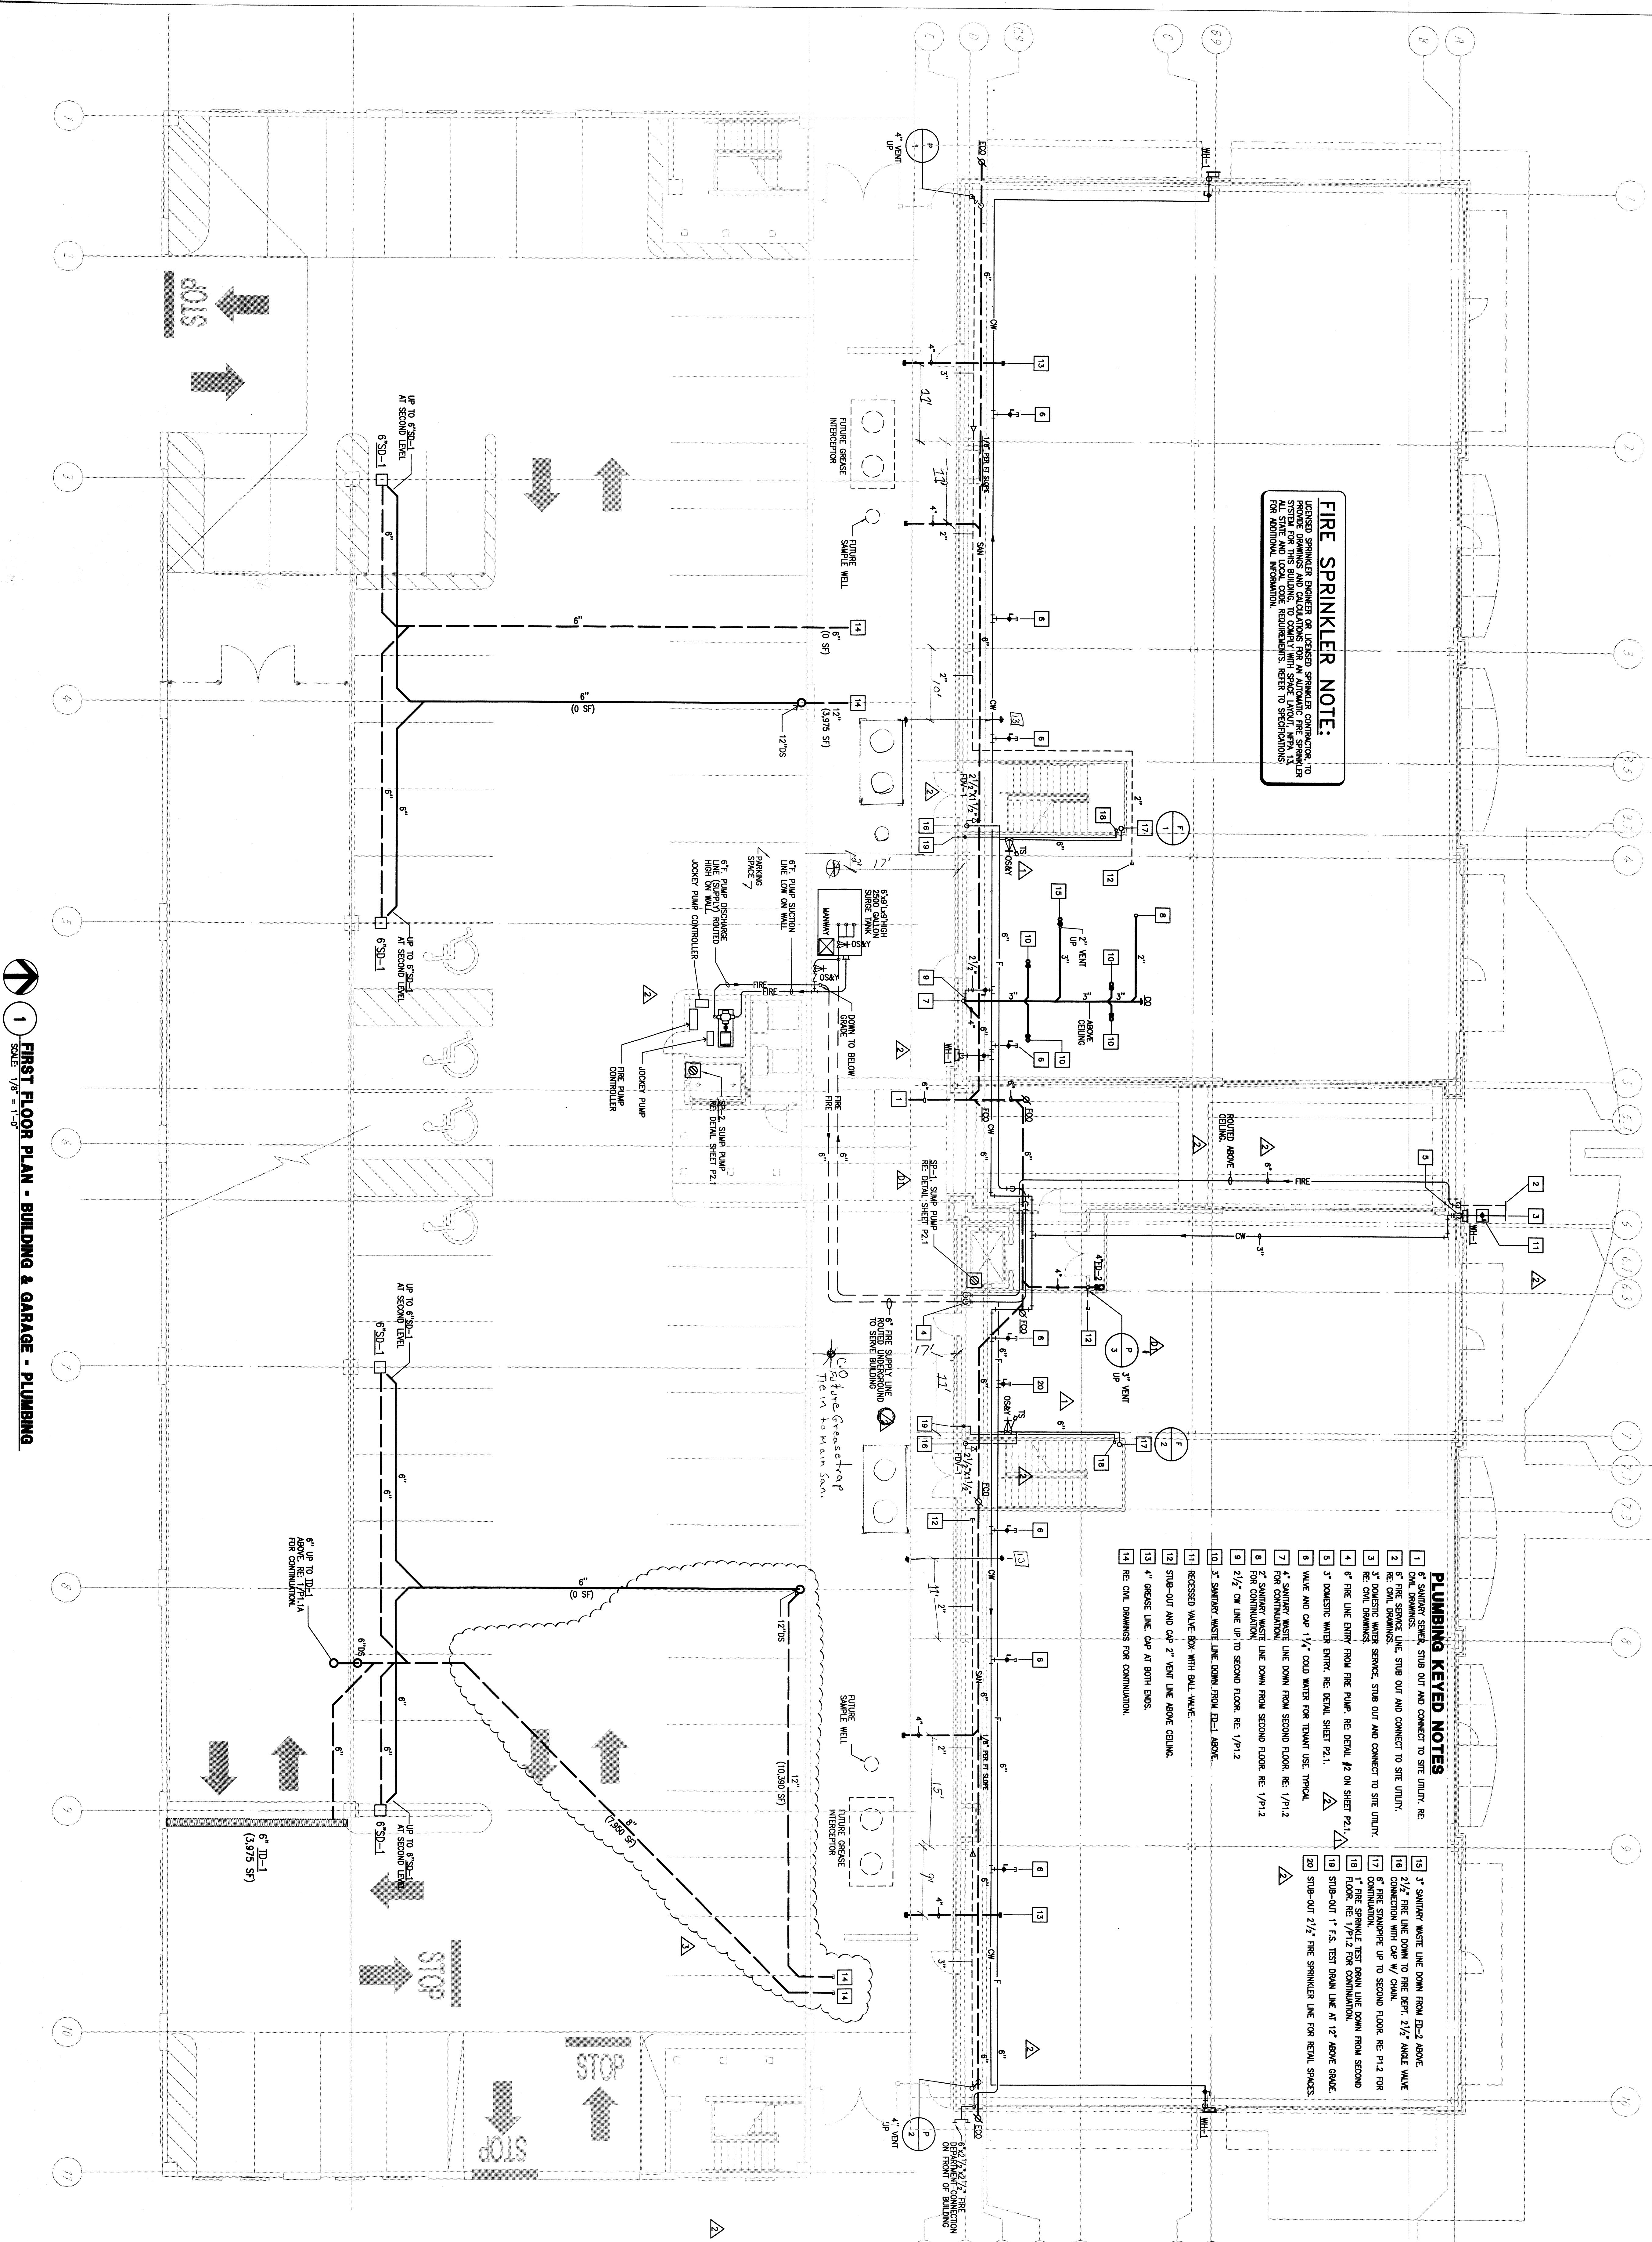


1 FIRST FLOOR PLAN - BUILDING & GARAGE - PLUMBING
 SCALE: 1/8" = 1'-0"

4600 Washington
 Retail/Office
 Parking Garage
 HOUSTON, TEXAS

ORR COMMERCIAL
 8554 Katy Freeway, Suite 100
 Houston, Texas 77024

DATE: 08/20/07
 PROJECT NO.: 03007008
 DRAWN BY: JAM
 CHECKED BY: MK

P1.1

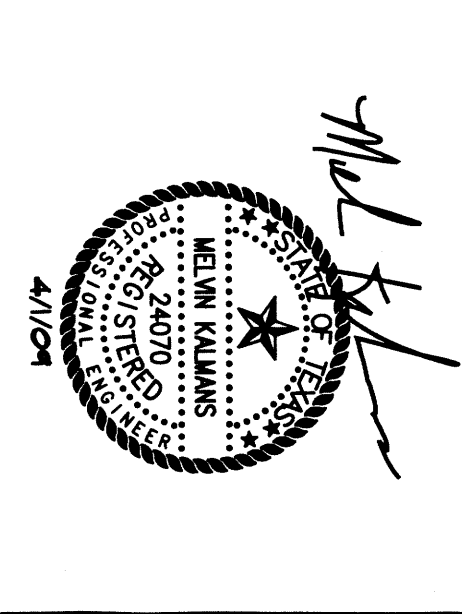

Hermes Architects

Members A.I.A.
 7915 Westgen Drive
 Houston, Texas 77063
 Tel 713-785-3644
 Fax 713-953-2515
 www.hermesarchitects.com

R.H. George and Associates, Inc.
 Consulting Engineering
 10930 W. Sam Houston Pkwy N., Suite 900
 Houston, Texas 77064 (281) 664-1900
 PROJECT NO: 03007008 rhgeorge@rhgeorge.com

| | |
|----------|--------------------------|
| 08-31-07 | Issued for Bid & Permit. |
| 12-17-07 | Per City Comments. |
| 01-23-08 | Per Fire Authority. |
| 03-05-08 | Issued for Construction. |
| 11-11-08 | CCD #5 |
| 04-01-08 | REVISED PER CIVIL. |